

WD-1

DEMARKATION

WORKING DRAWING - I

SHEET NO.

AREA OF PROPOSED SITE

(BY RECTANGLE AREA METHOD)

$$\begin{aligned} \text{AREA OF } \triangle ABCD &= LB \\ &= (28 \times 21.50) \text{ M} \\ &= 602 \text{ SQ. M} \end{aligned}$$

(BY TRIANGULATION METHOD)

$$\begin{aligned} \text{AREA OF } \triangle ABCD &= A(\triangle ABC) + A(\triangle ADC) \\ &= \frac{1}{2} AC \times BE + \frac{1}{2} AC \times DE \\ &= 301 + 301 \\ &= 602 \text{ M}^2 \end{aligned}$$

NOTE-

1. ALL DIMENSIONS ARE IN MM UNIT UNTIL SPECIFIED.
2. DO NOT MEASURE DRAWING, FOLLOW WRITTEN DIMENSIONS ONLY.
3. PLEASE REFER TO THE ARCHITECT IN CONCERN TO ANY QUERY OF DRAWING.
4. THE DRAWING IS THE PROPERTY OF ARCHITECT AND SHALL NOT BE USED OR REPRODUCED WITHOUT THEIR WRITTEN CONCENT.

SCALE	DATE	DRAWN BY	CHECKED BY	REV NO.
		VK		


SUBJECT-

PROPOSED
RESIDENCE AT
HOMKAR NAGAR,
SOLAPUR.





ARCHITECT -


NAME- VAISHNAVI GUNVANT KARBHARI.
BATCH- 3RD YEAR [SEM-VI].
COLLEGE NAME- SSSM'S COLLEGE
OF ARCHITECTURE, SOLAPUR.
ROLL NO. - SSM/21/08.

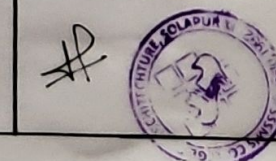

7-6-24

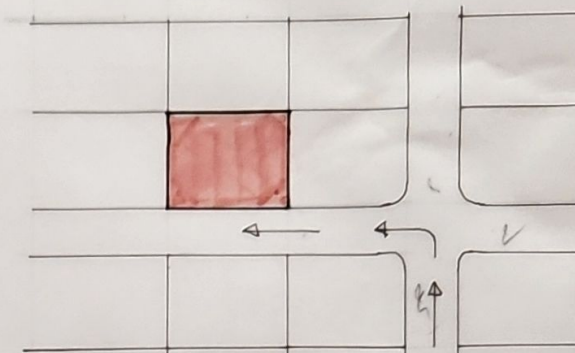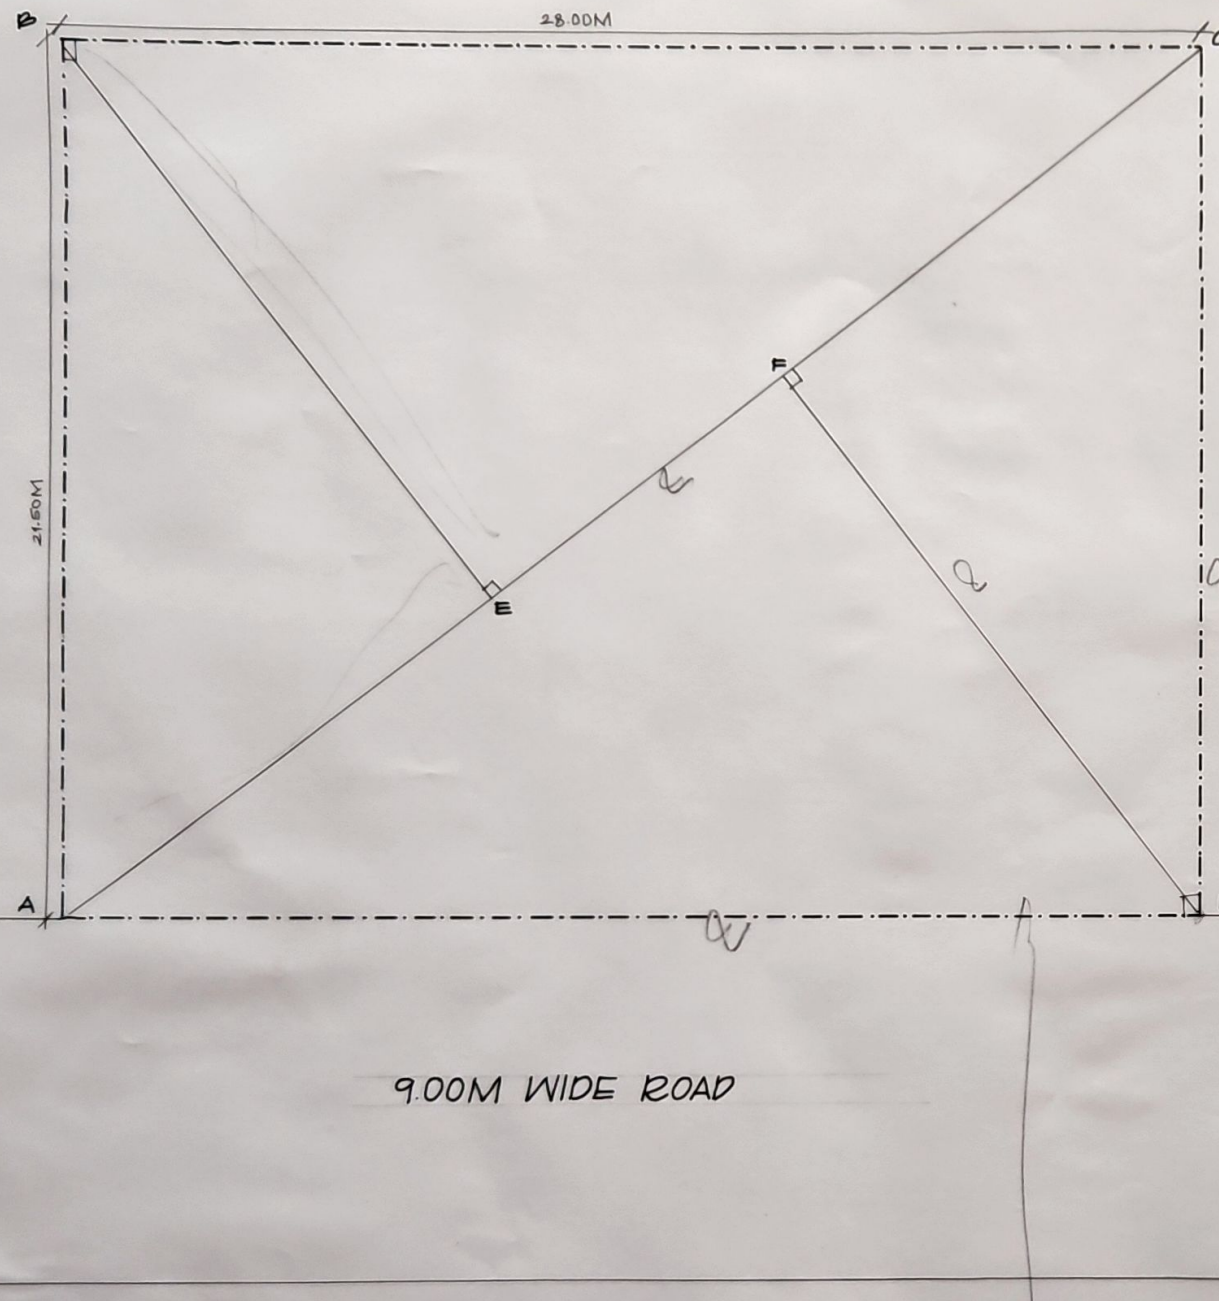


PLOTTING

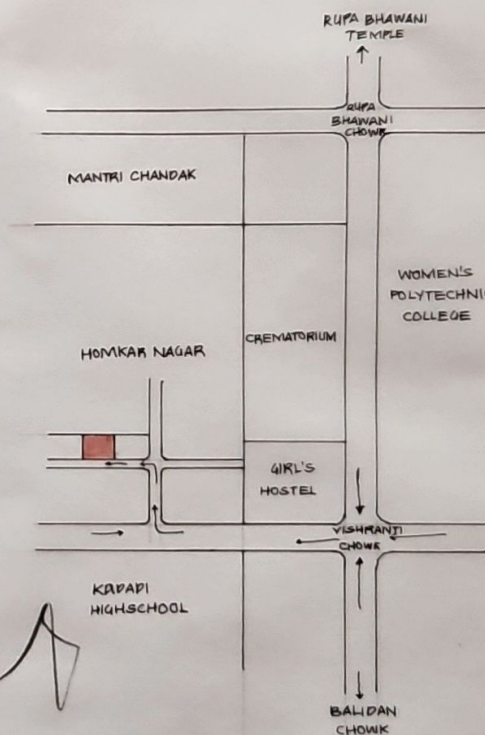

LOCATION

WORKING DRAWING FOR MR RAUT,

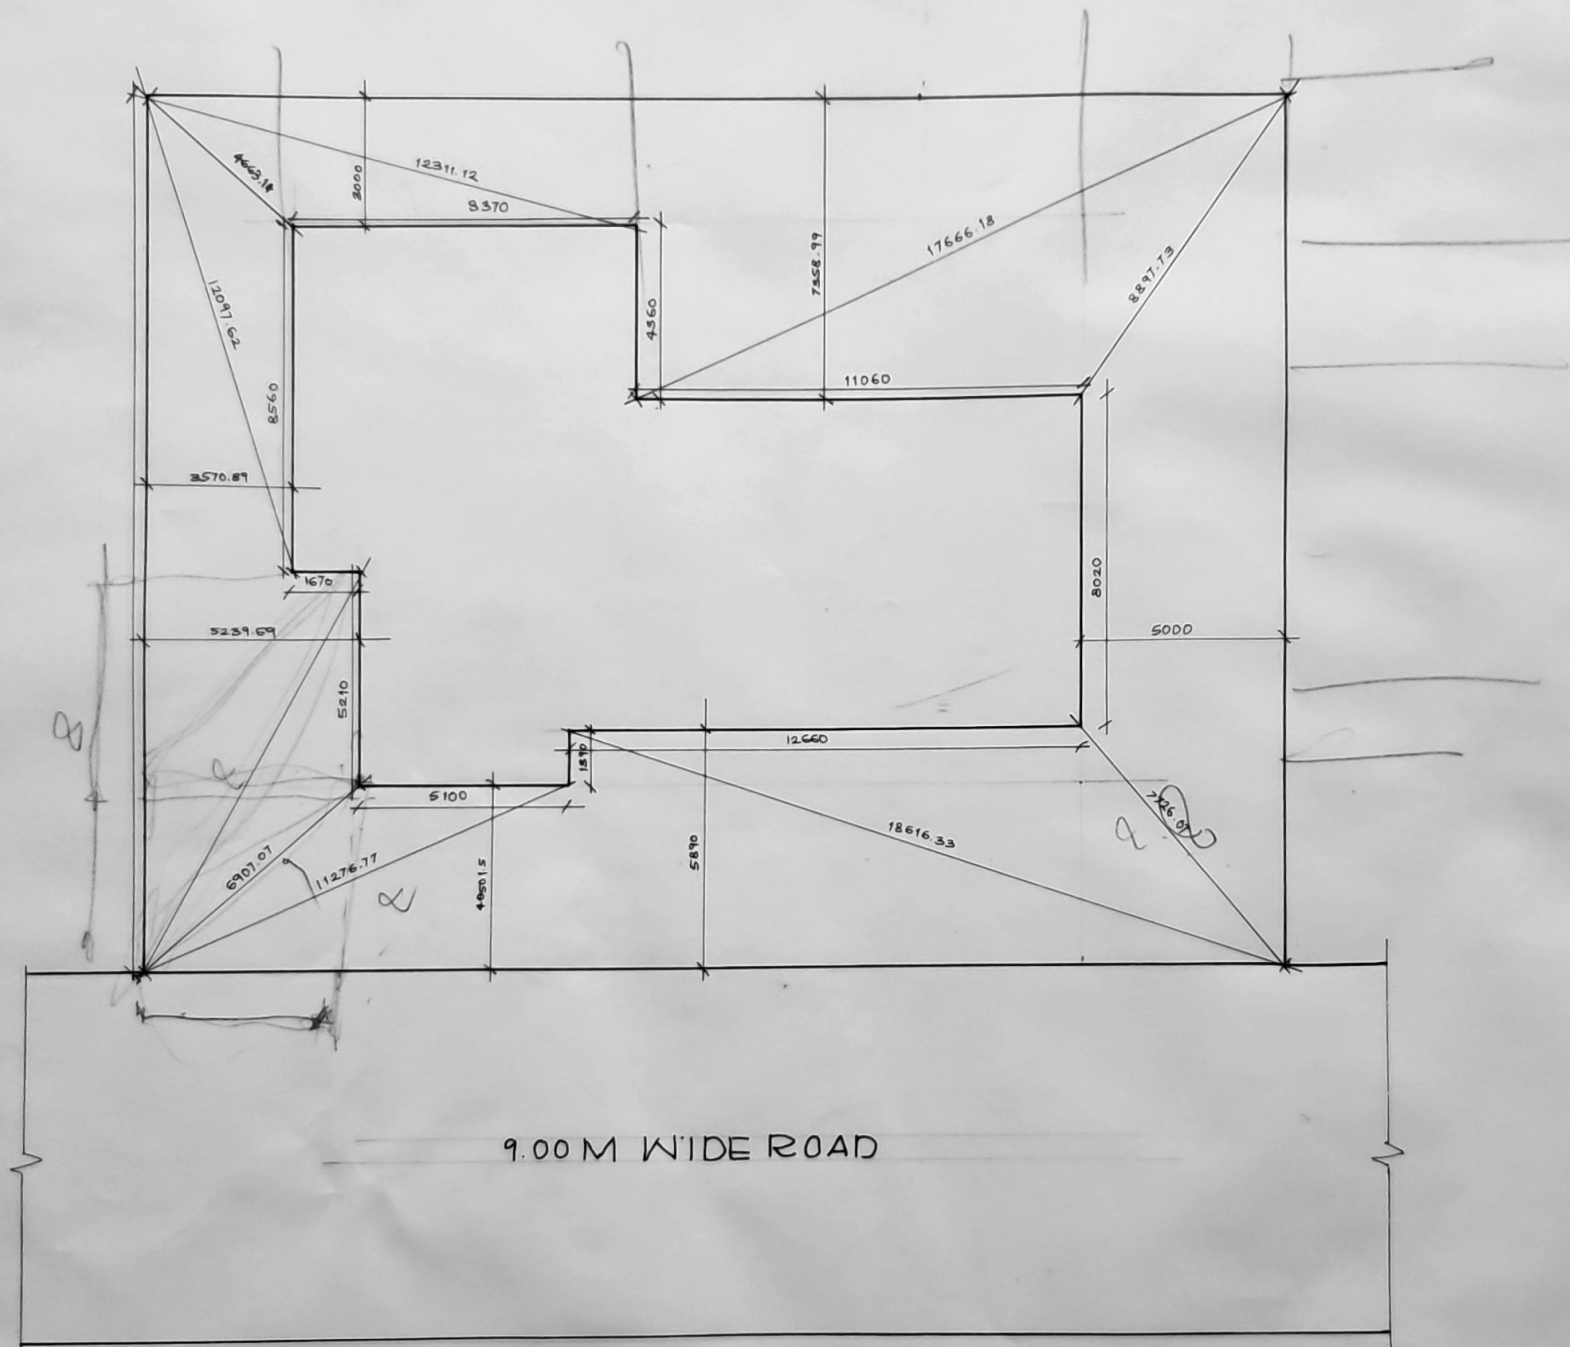

BLOCK PLAN

SCALE - 1:100

SECTION

WORKING DRAWING - 1 SHEET NO.

- NOTE -
1. ALL DIMENSIONS ARE IN MM UNIT UNTIL SPECIFIED.
 2. DO NOT MEASURE DRAWING, FOLLOW WRITTEN DIMENSIONS ONLY.
 3. PLEASE REFER TO THE ARCHITECT IN CONCERN TO ANY QUERY OF DRAWING.
 4. THE DRAWING IS A PROPERTY OF THE ARCHITECT AND SHALL NOT BE USED OR REPRODUCED WITHOUT THEIR WRITTEN CONCENT.

SCALE	DATE	DRAWN BY	CHECKED BY	REV NO.
		VK		

SUBJECT -

PROPOSED
RESIDENCE AT
HOMKAR NAGAR,
SOLAPUR.




ARCHITECT -

NAME - VAISHNAVI GUNVANT KARBHARI.
BATCH - 3RD YEAR [SEM - VI]
COLLEGE NAME - SSSM'S COLLEGE
OF ARCHITECTURE, SOLAPUR.
ROLL NO. - SSM/21/08

WORKING DRAWING FOR MR RAUT



Ajagde
7-5-22

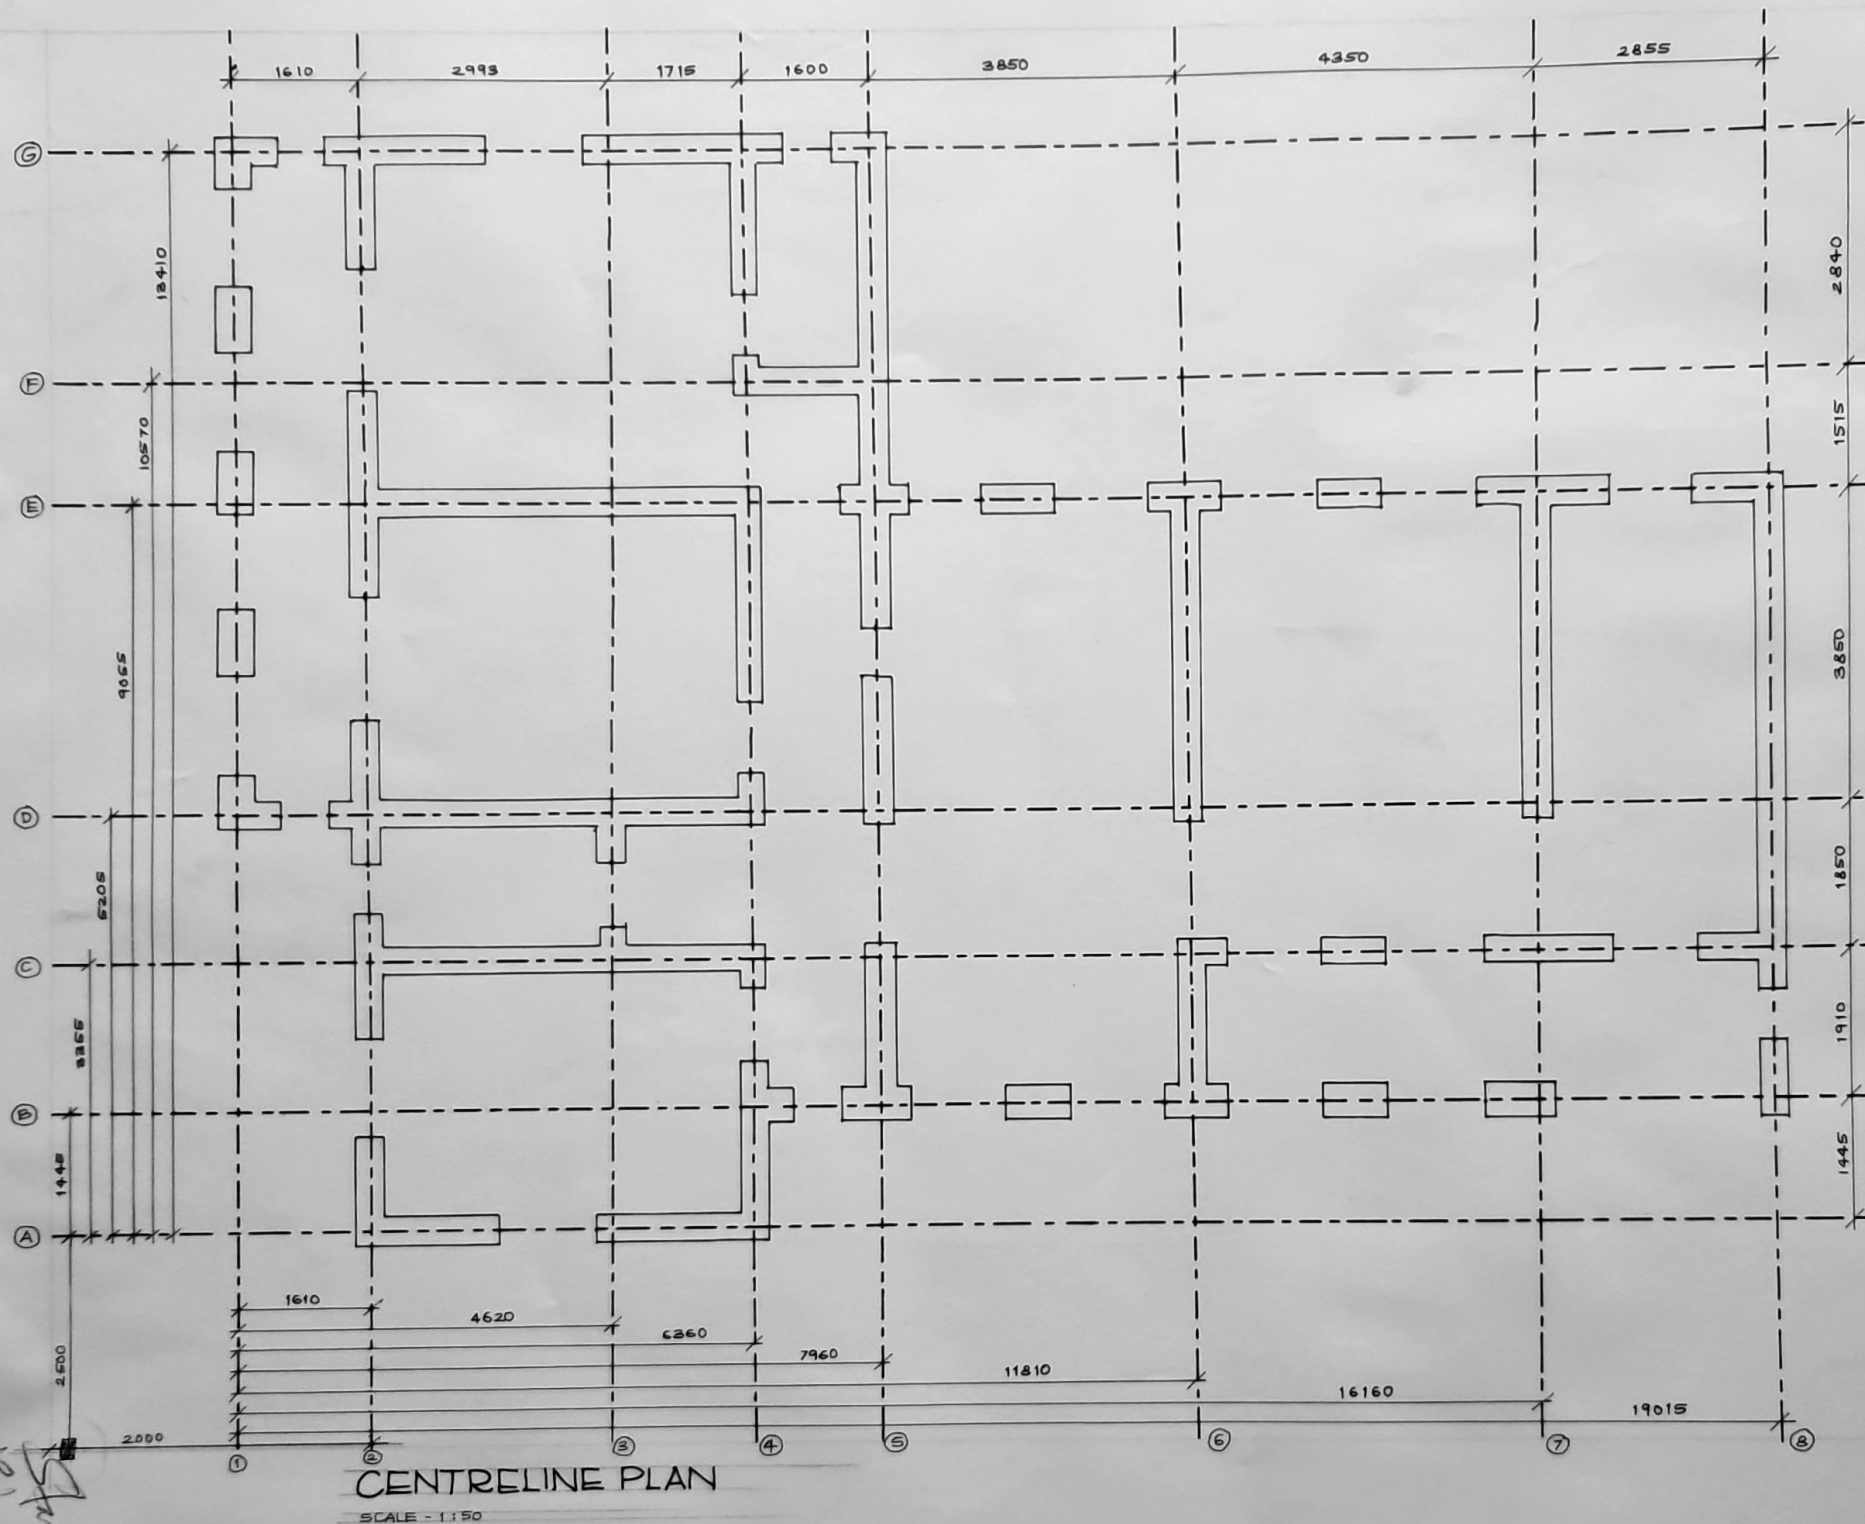


CENTRELINE PLAN

SCALE - 1:50

CENTRELINE PLAN

WORKING DRAWING - I

SHEET NO.

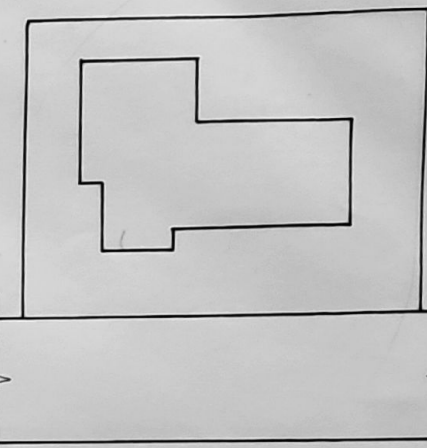

KEY PLAN

SCALE - 1:200

NOTE-

1. ALL DIMENSIONS ARE IN MM UNIT UNTIL SPECIFIED.
2. DO NOT MEASURE DRAWING, FOLLOW WRITTEN DIMENSIONS ONLY.
3. PLEASE REFER TO THE ARCHITECT IN CONCERN TO ANY QUERY OF DRAWING.
4. THE DRAWING IS A PROPERTY OF AN ARCHITECT AND SHALL NOT BE USED OR REPRODUCED WITHOUT THEIR WRITTEN CONCENT.

SCALE	DATE	DRAWN BY	CHECKED BY	REV NO.
1:50		VK		

SUBJECT-


PROPOSED
RESIDENCE AT
HOMKAR NAGAR
SOLAPUR.




ARCHITECT-

NAME-VAISHNAVI GUNVANT KARBHARI.
BATCH - 3RD YEAR [SEM VI]
COLLEGE NAME - GSSM'S COLLEGE
OF ARCHITECTURE, SOLAPUR.
ROLL NO. - SSM1/21/08.

WORKING DRAWING FOR MR. RAUT

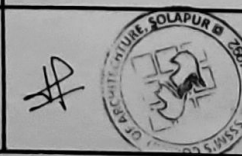

7-6-23

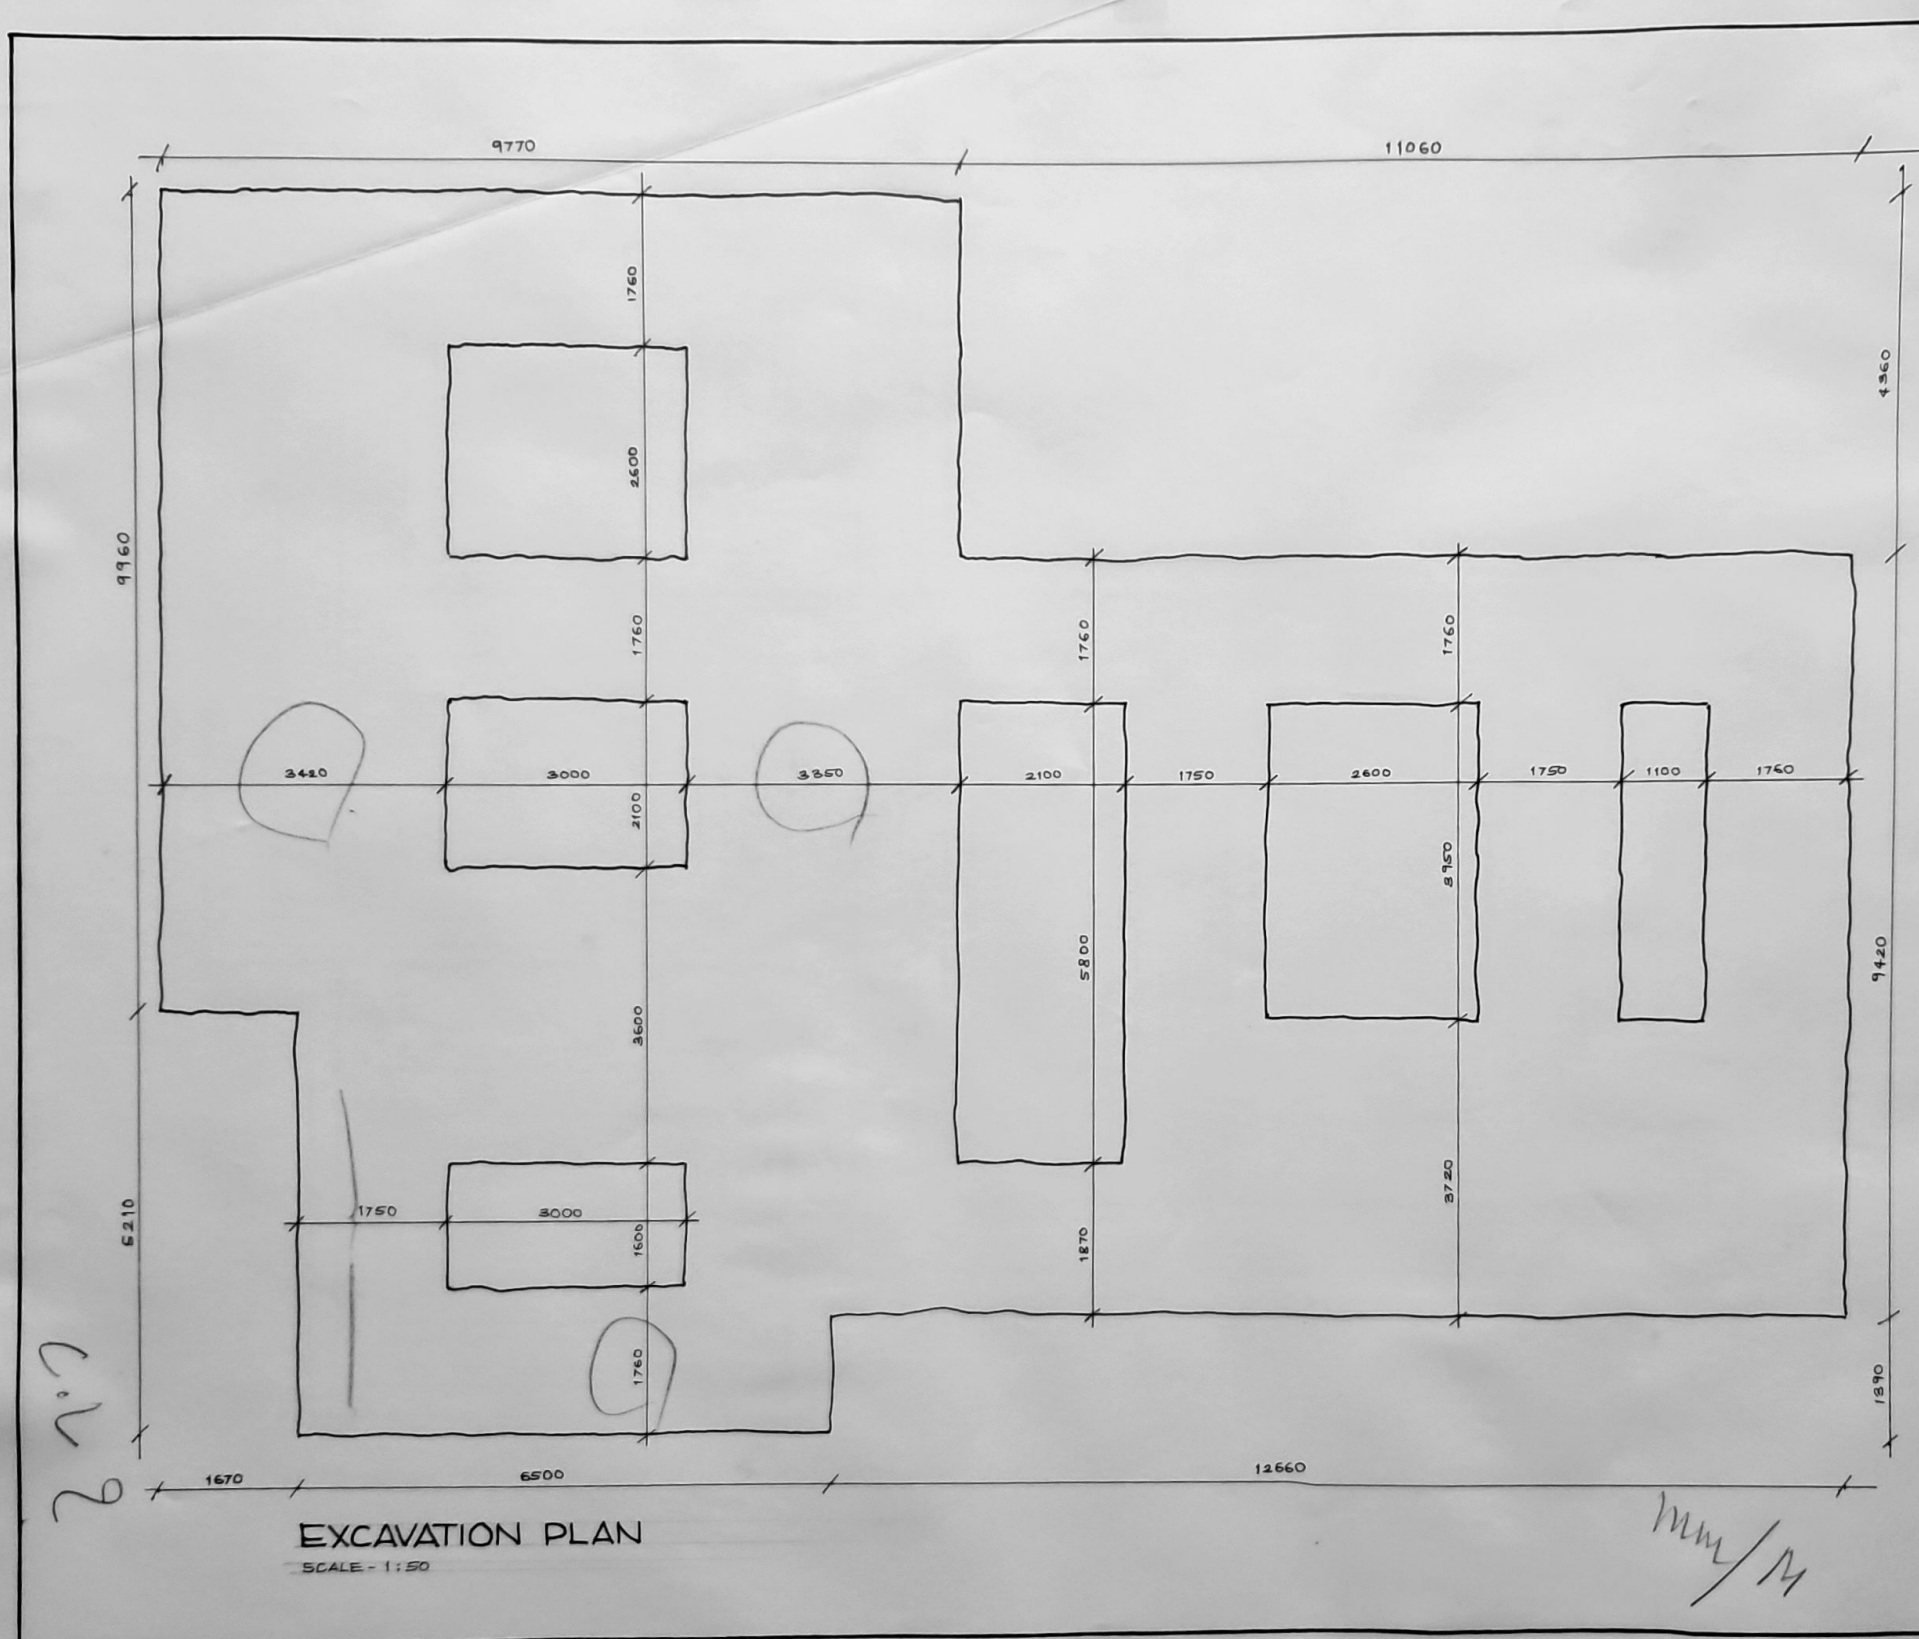


EXCAVATION PLAN
SCALE - 1:50

EXCAVATION PLAN

WORKING DRAWING-1

SHEET NO.

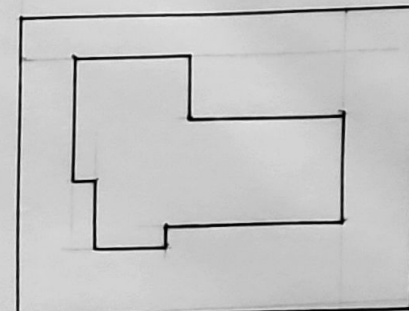

KEY PLAN
SCALE - 1:500

NOTE-

1. ALL DIMENSIONS ARE IN MM UNIT UNTIL SPECIFIED.
2. DO NOT MEASURE DRAWING, FOLLOW WRITTEN DIMENSIONS ONLY.
3. PLEASE REFER TO ARCHITECT IN CONCERN TO ANY QUERY OF DRAWING.
4. THE DRAWING IS A PROPERTY OF AN ARCHITECT AND SHALL NOT BE USED OR REPRODUCED WITHOUT THEIR WRITTEN CONCENT.

SCALE	DATE	DRAWN BY	CHECKED BY	REVNO.
1:50		VK		

SUBJECT-


PROPOSED
RESIDENCE FOR
AT HOMIKAR NAGAR
SOLAPUR.




ARCHITECT-

NAME-VAISHNAVI GUNVANT KARBHARI.
BATCH- 3RD YEAR [SEM-VI]
COLLEGE NAME - SSSM'S COLLEGE
OF ARCHITECTURE, SOLAPUR.
ROLL NO.- SSM/21/08.

WORKING DRAWING FOR MR. RAUT

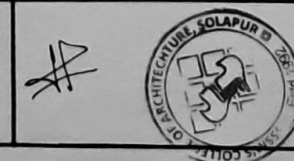

Signature
7.6.24

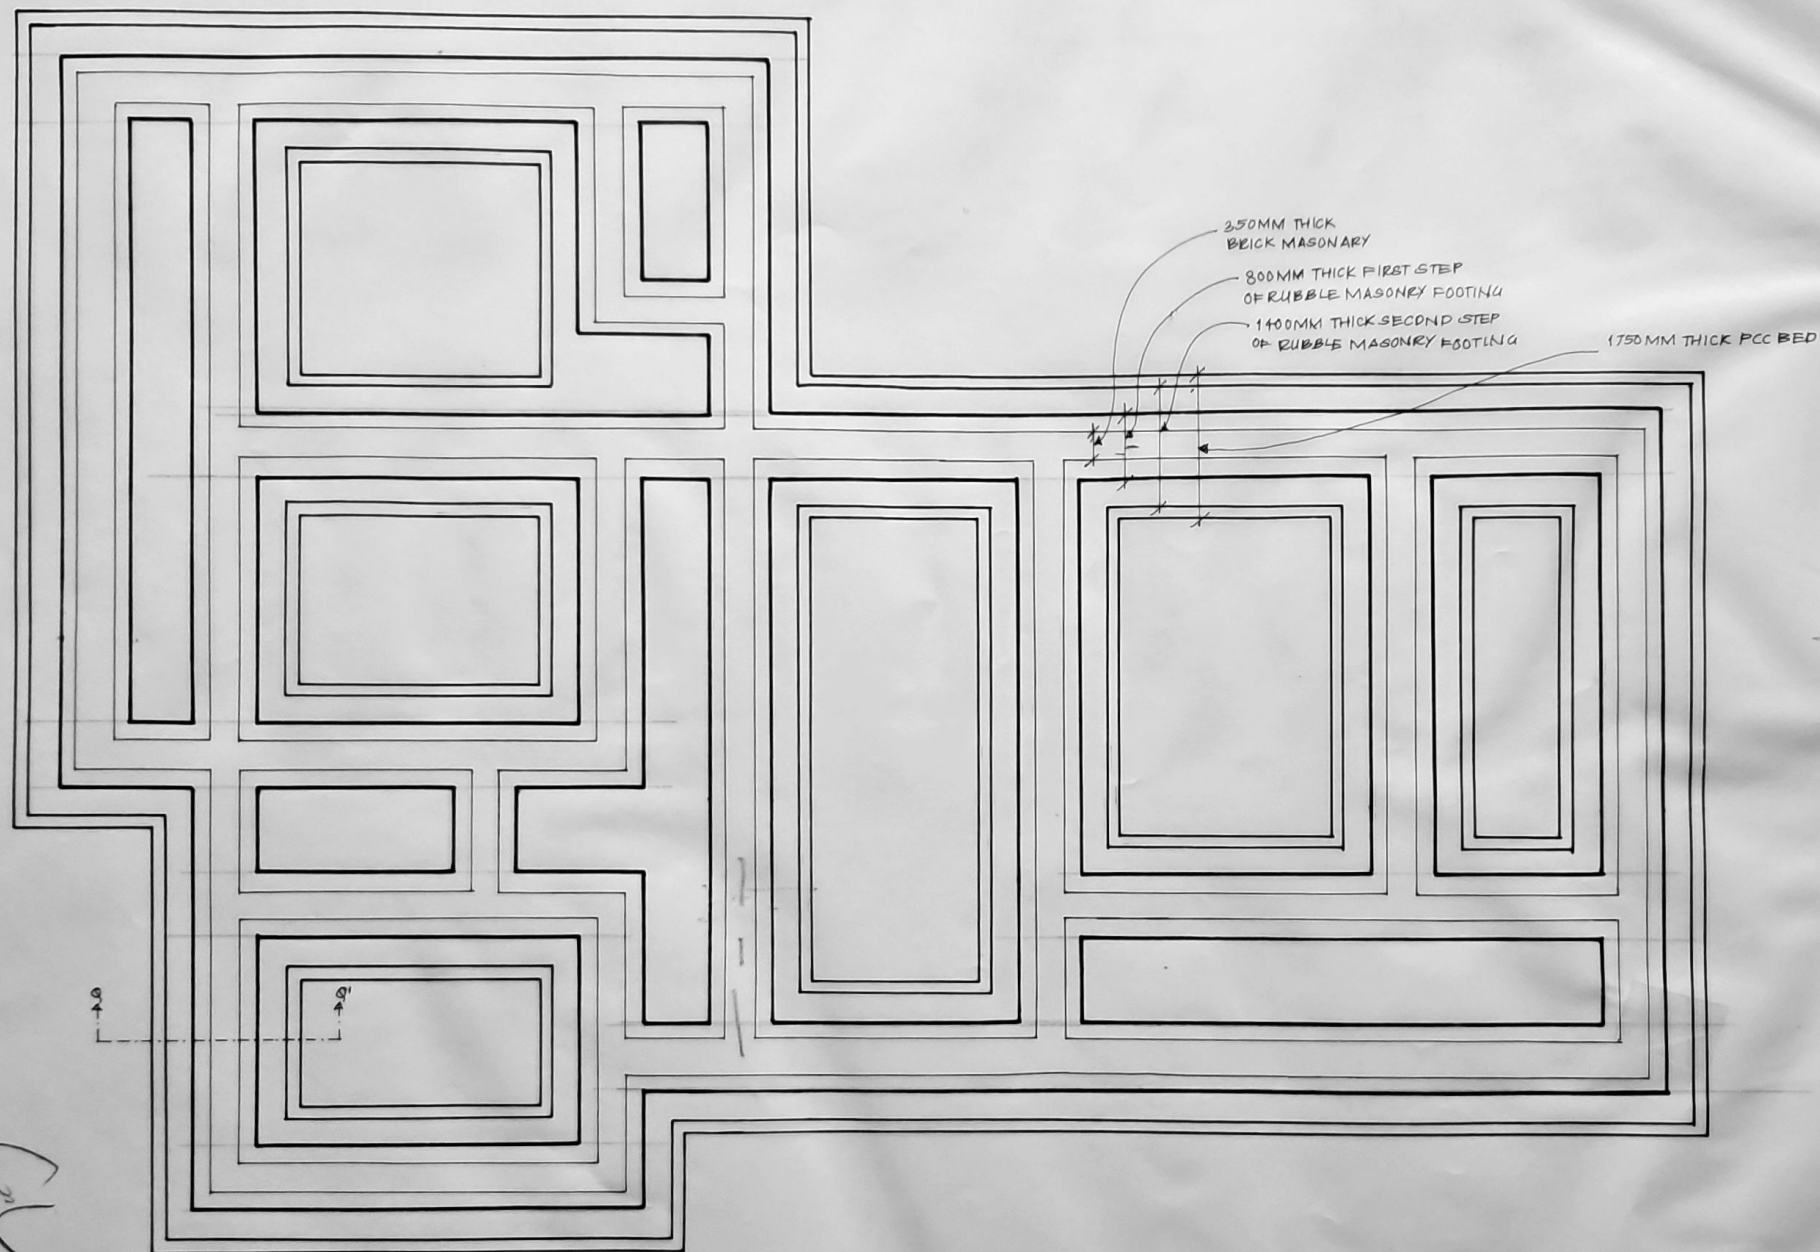


FOUNDATION PLAN
SCALE - 1:50

FOUNDATION PLAN

WORKING DRAWING - 1

SHEET NO.

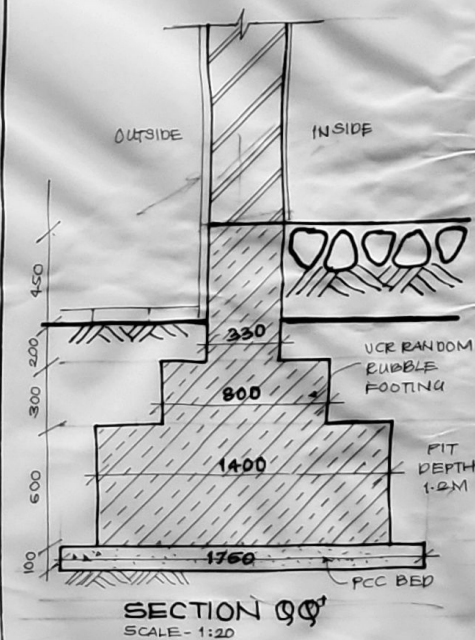

- NOTE -
1. ALL DIMENSIONS ARE IN MM UNLESS SPECIFIED.
 2. DO NOT MEASURE DRAWING, FOLLOW WRITTEN DIMENSIONS ONLY.
 3. PLEASE REFER TO THE ARCHITECT IN CONCERN TO ANY QUERY OF DRAWING.
 4. THE DRAWING IS A PROPERTY OF THE ARCHITECT AND SHALL NOT BE USED OR REPRODUCED WITHOUT THEIR WRITTEN CONCENT

SCALE	DATE	DRAWN BY	CHECKED BY	REV NO.
1:50		VK		

SUBJECT -

PROPOSED
RESIDENCE AT
HOMKAR NAGAR
SOLAPUR.



ARCHITECT -

NAME - VAISHNAVI GUNVANT KARBHARI.
BATCH - 3RD YEAR [SEM - VI]
COLLEGE NAME - SSSM'S COLLEGE OF
ARCHITECTURE, SOLAPUR.
ROLL NO. - SSM/21/08

WORKING DRAWING FOR MR RAUT



TERRACE PLAN

WORKING DRAWING - 1 SHEET NO.

SLOPE CALCULATION
RATIO - 1:150

$$A) \frac{150}{120} = 0.125$$

$$B) \frac{150}{89} = 0.125$$

$$C) \frac{150}{110} = 0.125$$

NOTE -

1. ALL DIMENSIONS ARE IN MM UNIT UNTIL SPECIFIED.
2. DO NOT MEASURE DRAWING, FOLLOW WRITTEN DIMENSIONS ONLY.
3. PLEASE REFER TO THE ARCHITECT IN CONCERN TO ANY QUERY OF DRAWING.
4. THE DRAWING IS THE PROPERTY OF THE ARCHITECT AND SHALL NOT BE USED OR REPRODUCED WITHOUT THEIR WRITTEN CONCENT

SCALE	DATE	DRAWN BY	CHECKED BY	REV NO.
		VK		

SUBJECT -

**PROPOSED
RESIDENCE AT
HOMKAG NAGAR,
SOLAPUR.**


ARCHITECT -

NAME - VAISHNAVI GUNVANT KAPBHARI.
BATCH - 3RD YEAR [SEM - VI]
COLLEGE NAME - SSSM'S COLLEGE
OF ARCHITECTURE, SOLAPUR.
ROLL NO. - SSM/21/08.

Handwritten signature/initials.




Handwritten signature/initials.

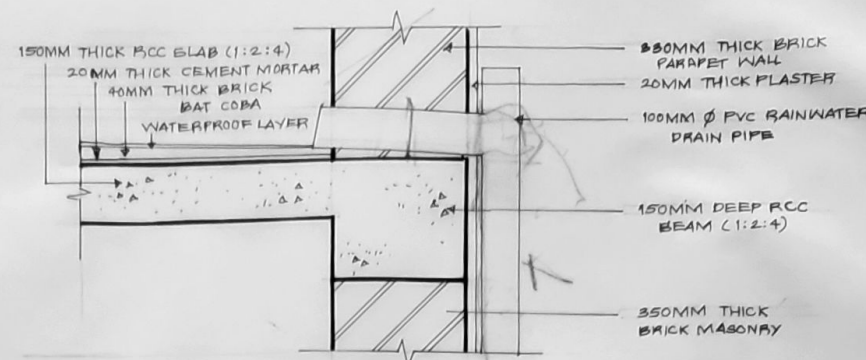

RAIN-WATER DRAIN-PIPE AND COBA DETAIL

SCALE - 1:10

DRAINOUT ②

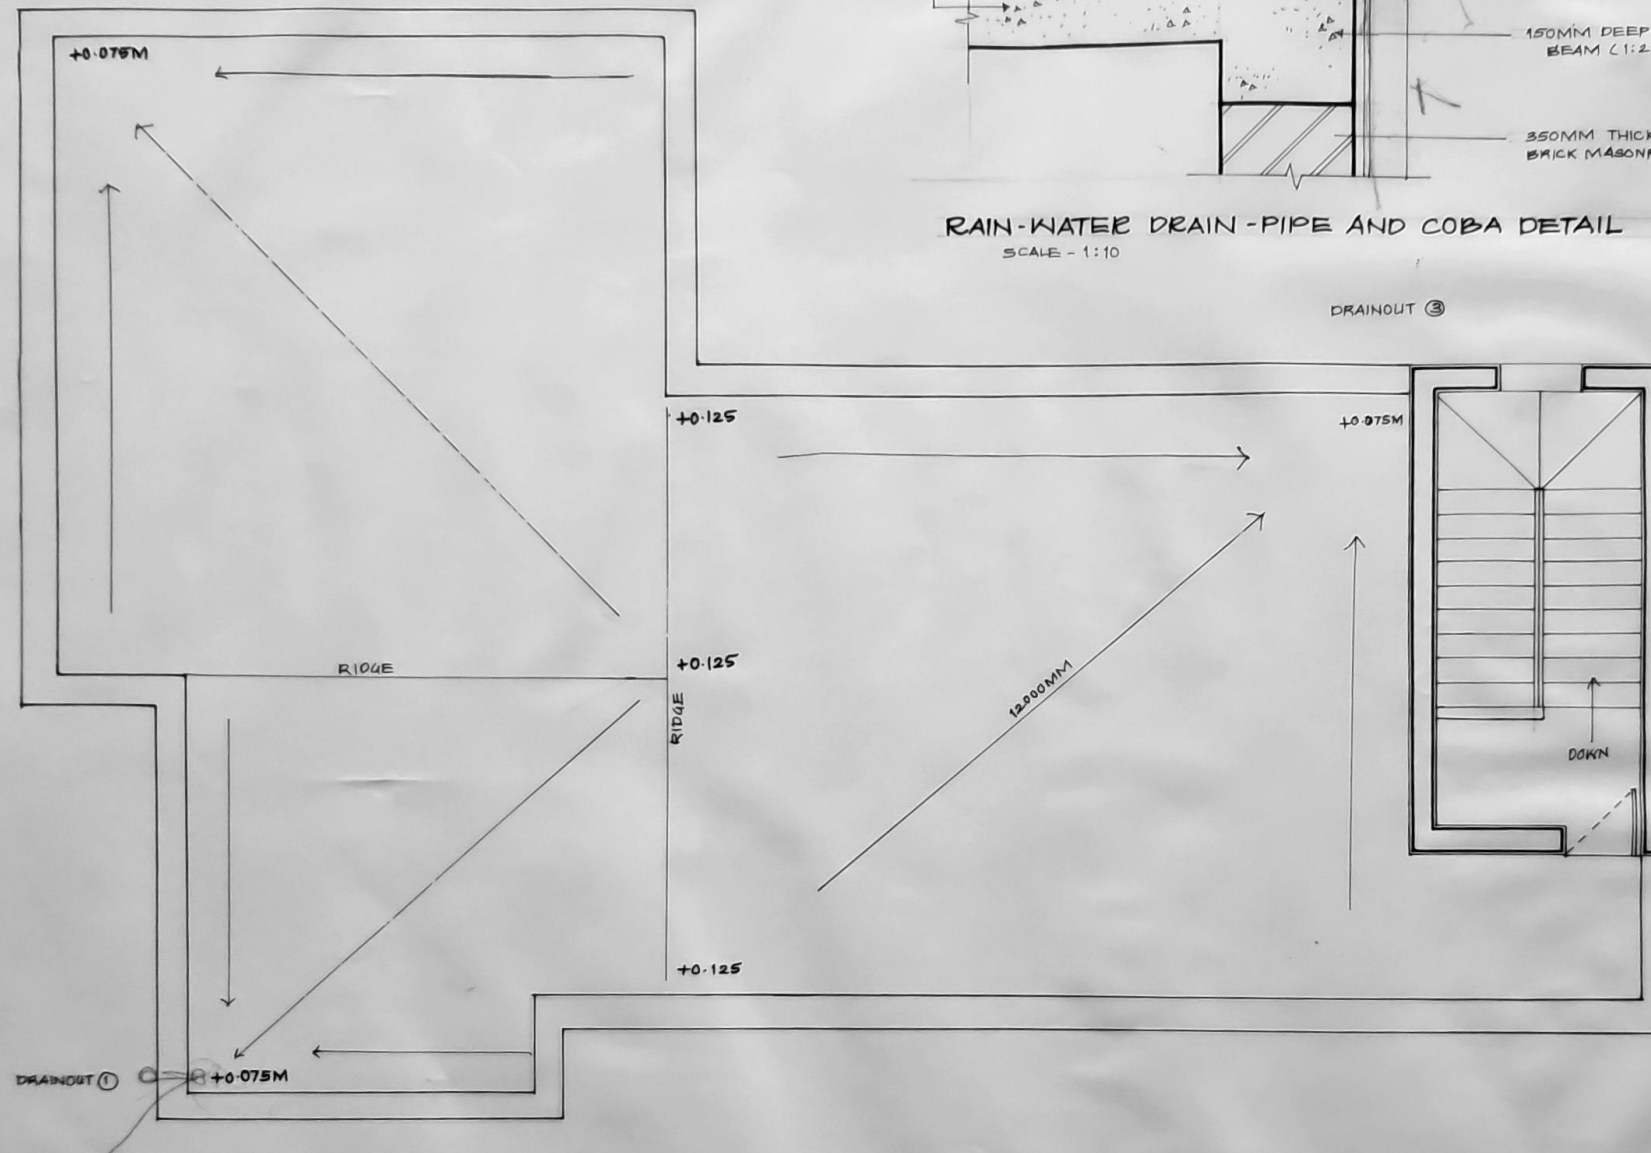

TERRACE PLAN

SCALE - 1:50

WORKING DRAWING FOR MR. RAUT

FLOOR PLAN

WORKING DRAWING - I

SHEET NO.

D₁ - 900 X 2400 - FLUSH DOOR WITH VINEER
 D₂ - 1200 X 2400 - WOODEN DOOR
 D₃ - 1500 X 2400 - WOODEN DOOR
 D₄ - 750 X 2400 - FLUSH DOOR WITH VINEER
 W₁ - 1200 X 1800 - UPVC
 W₂ - 1200 X 1200 - UPVC
 W₃ - 1500 X 1800 - UPVC
 W₄ - 1000 X 1500 - UPVC
 W₅ - 800 X 1800 - UPVC
 V₁ - 600 X 600 - UPVC
 OP₁ - 1200 X 2400 - PLASTERED FRAME
 OP₂ - 600 X 1800 - PLASTERED FRAME
 OP₃ - 1500 X 2400 - ARTIFICIAL QUARTZ STONE
 OP₄ - 2200 X 2400 - PLASTERED FRAME
 OP₅ - 600 X 800 - ARTIFICIAL QUARTZ STONE
 INTERNAL PAINT - LUSTRE
 EXTERNAL PAINT - APEX

NOTE -

1. ALL DIMENSIONS ARE IN MM UNIT UNTIL SPECIFIED
2. DO NOT MEASURE DRAWING, FOLLOW WRITTEN DIMENSIONS ONLY
3. PLEASE REFER TO THE ARCHITECT IN CONCERN TO ANY QUERY OF DRAWING.
4. THE DRAWING IS A PROPERTY OF THE ARCHITECT AND SHALL NOT BE USED OR REPRODUCED WITHOUT THEIR WRITTEN CONCENT

SCALE	DATE	DRAWN BY	CHECKED BY	KEY NO.
1:50		YK		

SUBJECT - *

PROPOSED
 RESIDENCE AT
 HOMKAR NAGAR
 SOLAPUR.




ARCHITECT -

NAME - VAISHNAVI GUNVANT KARBHARI.
 BATCH - 3RD YEAR [SEM - VI].
 COLLEGE NAME - SSSM'S COLLEGE OF ARCHITECTURE, SOLAPUR.
 ROLL NO. - SSSM/21/08

AP




WORKING DRAWING FOR MR. RAUT

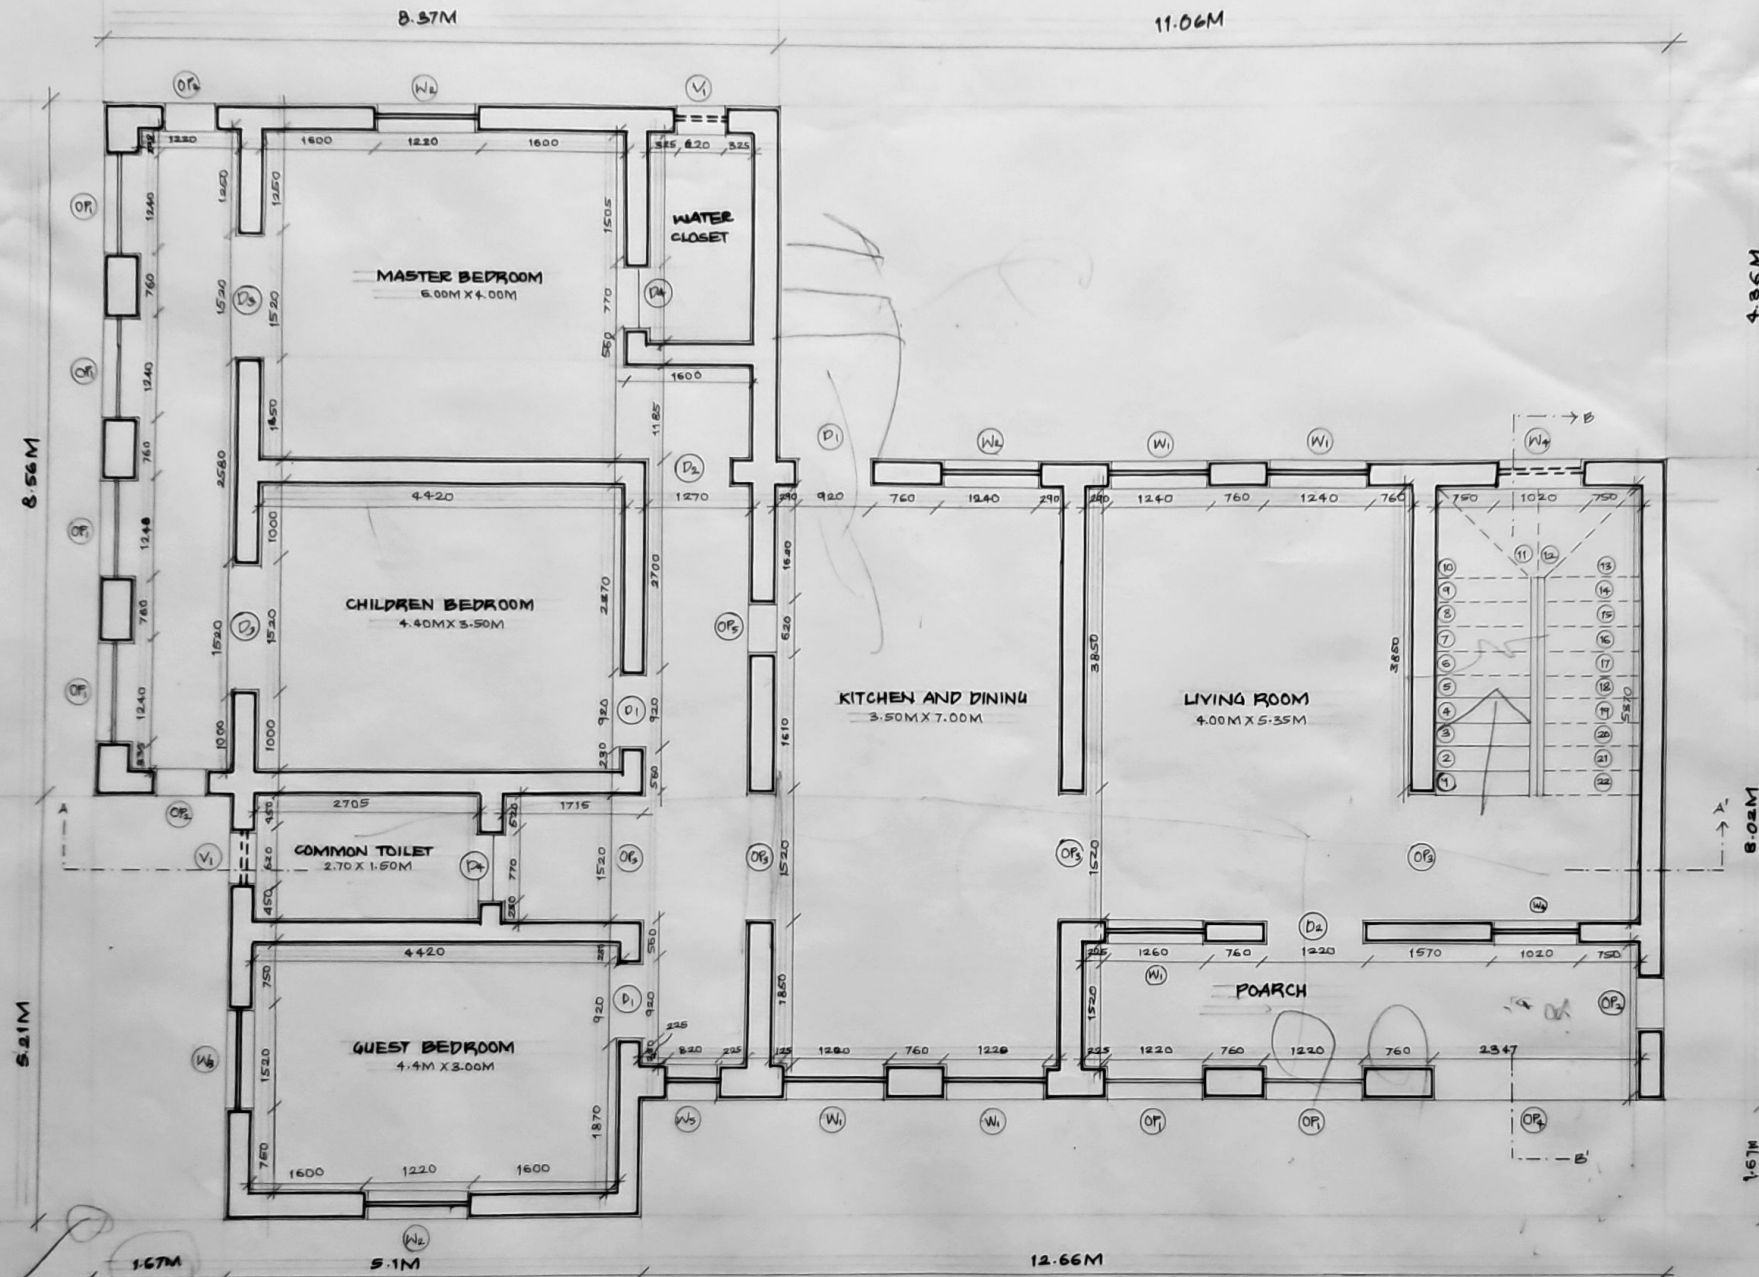


GROUND FLOOR PLAN.

SCALE - 1:50

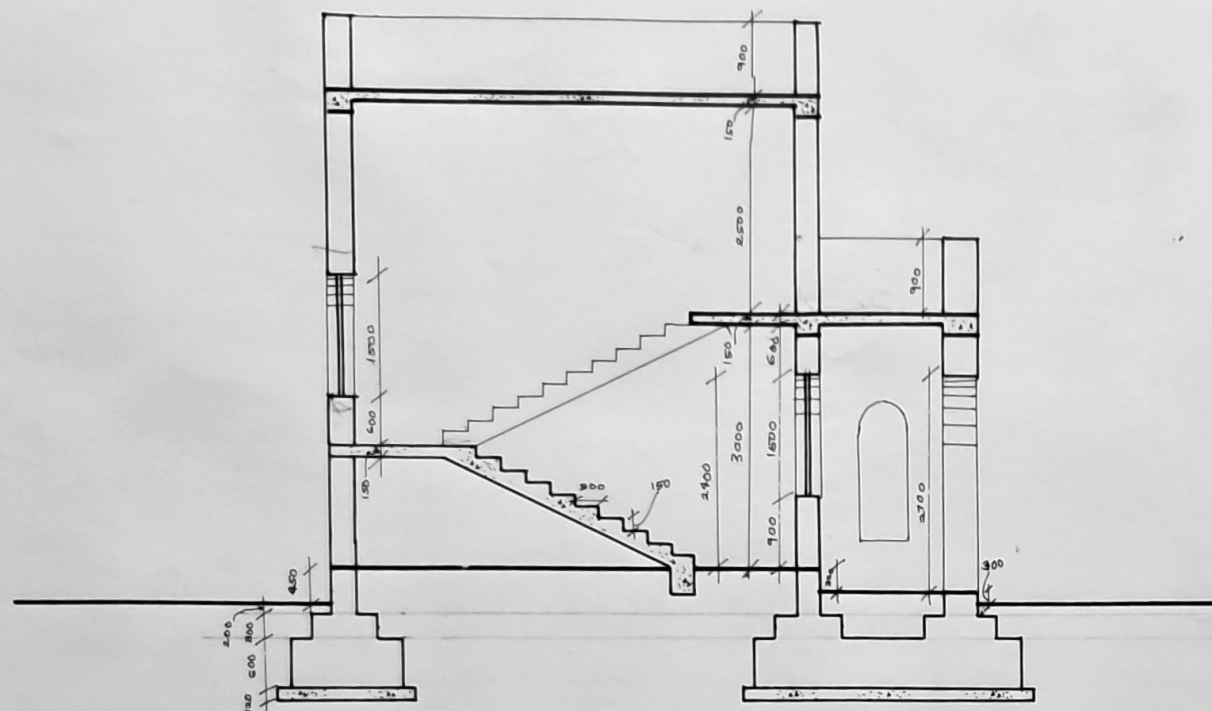

SECTION BB'

SCALE - 1:50

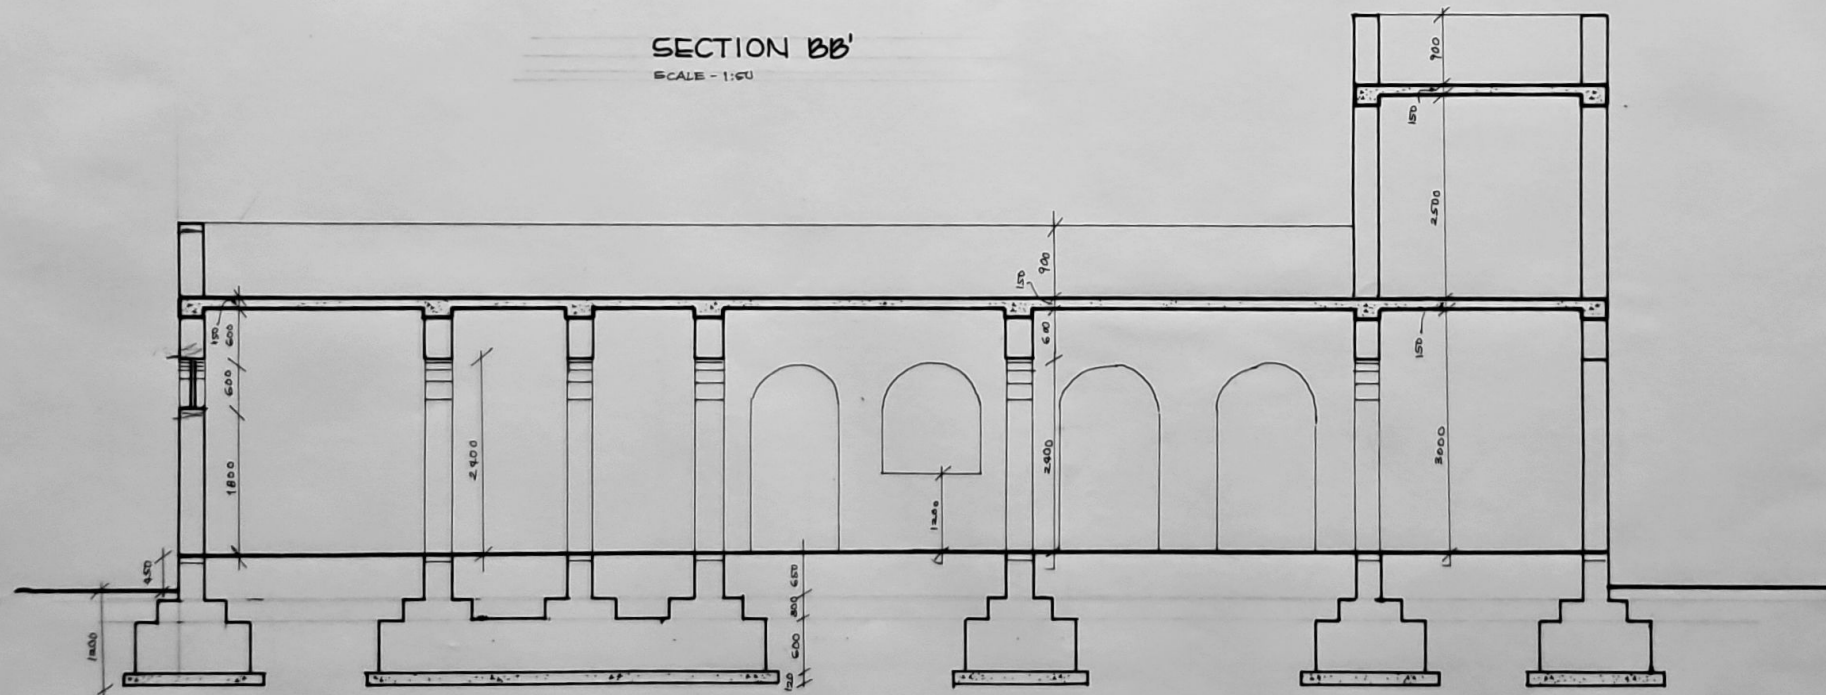

SECTION AA'

SCALE - 1:50

SECTION

WORKING DRAWING - I SHEET NO.

- NOTE -
1. ALL DIMENSIONS ARE IN MM UNIT UNTIL SPECIFIED
 2. DO NOT MEASURE DRAWING, FOLLOW WRITTEN DIMENSIONS ONLY.
 3. PLEASE REFER TO THE ARCHITECT IN CONCERN TO ANY QUERY OF DRAWING.
 4. THE DRAWING IS A PROPERTY OF AN ARCHITECT AND SHALL NOT BE USED OR REPRODUCED WITHOUT THEIR WRITTEN CONCENT.

SCALE	DATE	DRAWN BY	CHECKED BY	REVNO.
1:50		VK		

SUBJECT -


PROPOSED
RESIDENCE AT
HOMKAR NAGAR,
SOLAPUR.

ARCHITECT -

NAME-VAISHNAVI GUNYANT KARBHARI.
BATCH-3RD YEAR [SEM-VI]
COLLEGE NAME-SSSM'S COLLEGE
OF ARCHITECTURE, SOLAPUR.
ROLL NO.- SSM/21/08.


WORKING DRAWING FOR MR RAUT



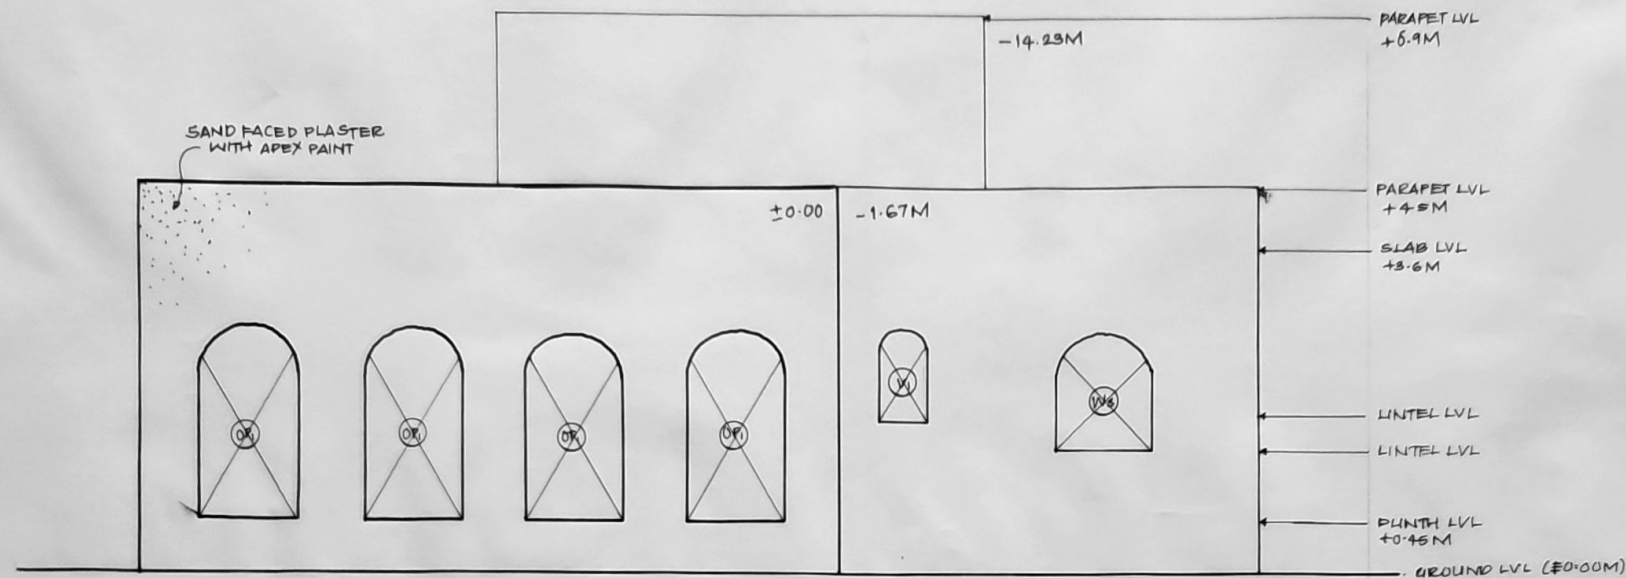

WEST-SIDE ELEVATION

SCALE - 1:50

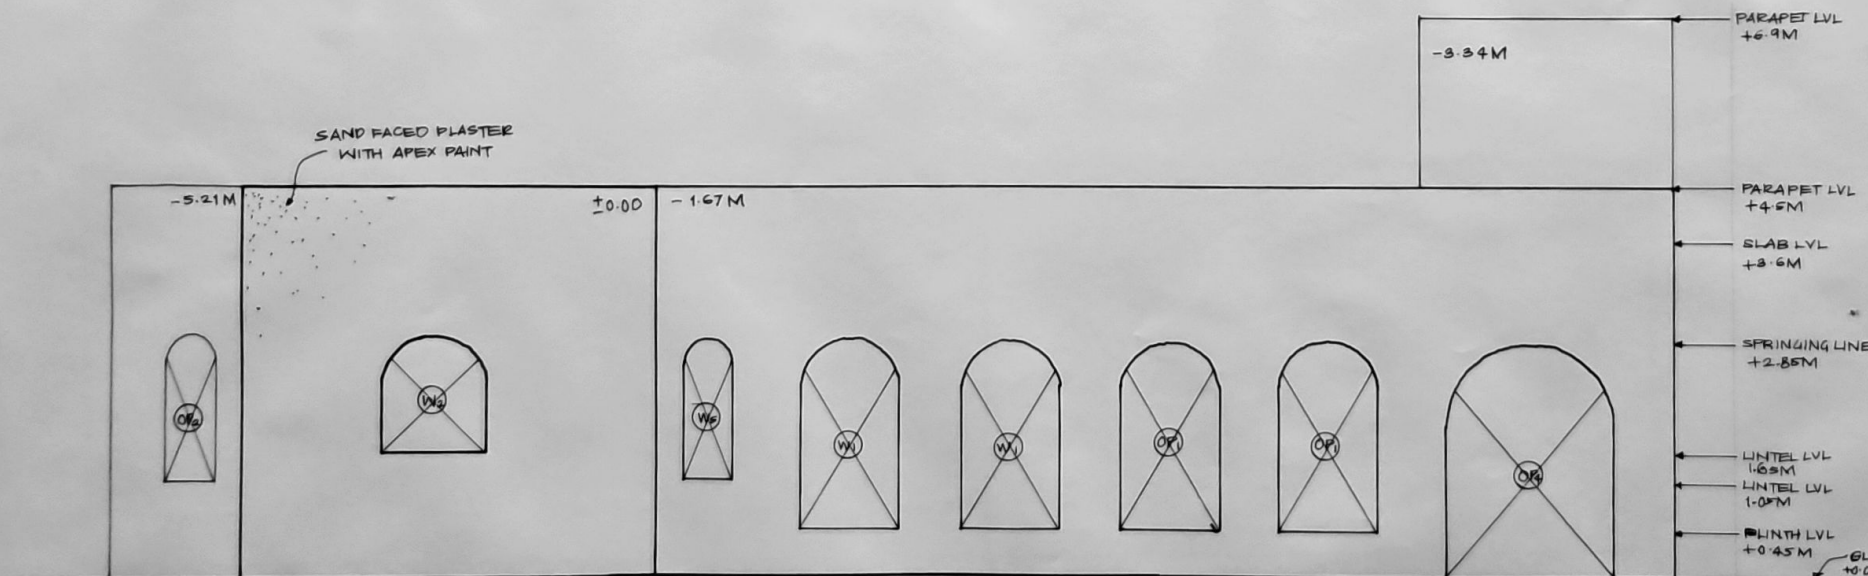


SOUTH-SIDE ELEVATION

SCALE - 1:50

ELEVATION

WORKING DRAWING - I

SHEET NO.

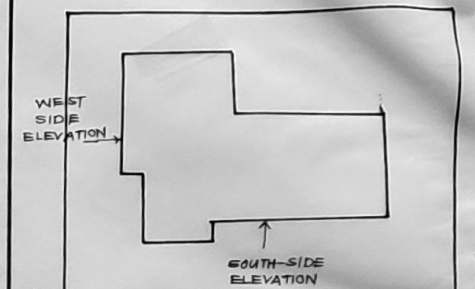

KEY PLAN

SCALE - 1:200

NOTE -

1. ALL DIMENSIONS ARE IN MM UNTIL SPECIFIED.
2. DO NOT MEASURE DRAWING, FOLLOW WRITTEN DIMENSIONS ONLY.
3. PLEASE REFER TO THE ARCHITECT IN CONCERN OF ANY QUERY.
4. THE DRAWING IS THE PROPERTY OF THE ARCHITECT AND SHALL NOT BE USED OR REPRODUCED WITHOUT THEIR WRITTEN CONCENT.

SCALE	DATE	DRAWN BY	CHECKED BY	REV NO.
1:50		VK		

SUBJECT-

**PROPOSED
RESIDENCE AT
HOMKAR NAGAR
SOLAPUR.**

ARCHITECT -


NAME-VAISHNAVI GUNVANT KARBHARI.
BATCH - 3RD YEAR [SEM-VI]
COLLEGE NAME - SSSM'S COLLEGE
OF ARCHITECTURE, SOLAPUR.
ROLL NO - SSM/21/08.

WORKING DRAWING FOR MR RAUT




ELEVATION

WORKING DRAWING-1 SHEET NO.

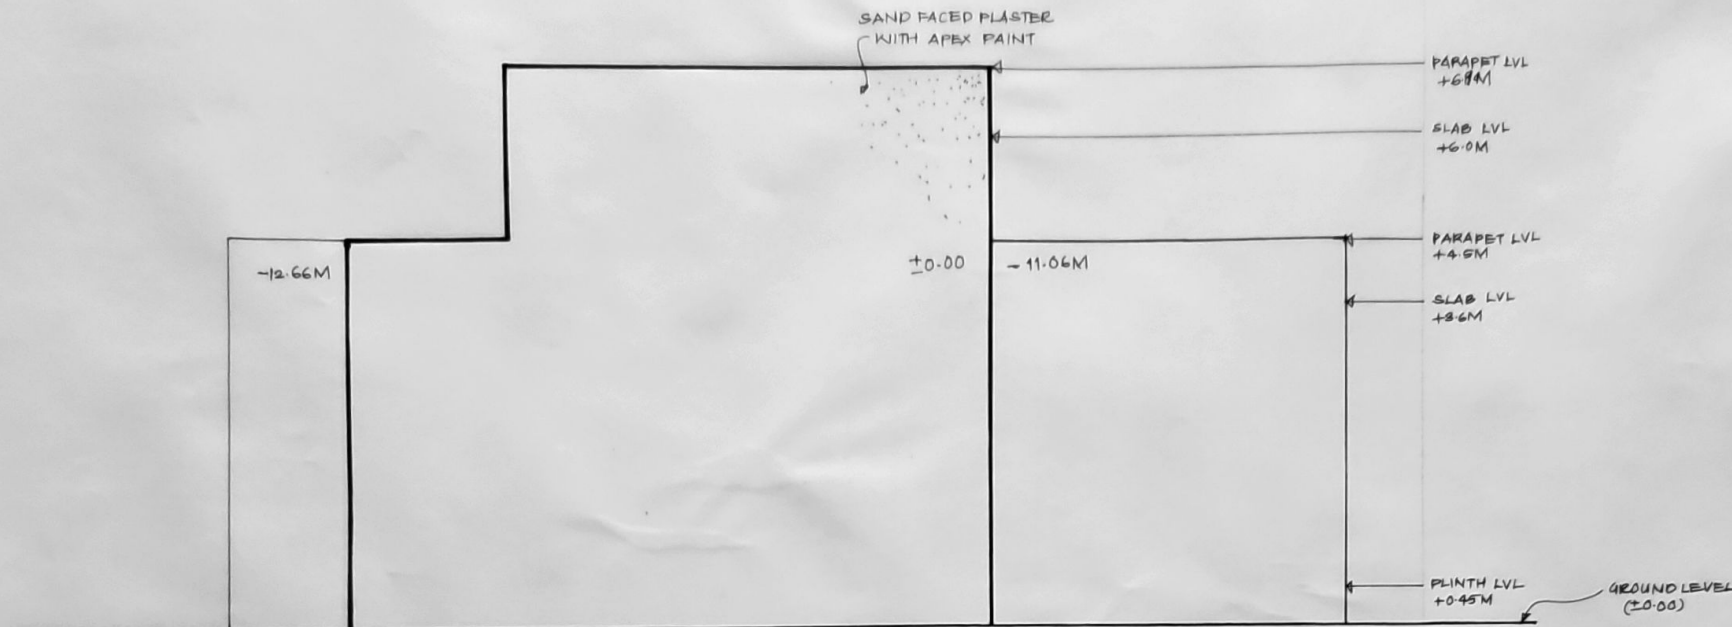

EAST-SIDE ELEVATION

SCALE - 1:50

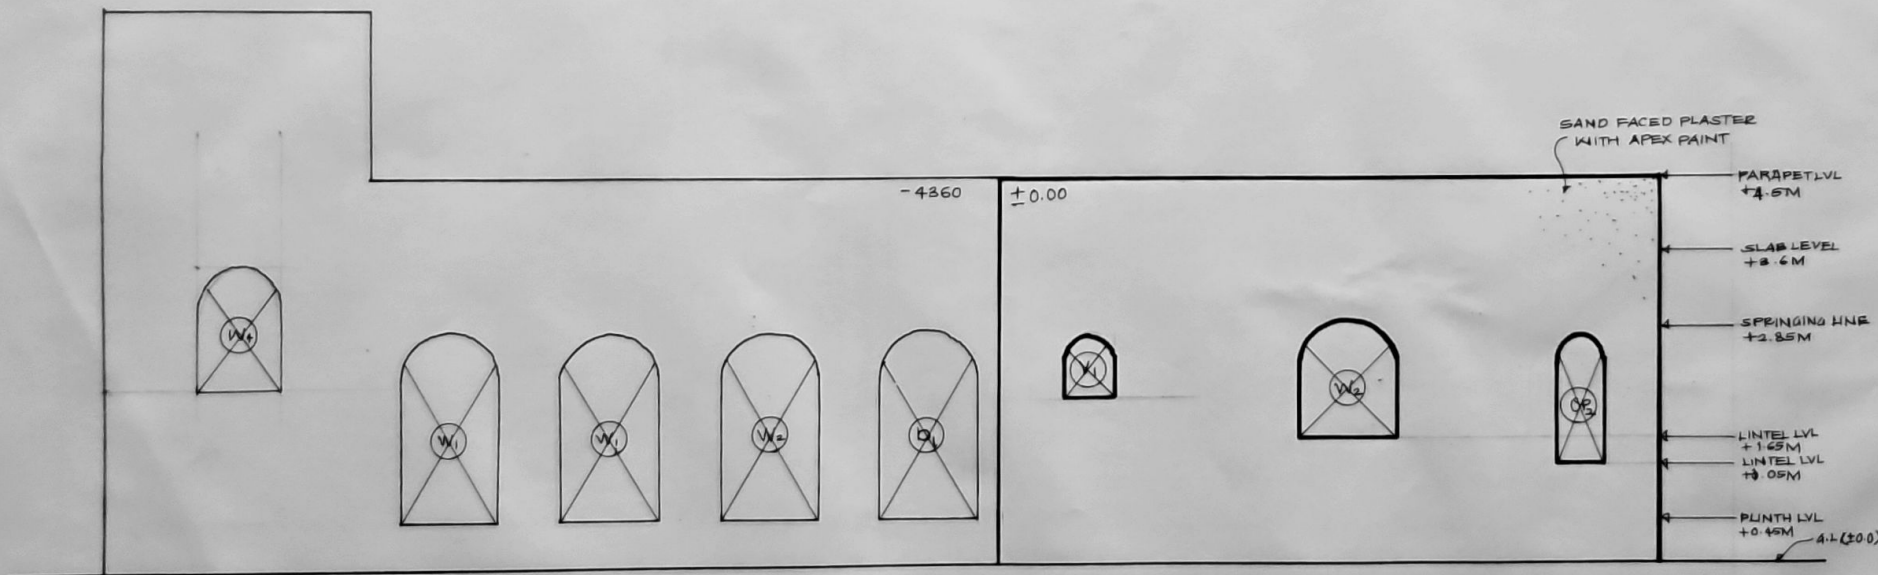

NORTH-SIDE ELEVATION

SCALE - 1:50

NOTE-

1. ALL DIMENSIONS ARE IN MM UNIT UNTIL SPECIFIED.
2. DO NOT MEASURE DRAWING, FOLLOW WRITTEN DIMENSIONS ONLY.
3. PLEASE REFER TO THE ARCHITECT IN CONCERN TO ANY QUERY.
4. THE DRAWING IS THE PROPERTY OF THE ARCHITECT AND SHALL NOT BE USED OR REPRODUCED WITHOUT THEIR WRITTEN CONCENT.

SCALE	DATE	DRAWN BY	CHECKED BY	REV NO.
1:50		VK		

SUBJECT-


**PROPOSED
RESIDENCE AT
HOMKAR NAGAR,
SOLAPUR.**

ARCHITECT-

NAME-VAISHNAVI GUNVANT KARBHARI.
BATCH - 3RD YEAR [SEM-VI]
COLLEGE NAME - SSSM'S COLLEGE OF
ARCHITECTURE, SOLAPUR.
ROLL NO. - SSM/21/08.


WORKING DRAWING FOR MR RAUT



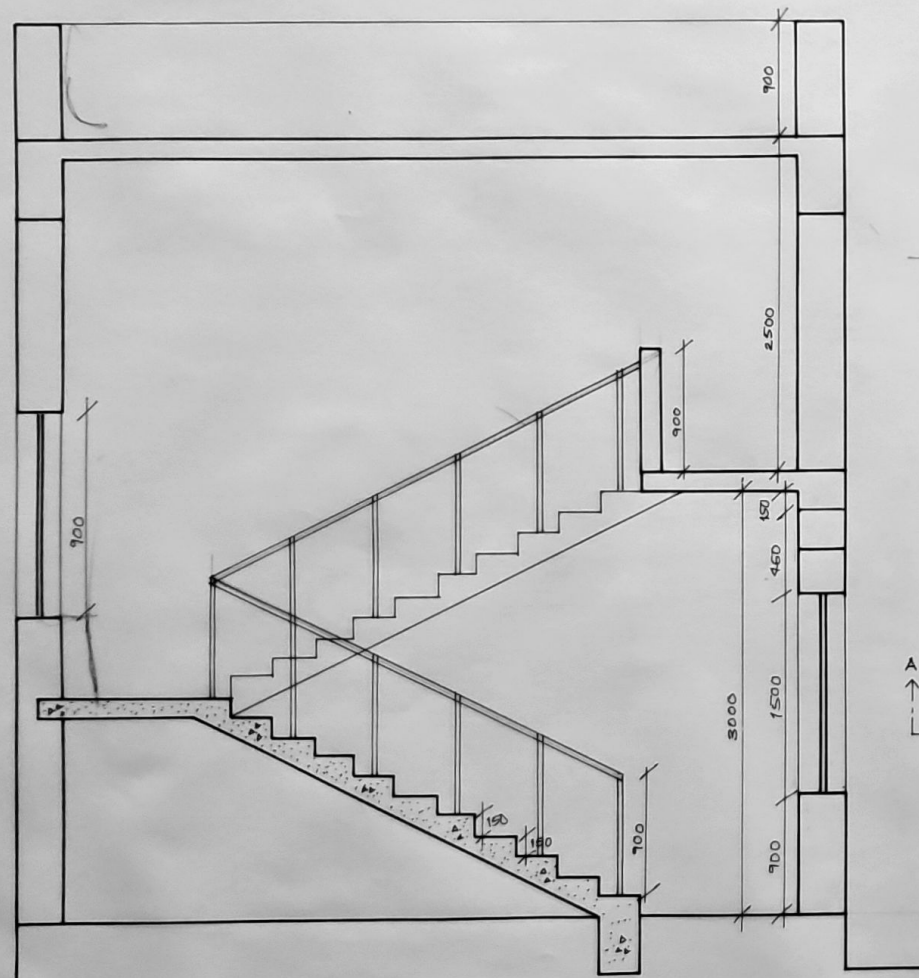


SECTION AA'

SCALE - 1:30

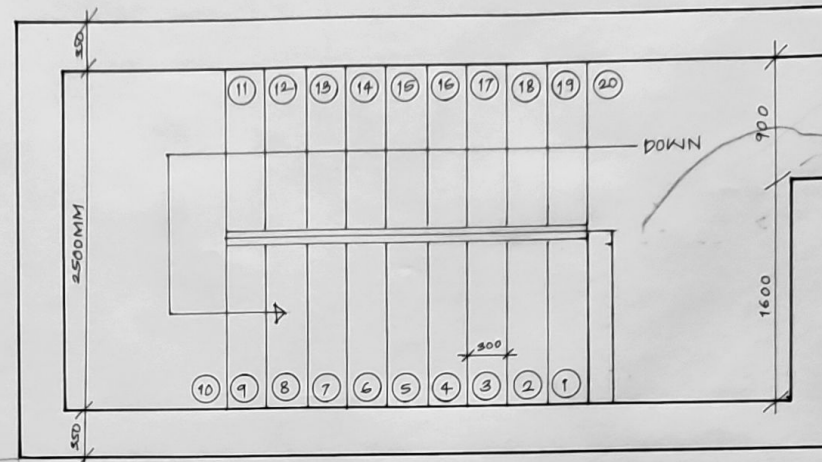

FIRST FLOOR PLAN

SCALE - 1:80

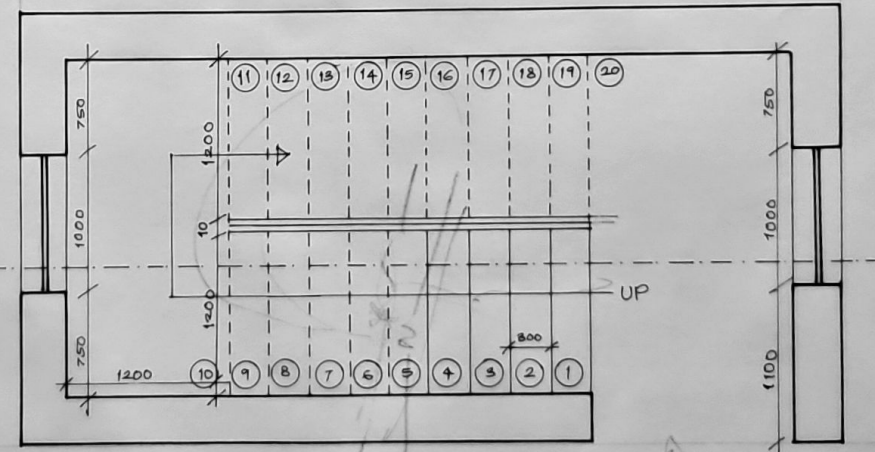


GROUND FLOOR PLAN

SCALE - 1:100

STAIRCASE DETAIL

WORKING DRAWING - 1

SHEET NO.

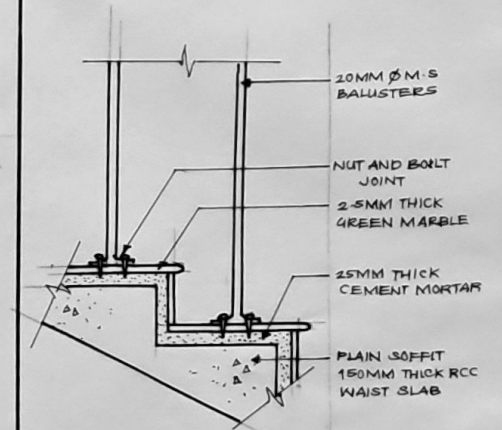

HANDRAIL FIXING DETAIL

SCALE - 1:10


NOTE-

1. ALL DIMENSIONS ARE IN MM UNIT UNTIL SPECIFIED
2. DO NOT MEASURE DRAWING, FOLLOW WRITTEN DIMENSIONS ONLY.
3. PLEASE REFER TO THE ARCHITECT IN CONCERN OF ANY QUERY.
4. THE DRAWING IS THE PROPERTY OF THE ARCHITECT AND SHALL NOT BE USED OR REPRODUCED WITHOUT THEIR WRITTEN CONCENT

SCALE	DATE	DRAWN BY	CHECKED BY	REV NO.
1:80		VK		

SUBJECT-

 PROPOSED
RESIDENCE AT
HOMKAR NAGAR,
SOLAPUR.




ARCHITECT-

NAME - VAISHNAVI GUNVANT KARBHARI.
BATCH - 3RD YEAR [SEM - VI]
COLLEGE NAME - SSSM'S COLLEGE
OF ARCHITECTURE, SOLAPUR.
ROLL NO. - SSM/21/08


WORKING DRAWING FOR MR RAUT



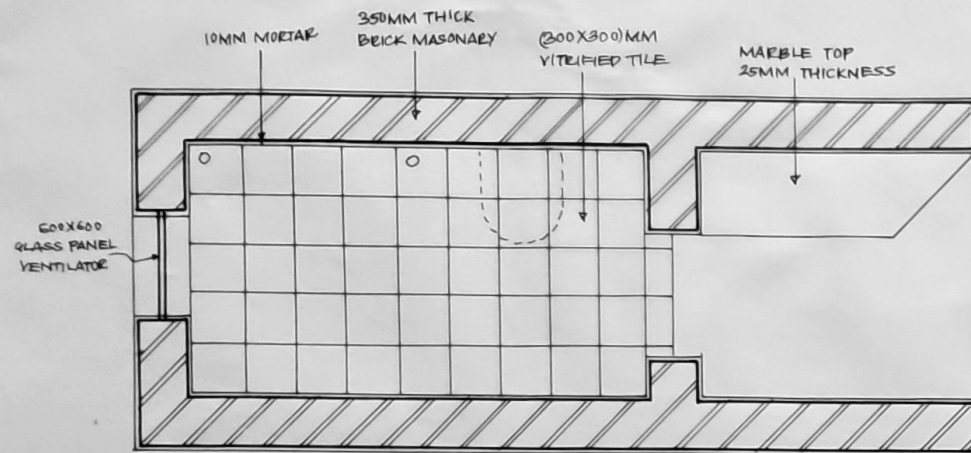



FLOORING LAYOUT PLAN

SCALE - 1:25

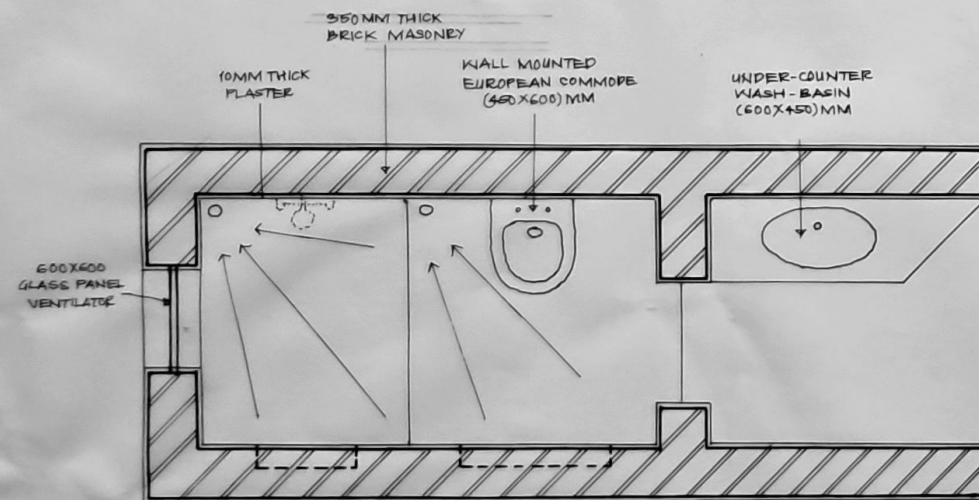

PLAN

SCALE - 1:25

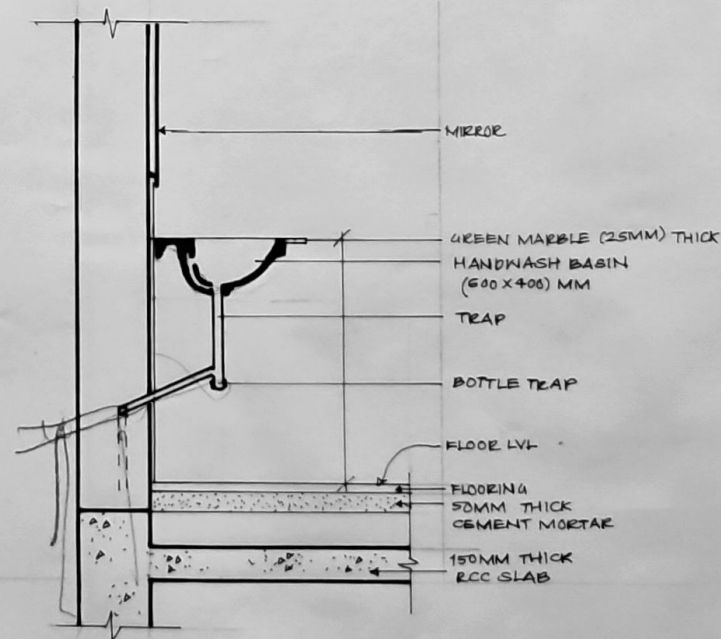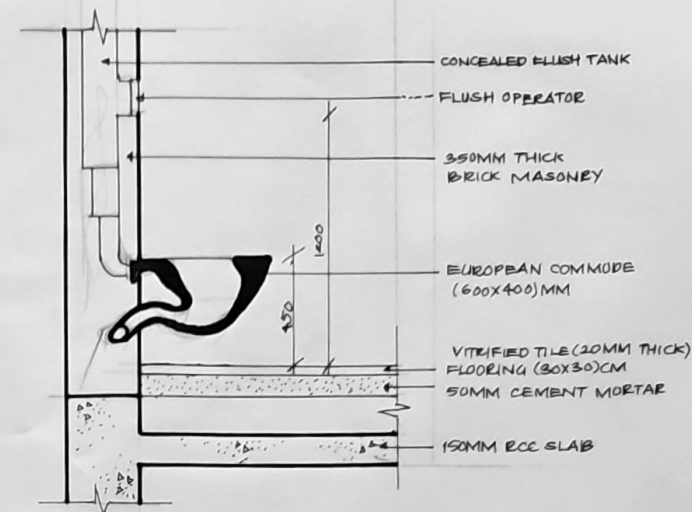

WASH-BASIN DETAIL

SCALE - 1:20

TOILET DETAIL

WORKING DRAWING - 1

SHEET NO.

NOTE-

1. ALL DIMENSIONS ARE IN MM UNIT UNTIL SPECIFIED.
2. DO NOT MEASURE DRAWING, FOLLOW WRITTEN DIMENSIONS ONLY.
3. PLEASE REFER TO THE ARCHITECT IN CONCERN TO ANY QUERY OF DRAWING.
4. THE DRAWING IS A PROPERTY OF THE ARCHITECT AND SHALL NOT BE USED OR REPRODUCED WITHOUT THEIR WRITTEN CONCENT.

SCALE	DATE	DRAWN BY	CHECKED BY	REV NO.
1:25		YK		

SUBJECT-


PROPOSED
RESIDENCE AT
HOMKAR NAGAR,
SOLAPUR.




ARCHITECT-

NAME-VAISHNAVI GUNVANT KARBHARI.
BATCH - 3RD YEAR [SEM - VI]
COLLEGE NAME - SSSM'S COLLEGE
OF ARCHITECTURE, SOLAPUR.
ROLL NO. - SSSM/ 21/08


WORKING DRAWING FOR MR. RAUT

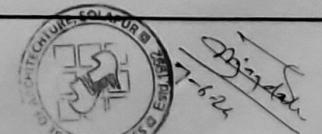

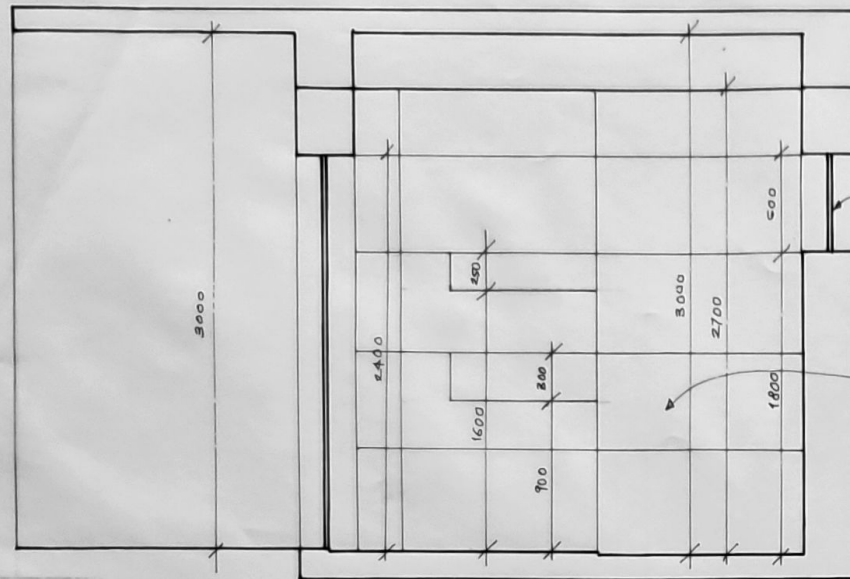


SECTION AA'

SCALE - 1:25

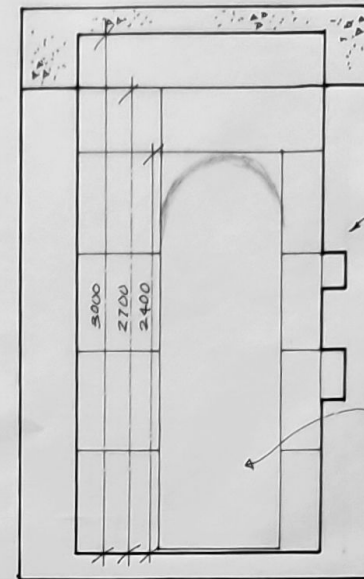


SECTION BB'

SCALE - 1:25

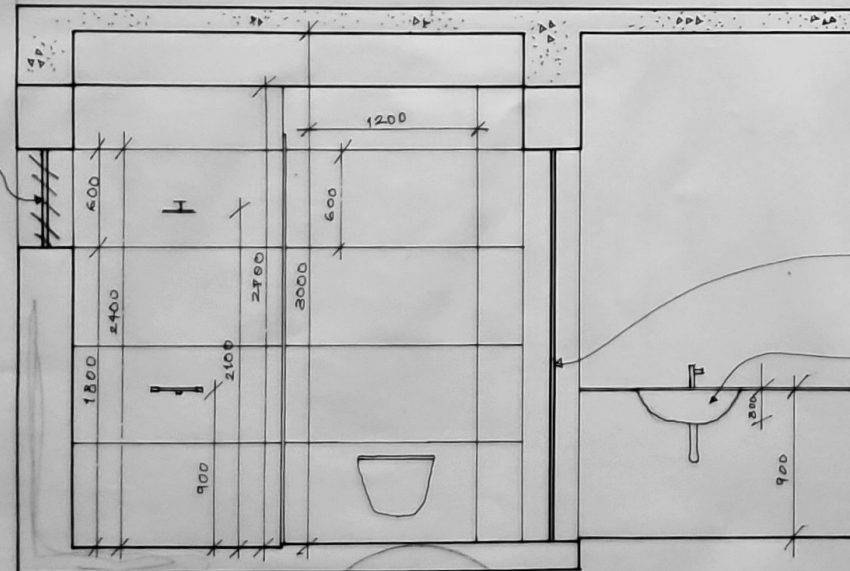

SECTION CC'

SCALE - 1:25

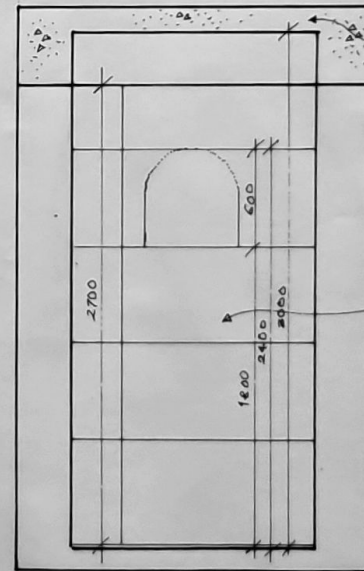

SECTION DD'

SCALE - 1:25

TOILET DETAIL

WORKING DRAWING - I

SHEET NO.

NOTE-

1. ALL DIMENSIONS ARE IN MM UNIT UNTIL SPECIFIED.
2. DO NOT MEASURE DRAWING, FOLLOW WRITTEN DIMENSIONS ONLY.
3. PLEASE REFER TO THE ARCHITECT IN CONCERN OF ANY QUERY.
4. THE DRAWING IS THE PROPERTY OF THE ARCHITECT AND SHALL NOT BE USED OR REPRODUCED WITHOUT THEIR WRITTEN CONCENT

SCALE	DATE	DRAWN BY	CHECKED BY	REV NO.
1:25		VK		

SUBJECT


**PROPOSED
RESIDENCE AT
HOMKAR NAGAR
SOLAPUR.**

ARCHITECT -

NAME - VAISHNAVI GUNVANT KARBHARI.
BATCH - 3RD YEAR [SEM - VI]
COLLEGE NAME - SSSM'S COLLEGE
OF ARCHITECTURE, SOLAPUR.
ROLL NO. - SSM/21/08.

WORKING DRAWING FOR MR RAUT



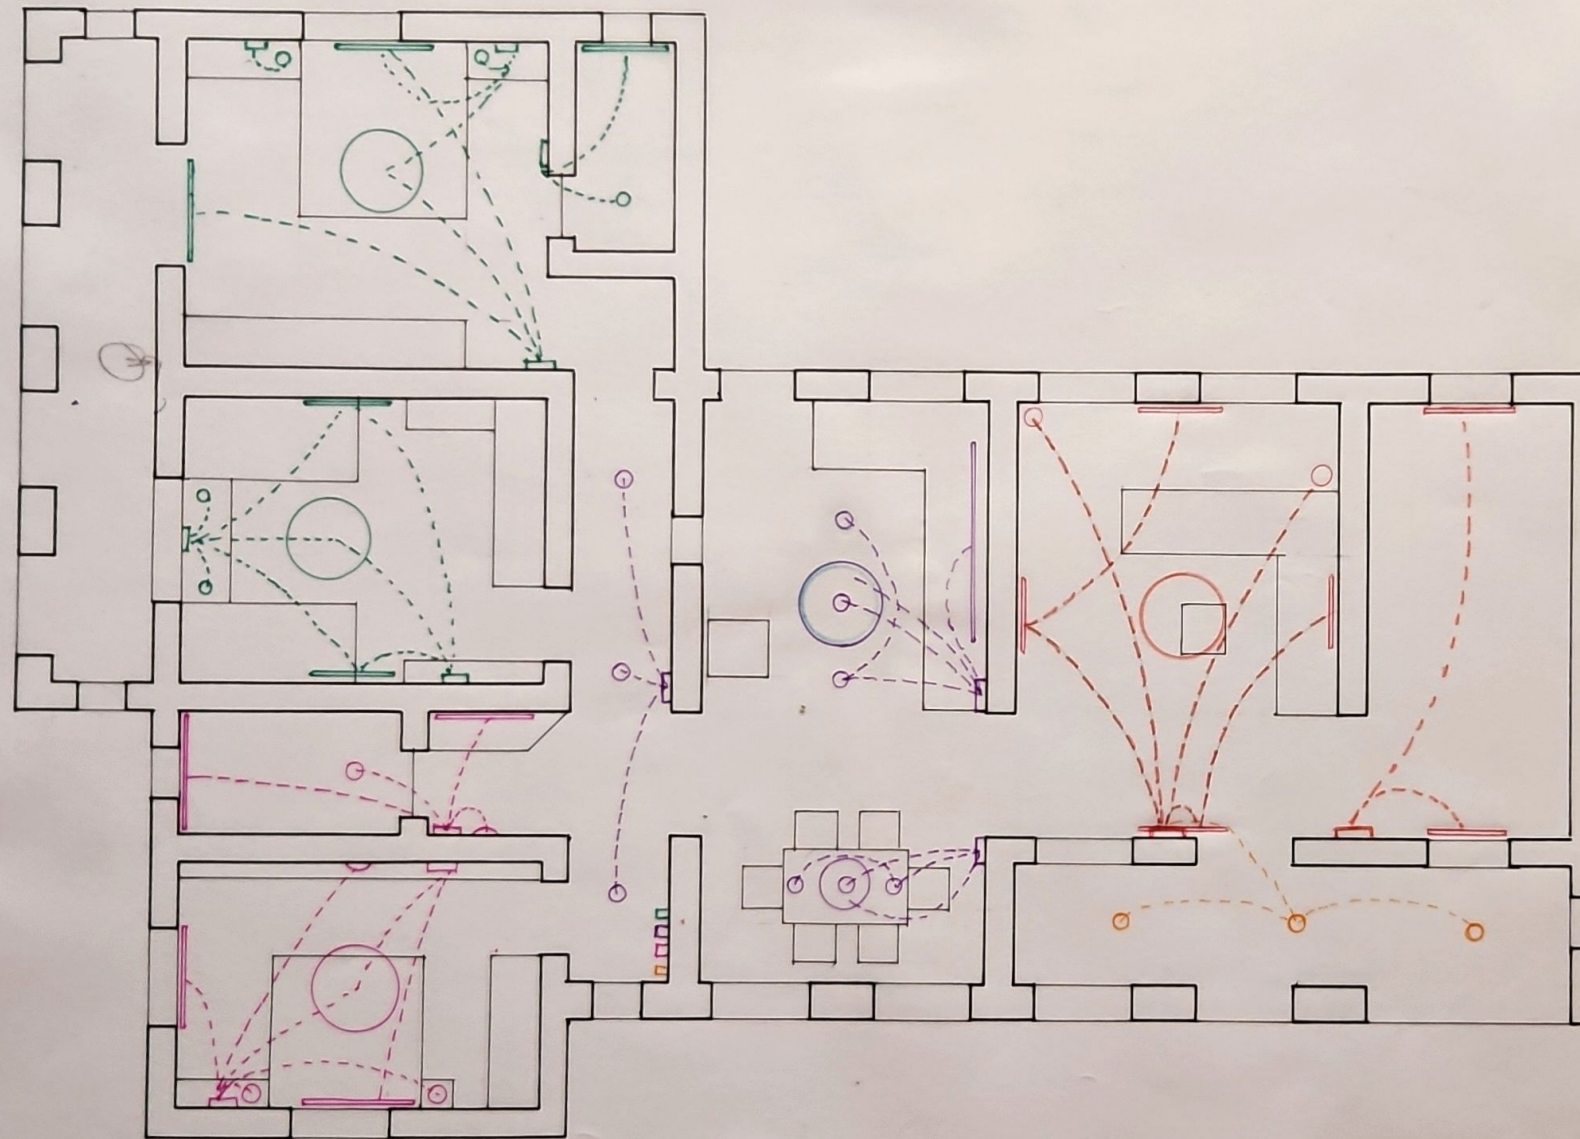

ELECTRICAL LAYOUT PLAN


SCALE - 1:50

ELECTRICAL LAYOUT

WORKING DRAWING - I SHEET NO. -

— TUBELIGHT
○ FLOOR LAMP
— WALL MOUNTED LAMP

ELECTRIFICATION - CONCEALED MODULAR

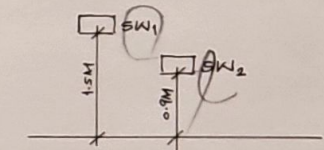

- NOTE -
1. ALL DIMENSIONS ARE IN MM UNIT UNTIL SPECIFIED.
 2. DO NOT MEASURE DRAWING, FOLLOW WRITTEN DIMENSIONS ONLY.
 3. PLEASE REFER TO THE ARCHITECT IN CONCERN OF ANY QUERY.
 4. THE DRAWING IS THE PROPERTY OF THE ARCHITECT AND SHALL NOT BE USED OR REPRODUCED WITHOUT THEIR WRITTEN CONCENT.

SCALE	DATE	DRAWN BY	CHECKED BY	REV NO.
1:50		VK		

SUBJECT -


**PROPOSED
RESIDENCE AT
HOMKAR NAGAR
SOLAPUR.**

ARCHITECT -

NAME - VAISHNAVI GUNVANT KARBHARI.
BATCH - 3RD YEAR [SEM-VI]
COLLEGE NAME - SSSM'S COLLEGE
OF ARCHITECTURE, SOLAPUR.
ROLL NO. - SSM/21/08.

WORKING DRAWING FOR MR RAUT



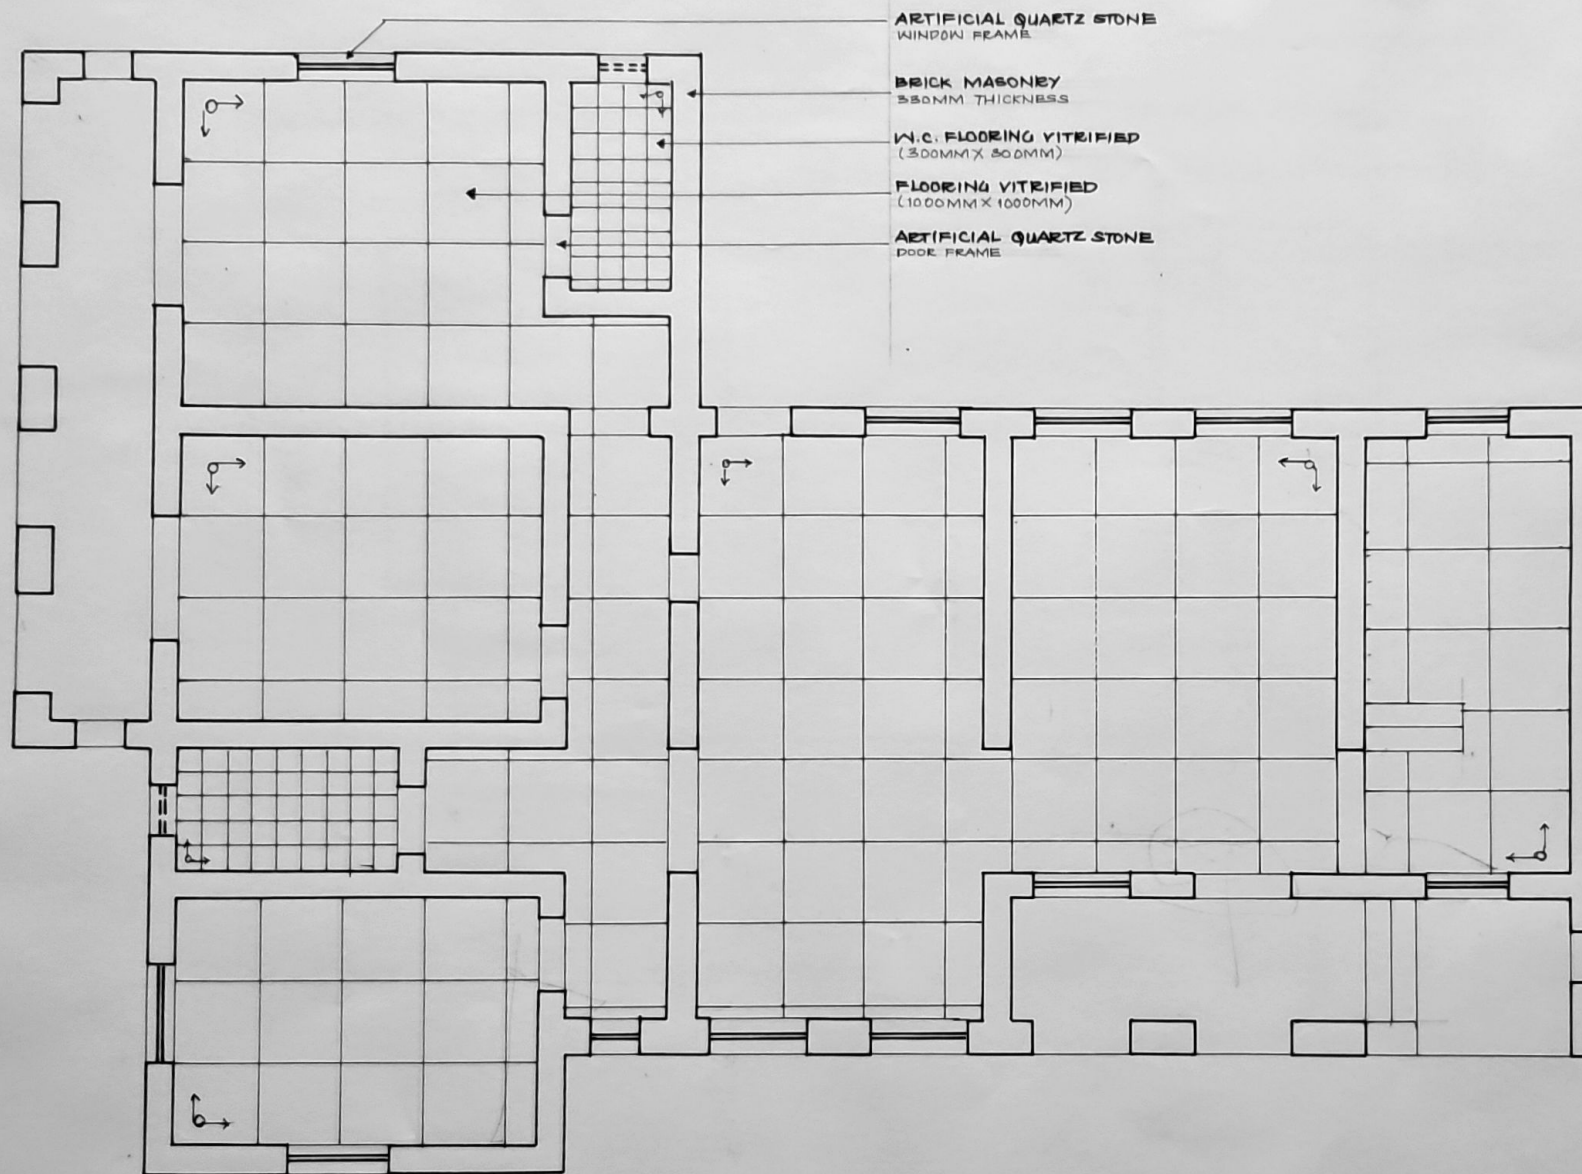

PLAN
SCALE - 1:50

ARTIFICIAL QUARTZ STONE
WINDOW FRAME

BRICK MASONRY
350MM THICKNESS

W.C. FLOORING VITRIFIED
(300MM X 500MM)


FLOORING VITRIFIED
(1000MM X 1000MM)

ARTIFICIAL QUARTZ STONE
DOOR FRAME

FLOORING LAYOUT

WORKING DRAWING - 1

SHEET NO. -

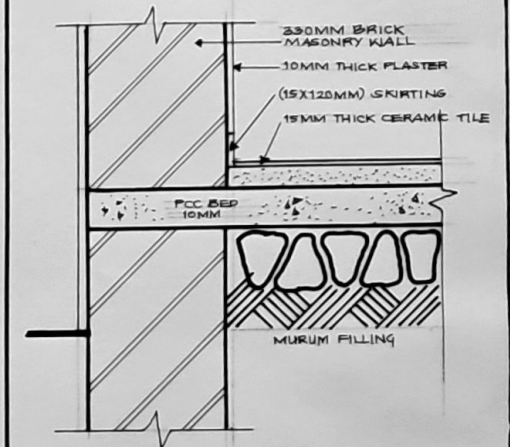

FLOORING DETAIL

NOTE -

1. ALL DIMENSIONS ARE IN MM UNIT UNTIL SPECIFIED.
2. DO NOT MEASURE DRAWING, FOLLOW WRITTEN DIMENSIONS ONLY.
3. PLEASE REFER TO THE ARCHITECT IN CONCERN OF ANY QUERY.
4. THE DRAWING IS THE PROPERTY OF THE ARCHITECT AND SHALL NOT BE USED OR REPRODUCED WITHOUT THEIR WRITTEN CONCENT.

SCALE	DATE	DRAWN BY	CHECKED BY	REV NO.
1:50		VK		

SUBJECT -

PROPOSED
RESIDENCE AT
HOMIKAR NAGAR,
SOLAPUR.



ARCHITECT -


NAME - VAISHNAVI GUNVANT KARBHARI.
BATCH - 3RD YEAR [SEM - VI]
COLLEGE NAME - SSM'S COLLEGE
OF ARCHITECTURE, SOLAPUR.
ROLL NO. SSM/21/08.

WORKING DRAWING FOR MR RAUT



SITE PLAN

WORKING DRAWING - I SHEET NO.

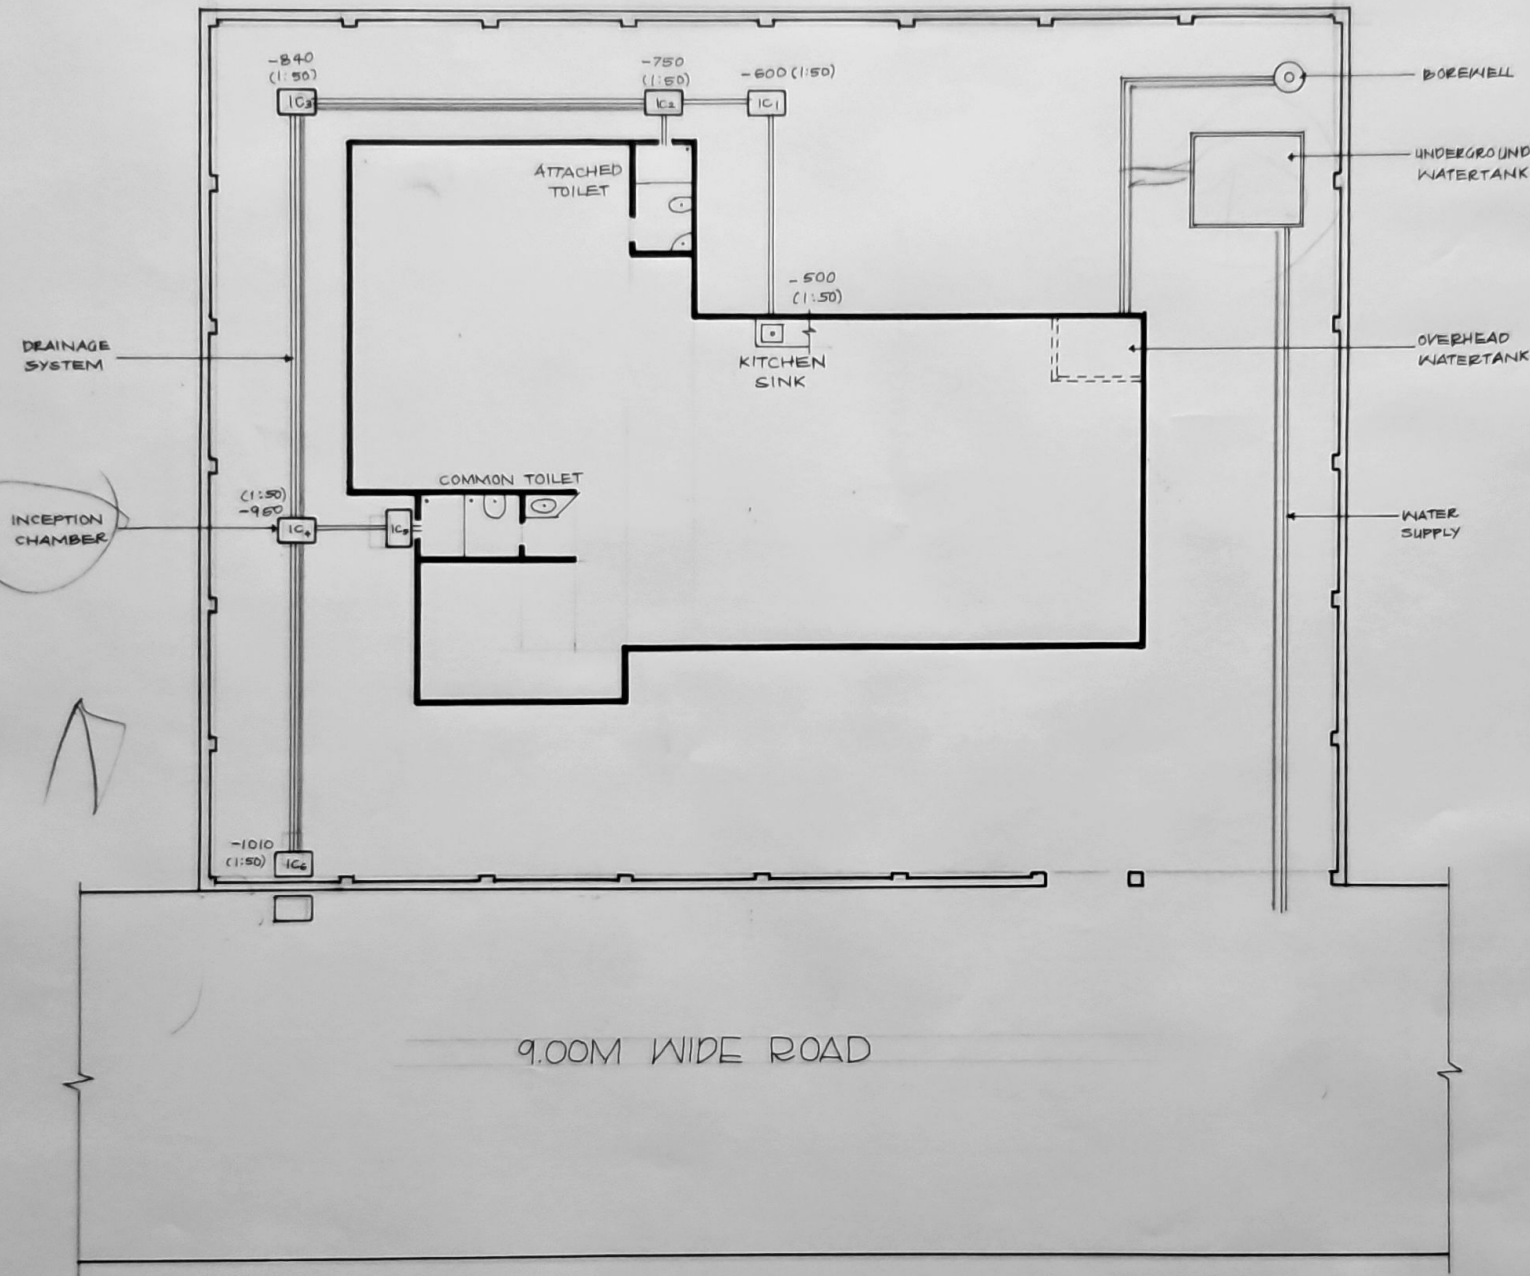

NOTE -
 1. ALL DIMENSIONS ARE IN MM UNIT UNTIL SPECIFIED.
 2. DO NOT MEASURE DRAWING, FOLLOW WRITTEN DIMENSIONS ONLY.
 3. PLEASE REFER TO THE ARCHITECT IN CONCERN TO ANY QUERY OF DRAWING.
 4. THE DRAWING IS A PROPERTY OF AN ARCHITECT AND SHALL NOT BE USED OR REPRODUCED WITHOUT THEIR WRITTEN CONCENT

SCALE	DATE	DRAWN BY	CHECKED BY	REV NO.
1:100		YK		

SUBJECT-

PROPOSED
 RESIDENCE AT
 HOMKAR NAGAR,
 SOLAPUR.

N

ARCHITECT -


NAME-VAISHNAVI GUNVANT KARBHARI.
 BATCH - 3RD YEAR [SEM-VI]
 COLLEGE NAME - SSSM'S COLLEGE
 OF ARCHITECTURE, SOLAPUR.
 ROLL NO. - SSM/21/08.

WORKING DRAWING FOR MR. RAUT



SITE PLAN

WORKING DRAWING-1 SHEET NO.

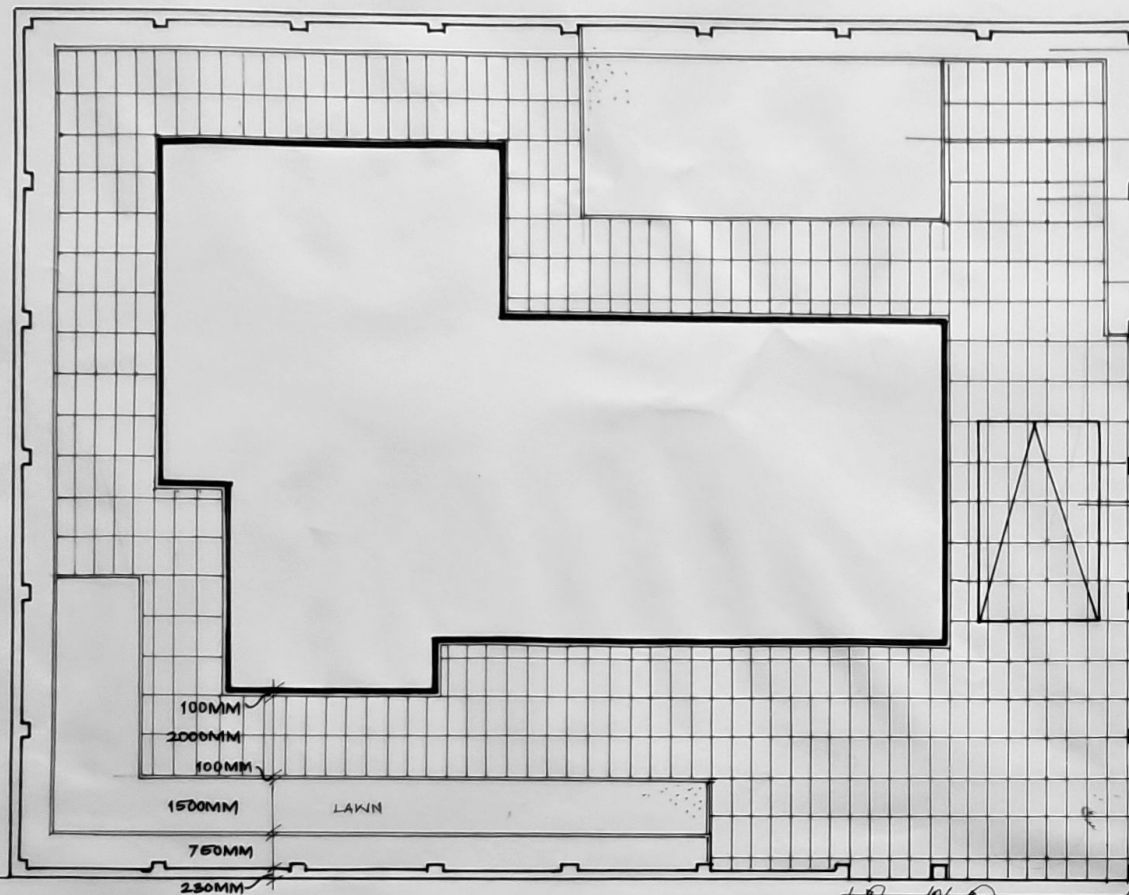

FLOWER BED
(750MM WIDTH)

LAWN
(SCUCH GRASS)

PAVER
ON SITE CONSTRUCTE
CONCRETE LINING

100MM THICK CURB

830MM THICK
BRICK SUPPORT


280MM THICK
BRICK MASONRY

4-WHEELER
PARKING

100MM
2000MM
100MM
1500MM
750MM
230MM

9.00M WIDE ROAD

SITE PLAN
SCALE - 1:100

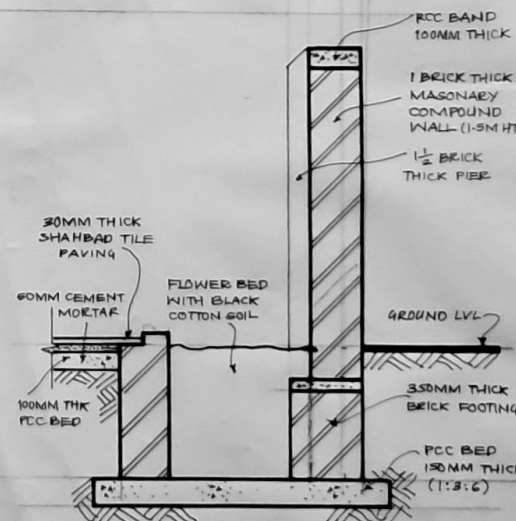

COMPOUND WALL DETAIL
SCALE - 1:20

NOTE -

1. ALL DIMENSIONS ARE IN MM UNIT UNTIL SPECIFIED.
2. DO NOT MEASURE DRAWING, FOLLOW WRITTEN DIMENSIONS ONLY.
3. PLEASE REFER TO THE ARCHITECT IN CONCERN OF ANY QUERY.
4. THE DRAWING IS THE PROPERTY OF THE ARCHITECT AND SHALL NOT BE USED FOR REPRODUCED WITHOUT THEIR WRITTEN CONCENT.

SCALE	DATE	DRAWN BY	CHECKED BY	REV NO.
1:100		VK		

SUBJECT -

PROPOSED
RESIDENCE AT
HOMKAR NAGAR
SOLAPUR




ARCHITECT -

NAME - VAISHNAVI GUNVANT KARBHARI.
BATCH - 3RD YEAR [SEM-VI]
COLLEGE NAME - SSSM'S COLLEGE
OF ARCHITECTURE, SOLAPUR.
ROLL NO. - 65M/21/08.

WORKING DRAWING FOR MR RAUT



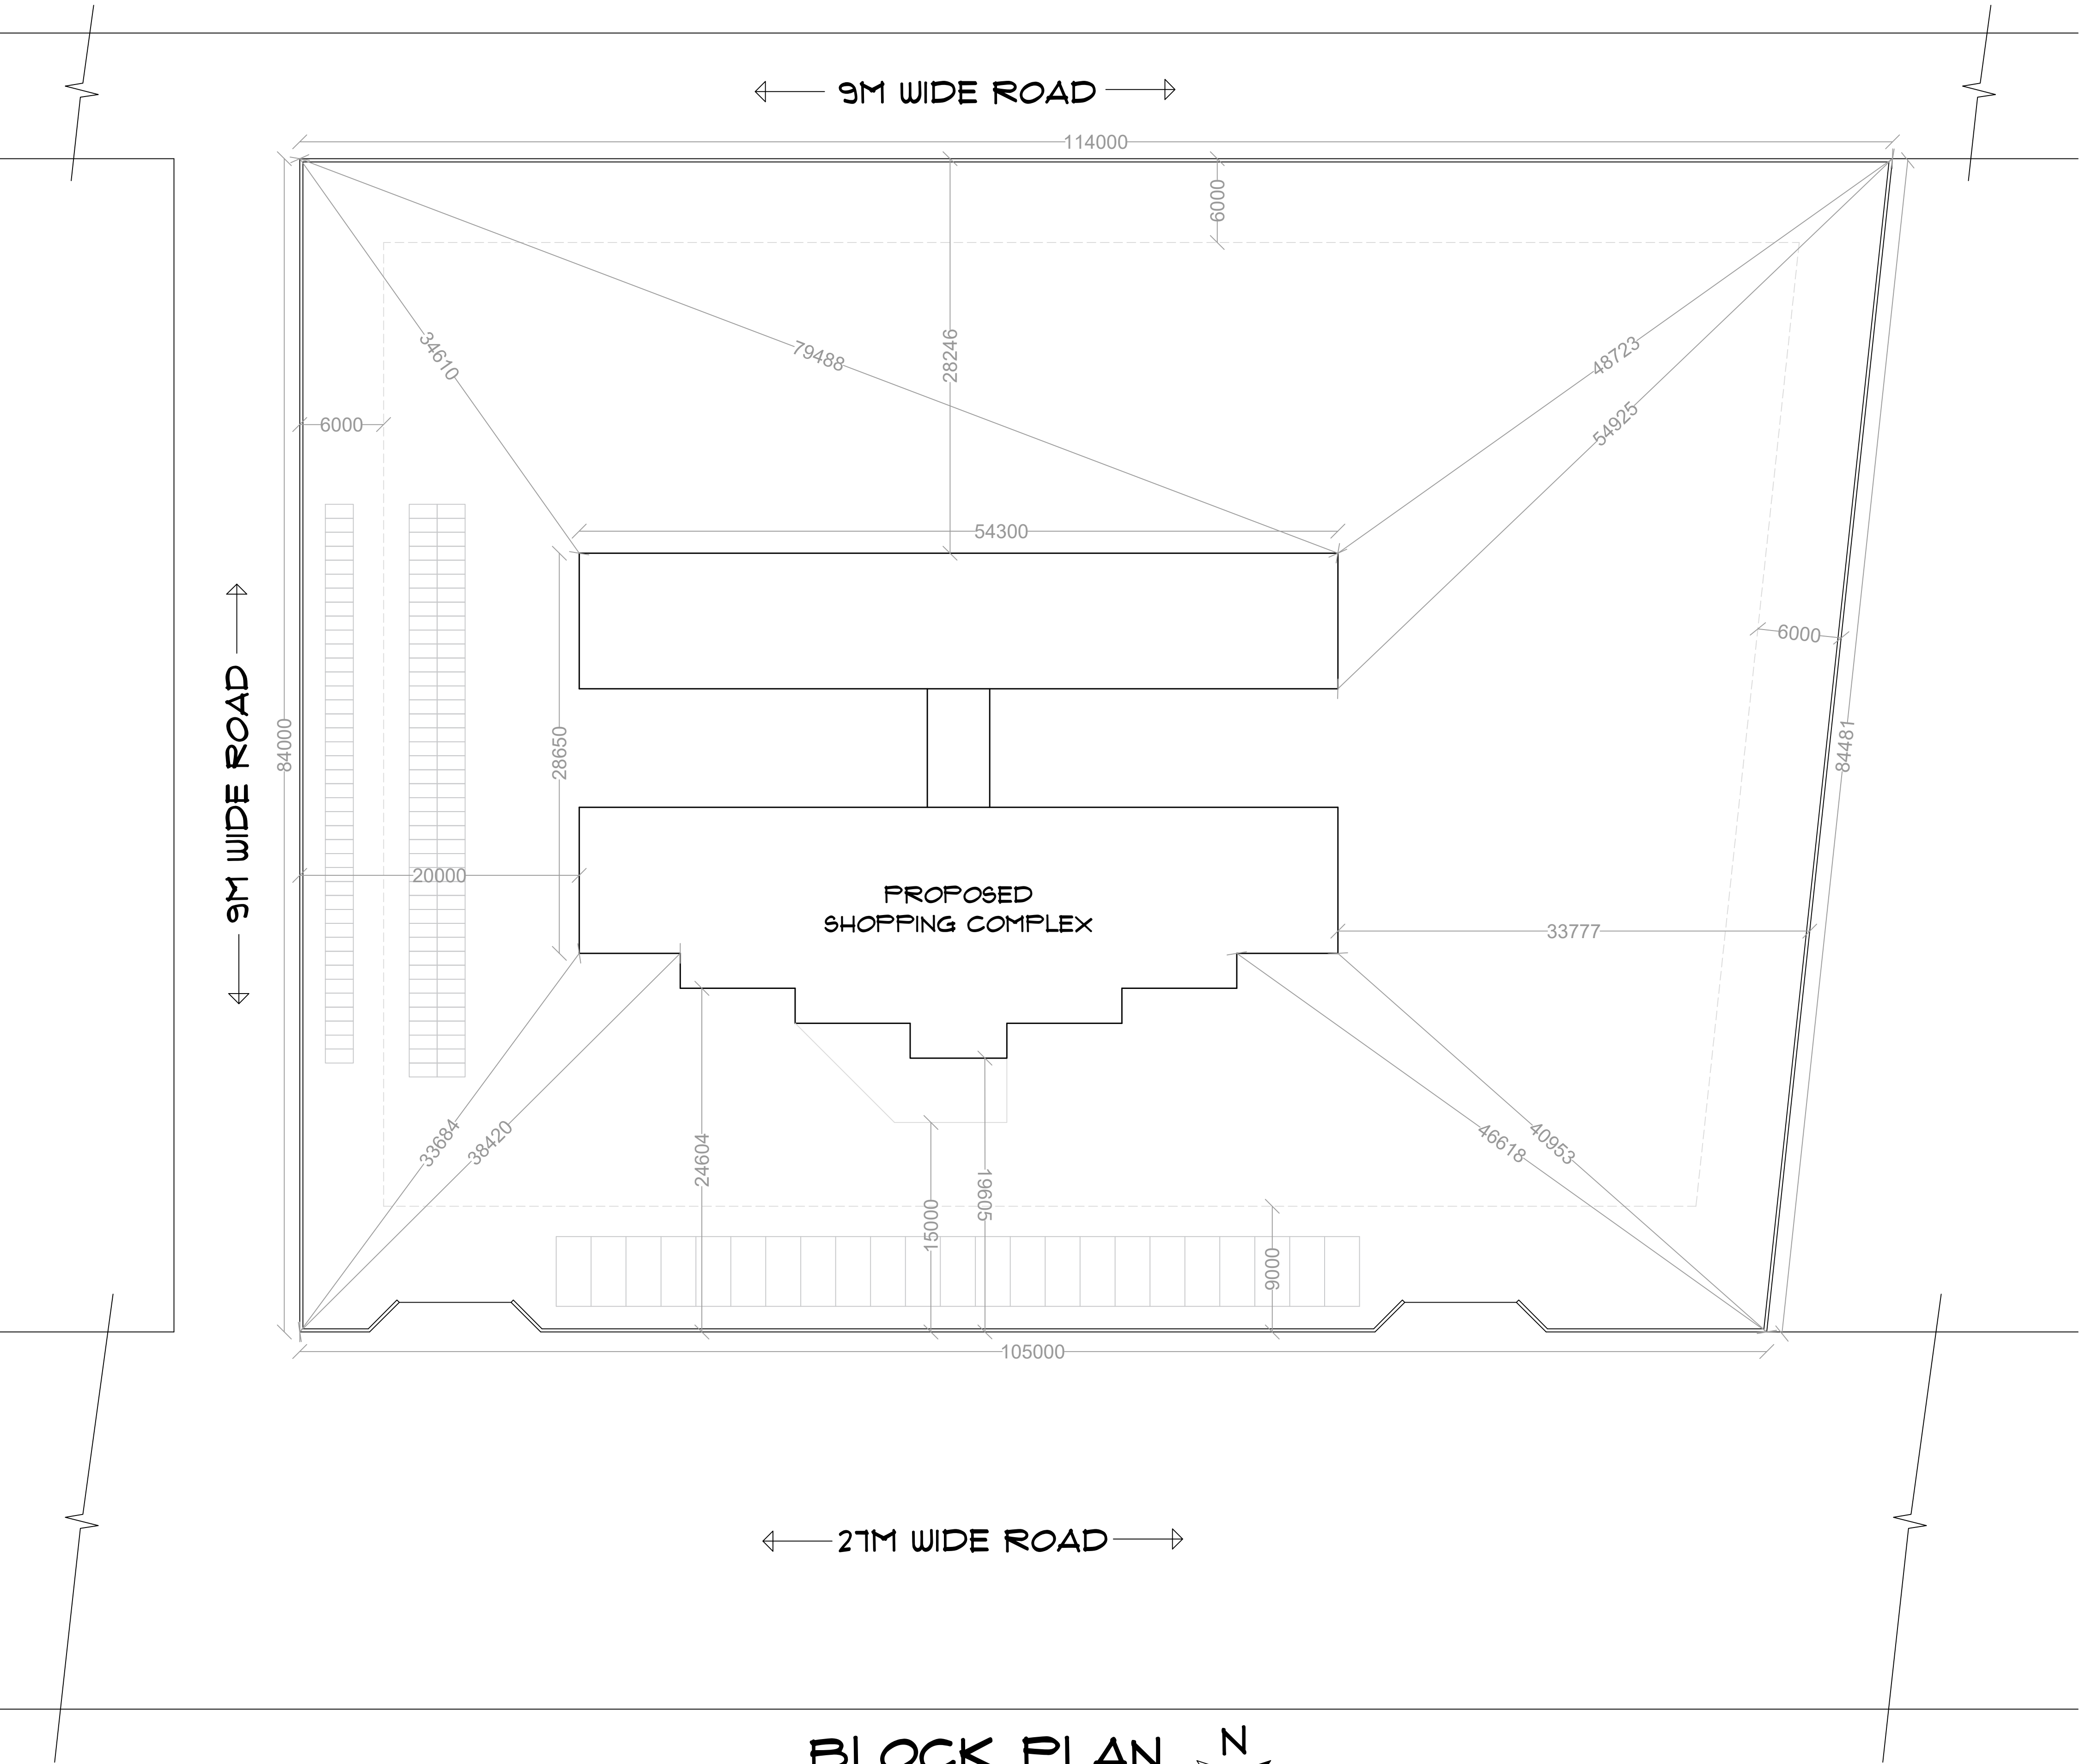


BLOCK PLAN
SCALE - 1:250

PROFORMA -

WORKING DRAWING - II

SHEET TITLE -

SITE DEMARKATION

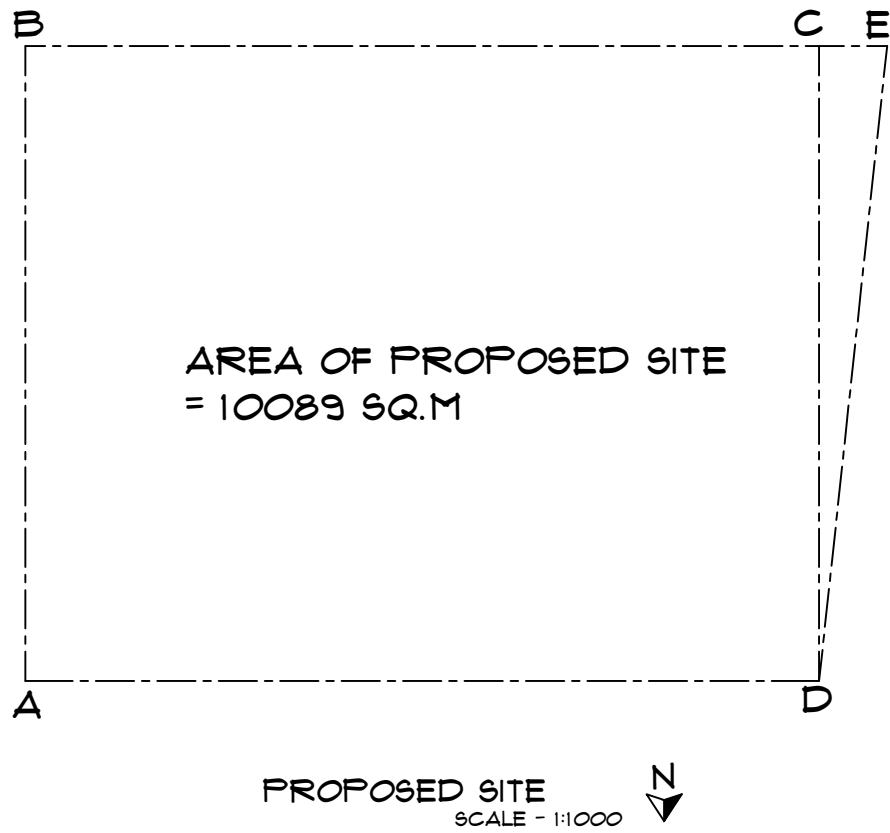

AREA OF PROPOSED SITE =
(BY RECTANGLE AND TRIANGULATION METHOD)
AREA OF $\square ABCD$ + AREA OF $\triangle CDE$ =
= (SIDE AB $\times$ SIDE AD) + (0.5 $\times$ CD $\times$ CE)
= (114 $\times$ 84) + (0.5 $\times$ 114 $\times$ 9)
= 9576 + 513
= 10089 SQ.M

NOTES -

- 1) ALL DIMENSIONS ARE IN MM UNTIL SPECIFIED.
- 2) DO NOT MEASURE DRAWING, FOLLOW WRITTEN DIMENSIONS ONLY.
- 3) PLEASE REFER TO THE ARCHITECT IN CONCERN TO ANY QUERY OR DRAWING.
- 4) THIS DRAWING IS A PROPERTY OF THE ARCHITECT AND SHALL NOT BE REPRODUCED OR USED WITHOUT THEIR WRITTEN PERMISSION.

SCALE -

DATE -

REV NO. -

1 : 500


10/10/2024

DRAWN BY -

CHECKED BY -

YK

AR NS

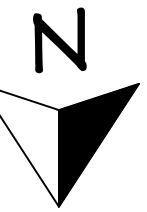


PROJECT -

**PROPOSED
SHOPPING COMPLEX
AT SOLAPUR**

ARCHITECT -

VAISHNAVI G. KARBHARI.
ROLL NO. - 99M/21/08
4TH YR, SEM VII (B.ARCH)
99M'S COLLEGE OF
ARCHITECTURE, SOLAPUR.

SIGN AND STAMP -

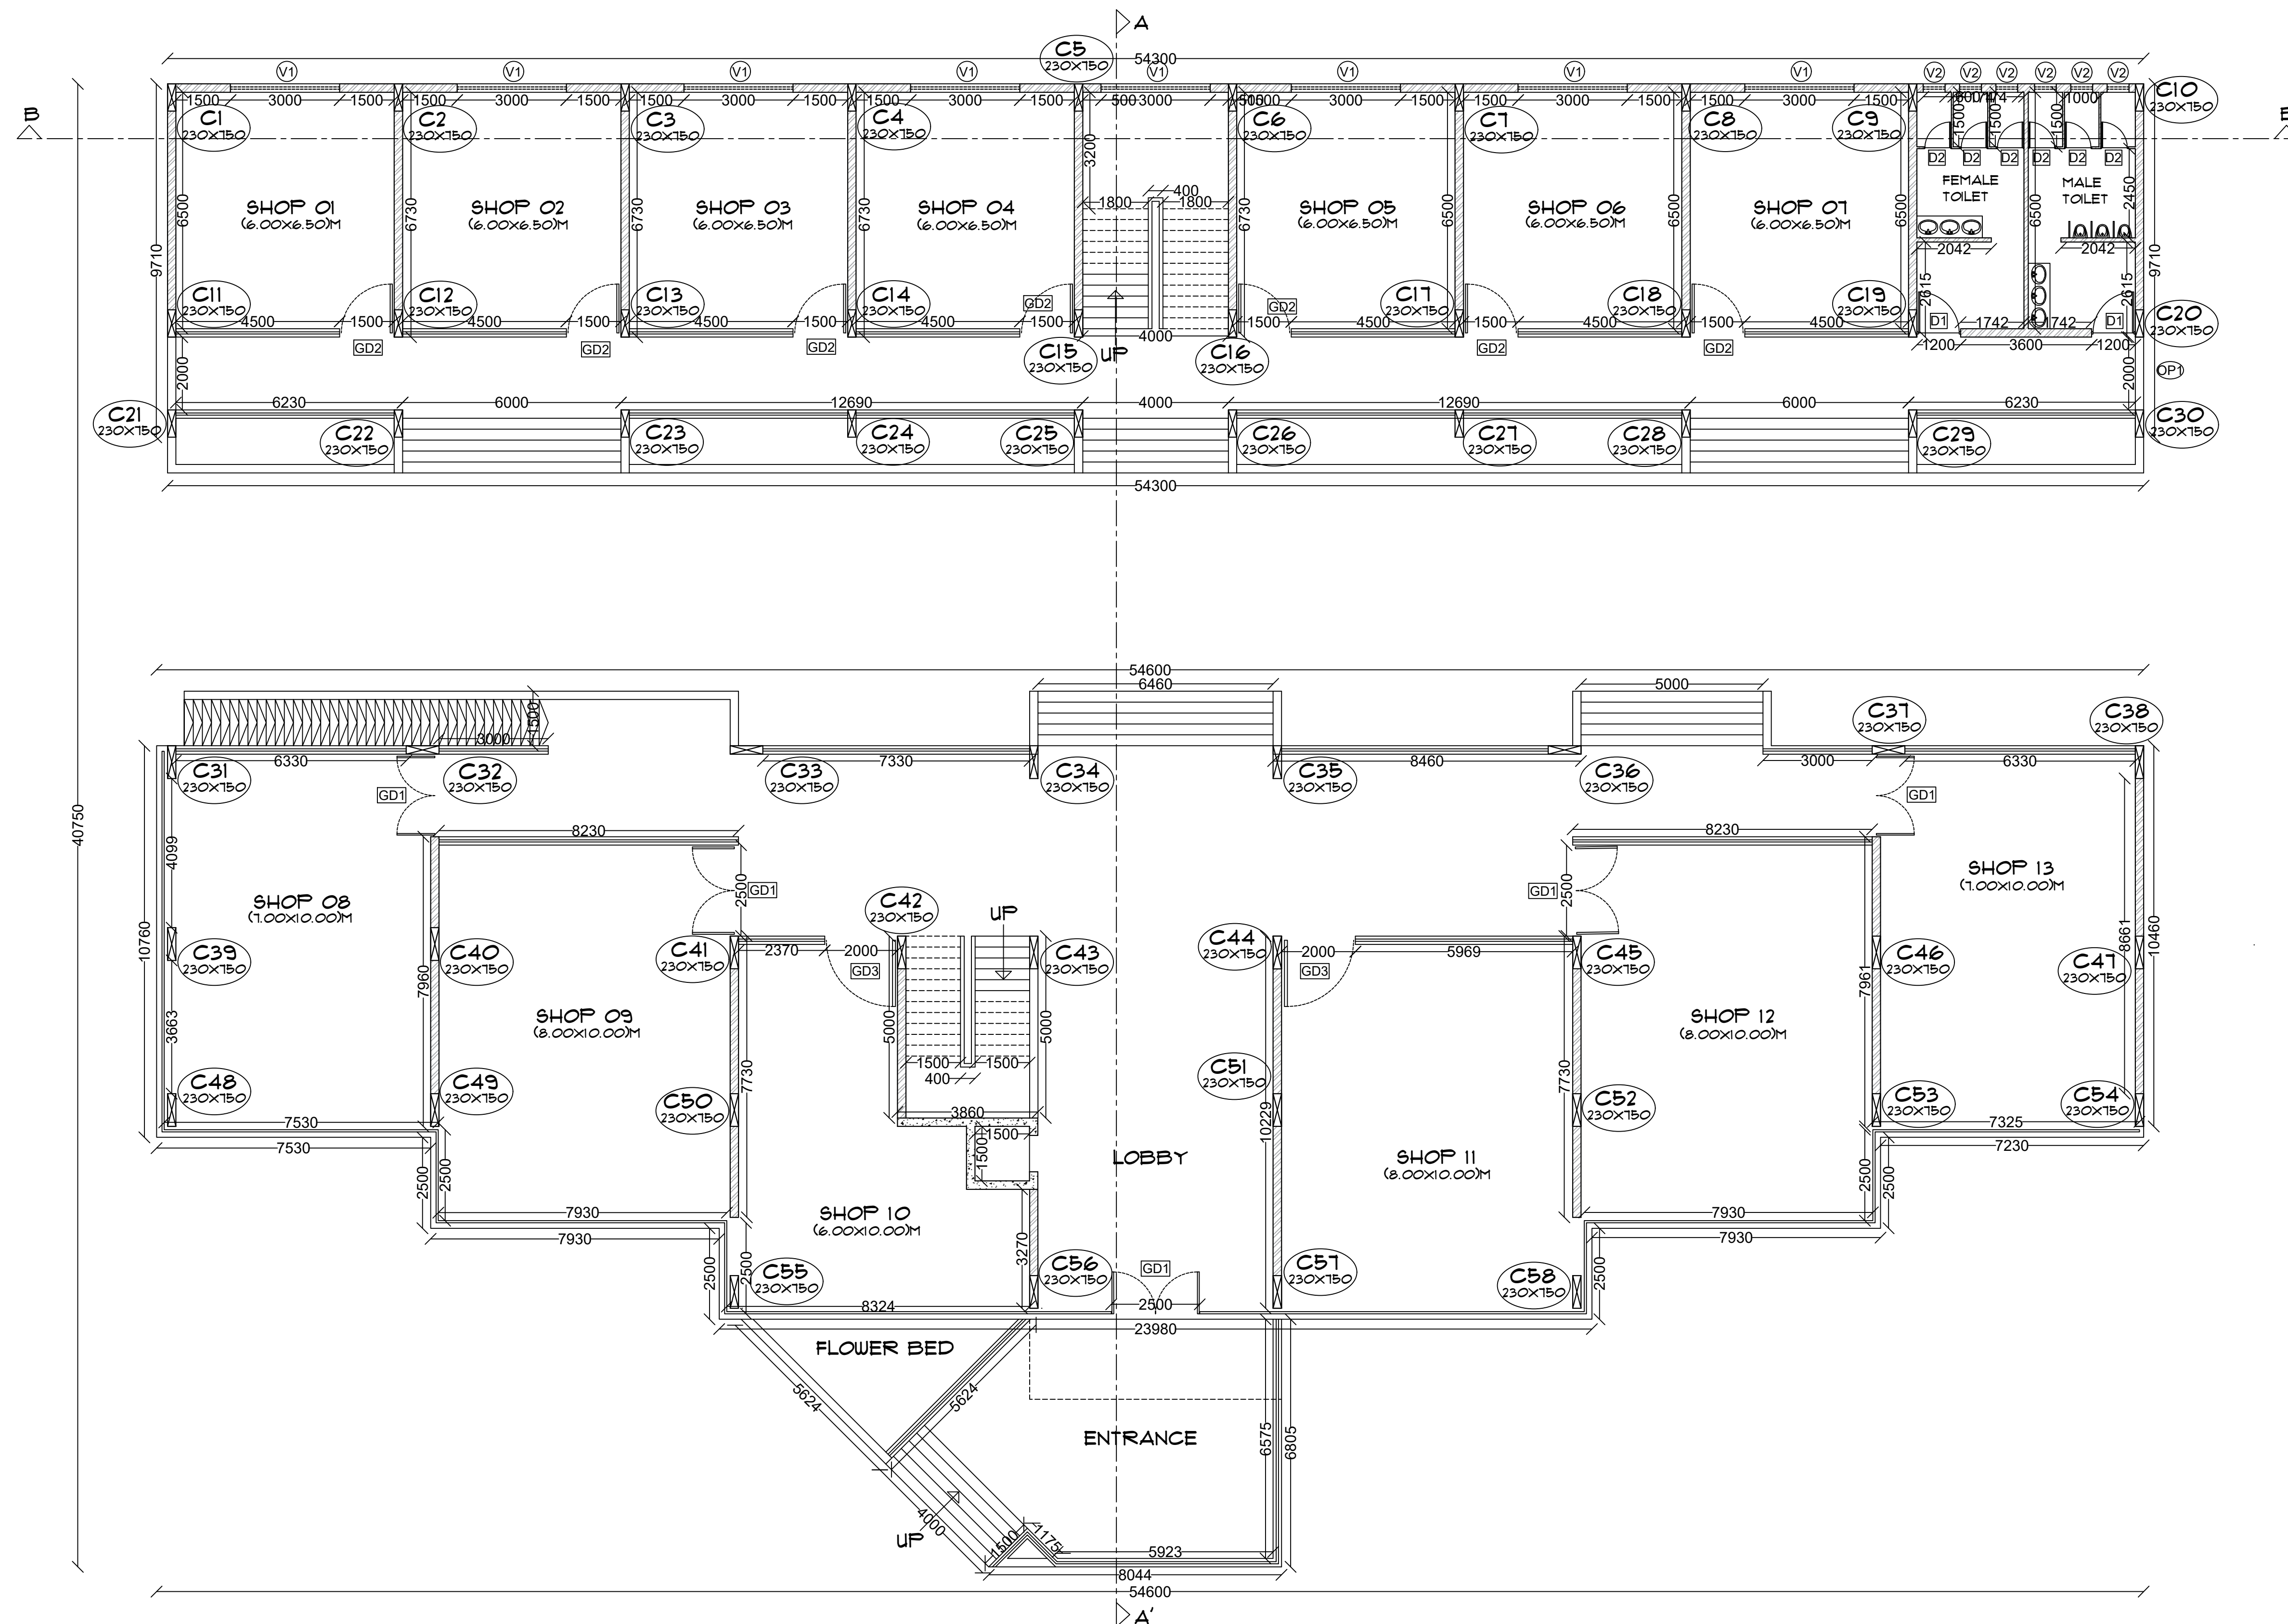

GROUND FOOR PLAN
SCALE - 1:100



PROFORMA -

WORKING DRAWING - II

SHEET TITLE -

GROUND FLOOR PLAN

OPENING SCHEDULE :

OPENING	INDICATION	SIZE
VENTILATOR 1	(V1)	(3.0X0.8)M
VENTILATOR 2	(V2)	(0.6X0.6)M
GLASS DOOR 1	(GD1)	(2.5X2.1)M
GLASS DOOR 2	(GD2)	(1.5X2.5)M
GLASS DOOR 3	(GD3)	(2.0X2.1)M
DOOR 1	(D1)	(1.2X2.5)M
DOOR 2	(D2)	(0.15X2.1)M
DOOR 3	(D3)	(0.9X2.4)M
OPENING	(OP1)	(0.2X2.1)M

NOTES -

- 1) ALL DIMENSIONS ARE IN MM UNTIL SPECIFIED.
- 2) DO NOT MEASURE DRAWING, FOLLOW WRITTEN DIMENSIONS ONLY.
- 3) PLEASE REFER TO THE ARCHITECT IN CONCERN TO ANY QUERY OR DRAWING.
- 4) THIS DRAWING IS A PROPERTY OF THE ARCHITECT AND SHALL NOT BE REPRODUCED OR USED WITHOUT THEIR WRITTEN PERMISSION.

SCALE -	DATE -	REV NO. -
1 : 100	10/10/2024	
DRAWN BY -	CHECKED BY -	
VK	AR NS	

PROJECT -

PROPOSED
SHOPPING COMPLEX
AT SOLAPUR

ARCHITECT -

VAISHNAVI G. KARBHARI.
ROLL NO. - 99M/21/08
4TH YR, SEM VII (B.ARCH)
999M'S COLLEGE OF
ARCHITECTURE, SOLAPUR.

SIGN AND STAMP -

PROFORMA -

WORKING DRAWING - II

SHEET TITLE -

FIRST FLOOR PLAN

OPENING SCHEDULE :

OPENING	INDICATION	SIZE
VENTILATOR 1	Ⓥ1	(3.0X0.8)M
VENTILATOR 2	Ⓥ2	(0.6X0.6)M
GLASS DOOR 1	ⓖD1	(2.5X2.1)M
GLASS DOOR 2	ⓖD2	(1.5X2.5)M
GLASS DOOR 3	ⓖD3	(2.0X2.1)M
DOOR 1	ⓓ1	(1.2X2.5)M
DOOR 2	ⓓ2	(0.15X2.1)M
DOOR 3	ⓓ3	(0.9X2.4)M
OPENING	ⓐP1	(0.2X2.1)M

NOTES -


- 1) ALL DIMENSIONS ARE IN MM UNTIL SPECIFIED.
- 2) DO NOT MEASURE DRAWING, FOLLOW WRITTEN DIMENSIONS ONLY.
- 3) PLEASE REFER TO THE ARCHITECT IN CONCERN TO ANY QUERY OR DRAWING.
- 4) THIS DRAWING IS A PROPERTY OF THE ARCHITECT AND SHALL NOT BE REPRODUCED OR USED WITHOUT THEIR WRITTEN PERMISSION.

SCALE - DATE - REV NO. -

1 : 100 10/10/2024

DRAWN BY - CHECKED BY -

YK AR NS

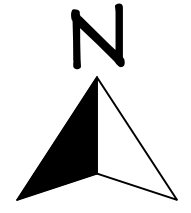


PROJECT -

PROPOSED
SHOPPING COMPLEX
AT SOLAPUR

ARCHITECT -

VAISHNAVI G. KARBHARI.
ROLL NO. - 99M/21/08
4TH YR, SEM VII (B.ARCH)
999M'S COLLEGE OF
ARCHITECTURE, SOLAPUR.


SIGN AND STAMP -

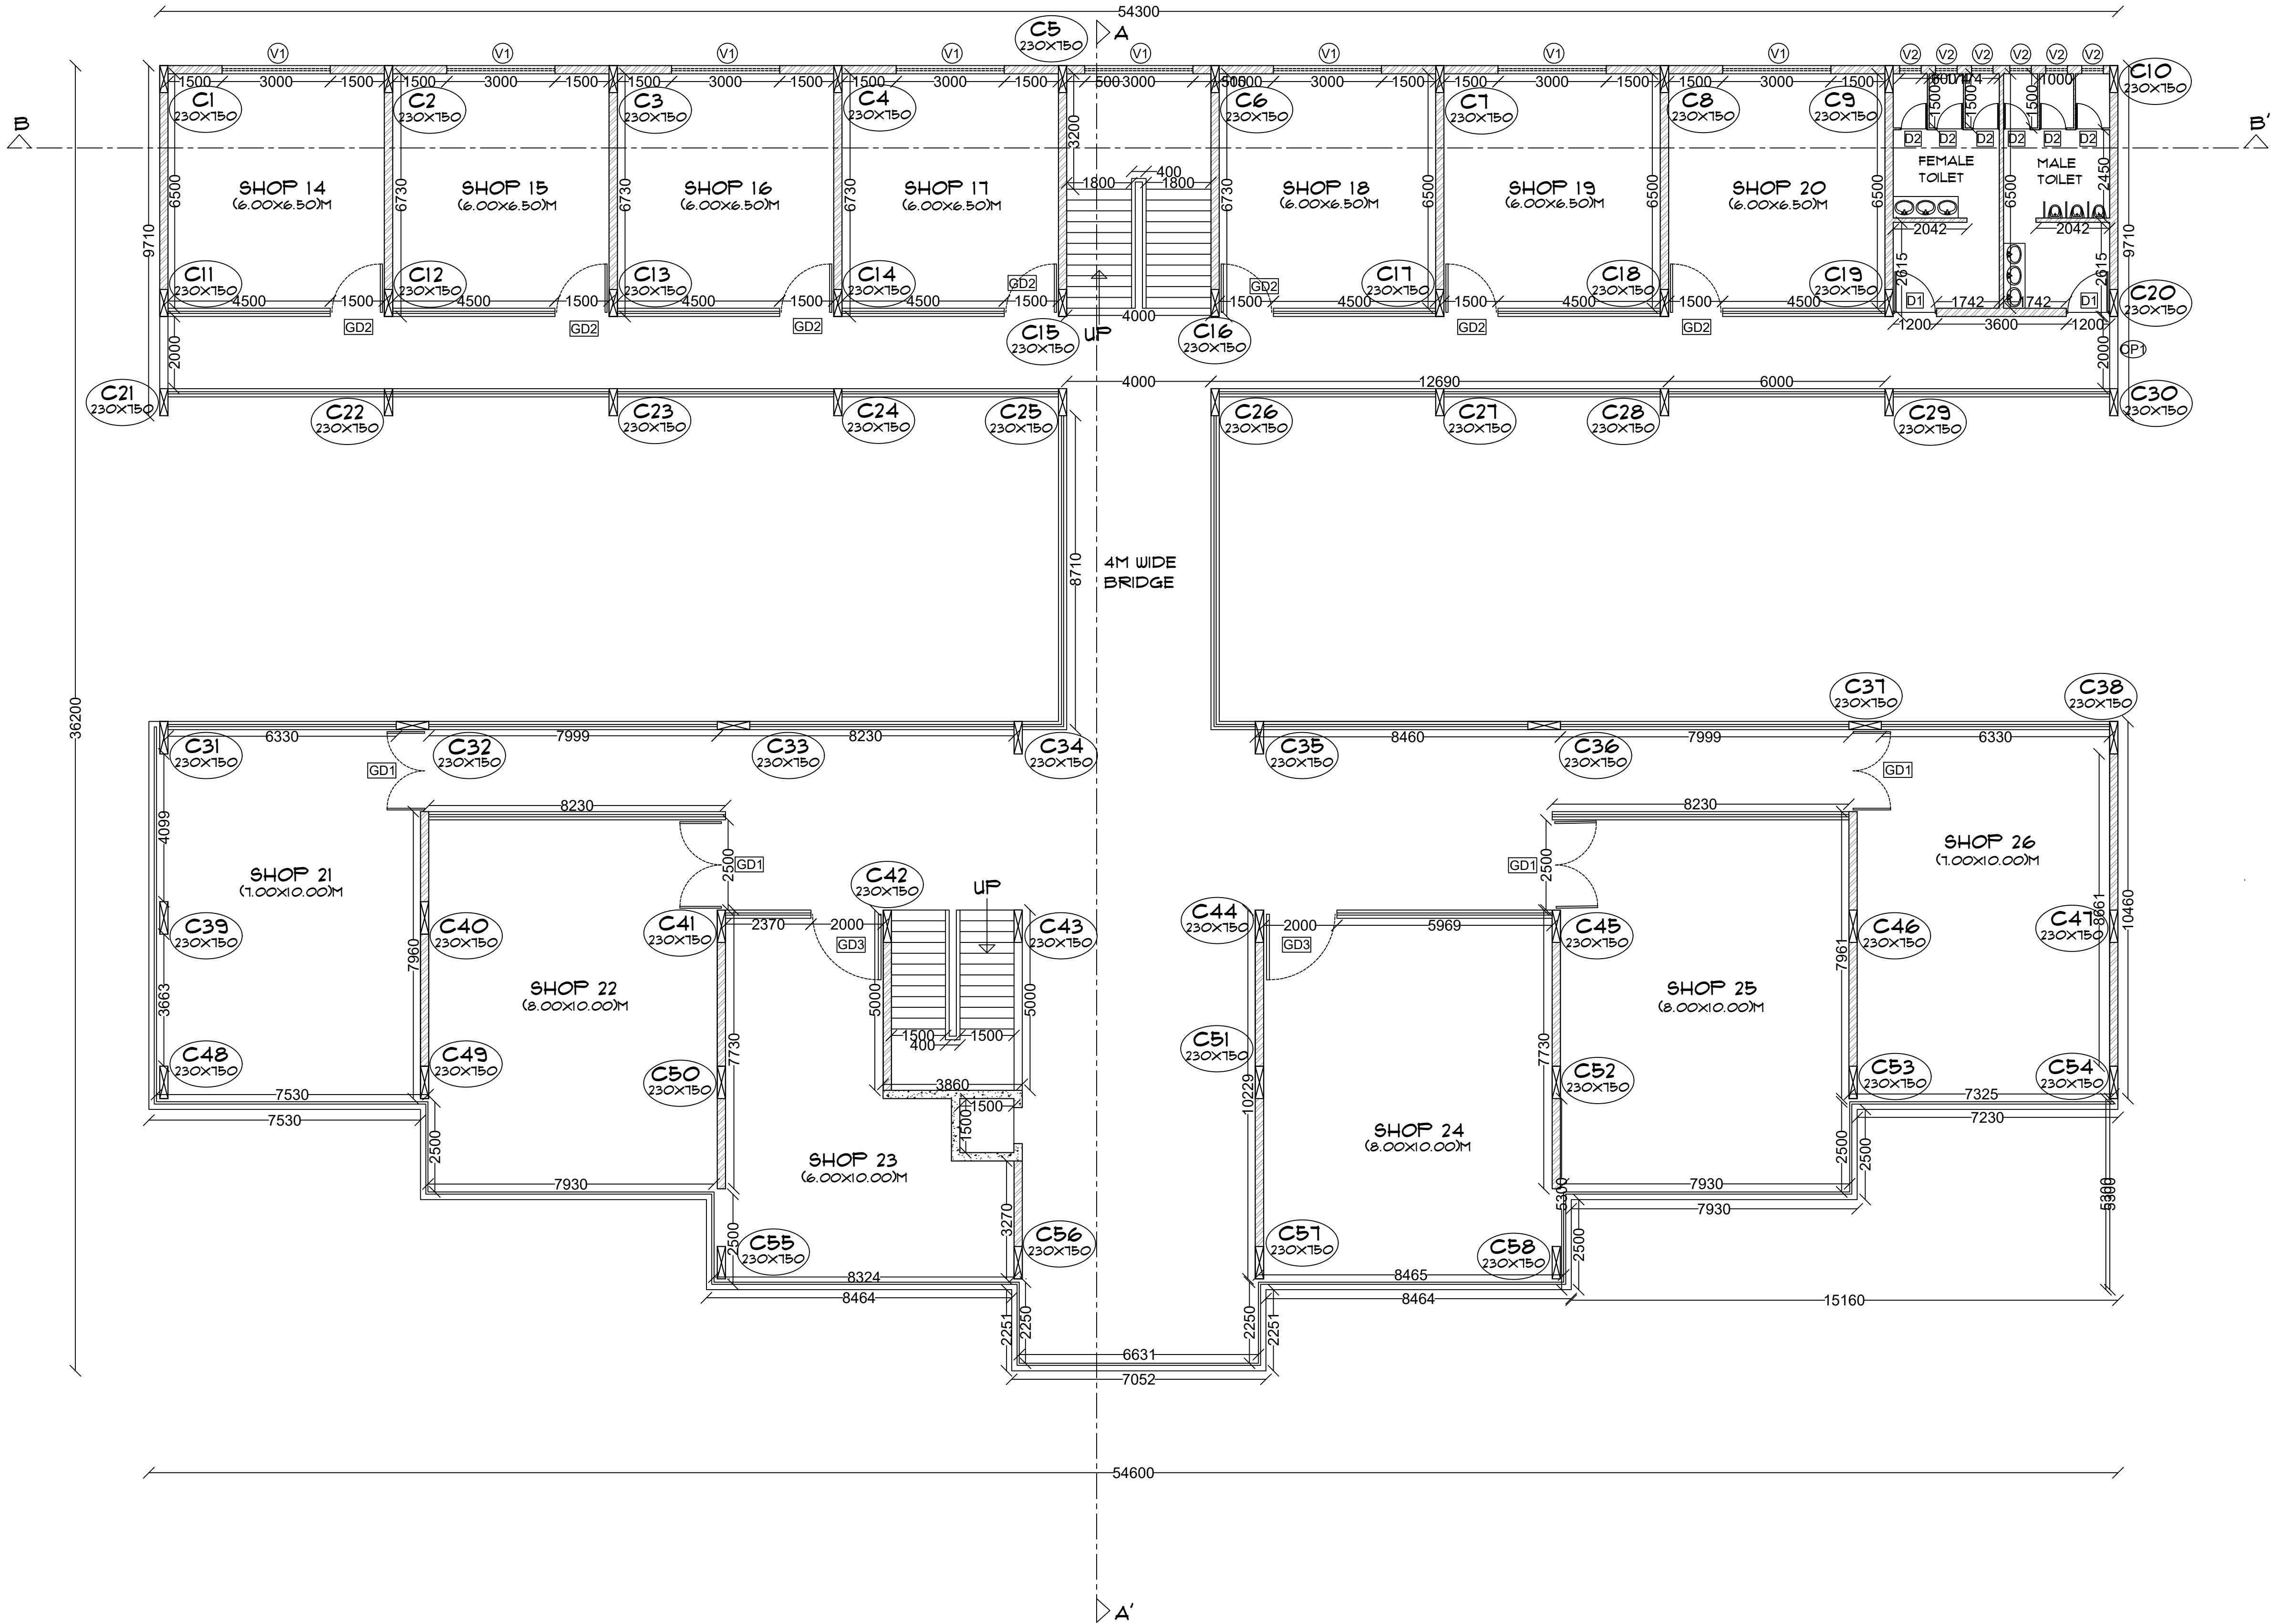


FIRST FOOR PLAN

SCALE - 1:100



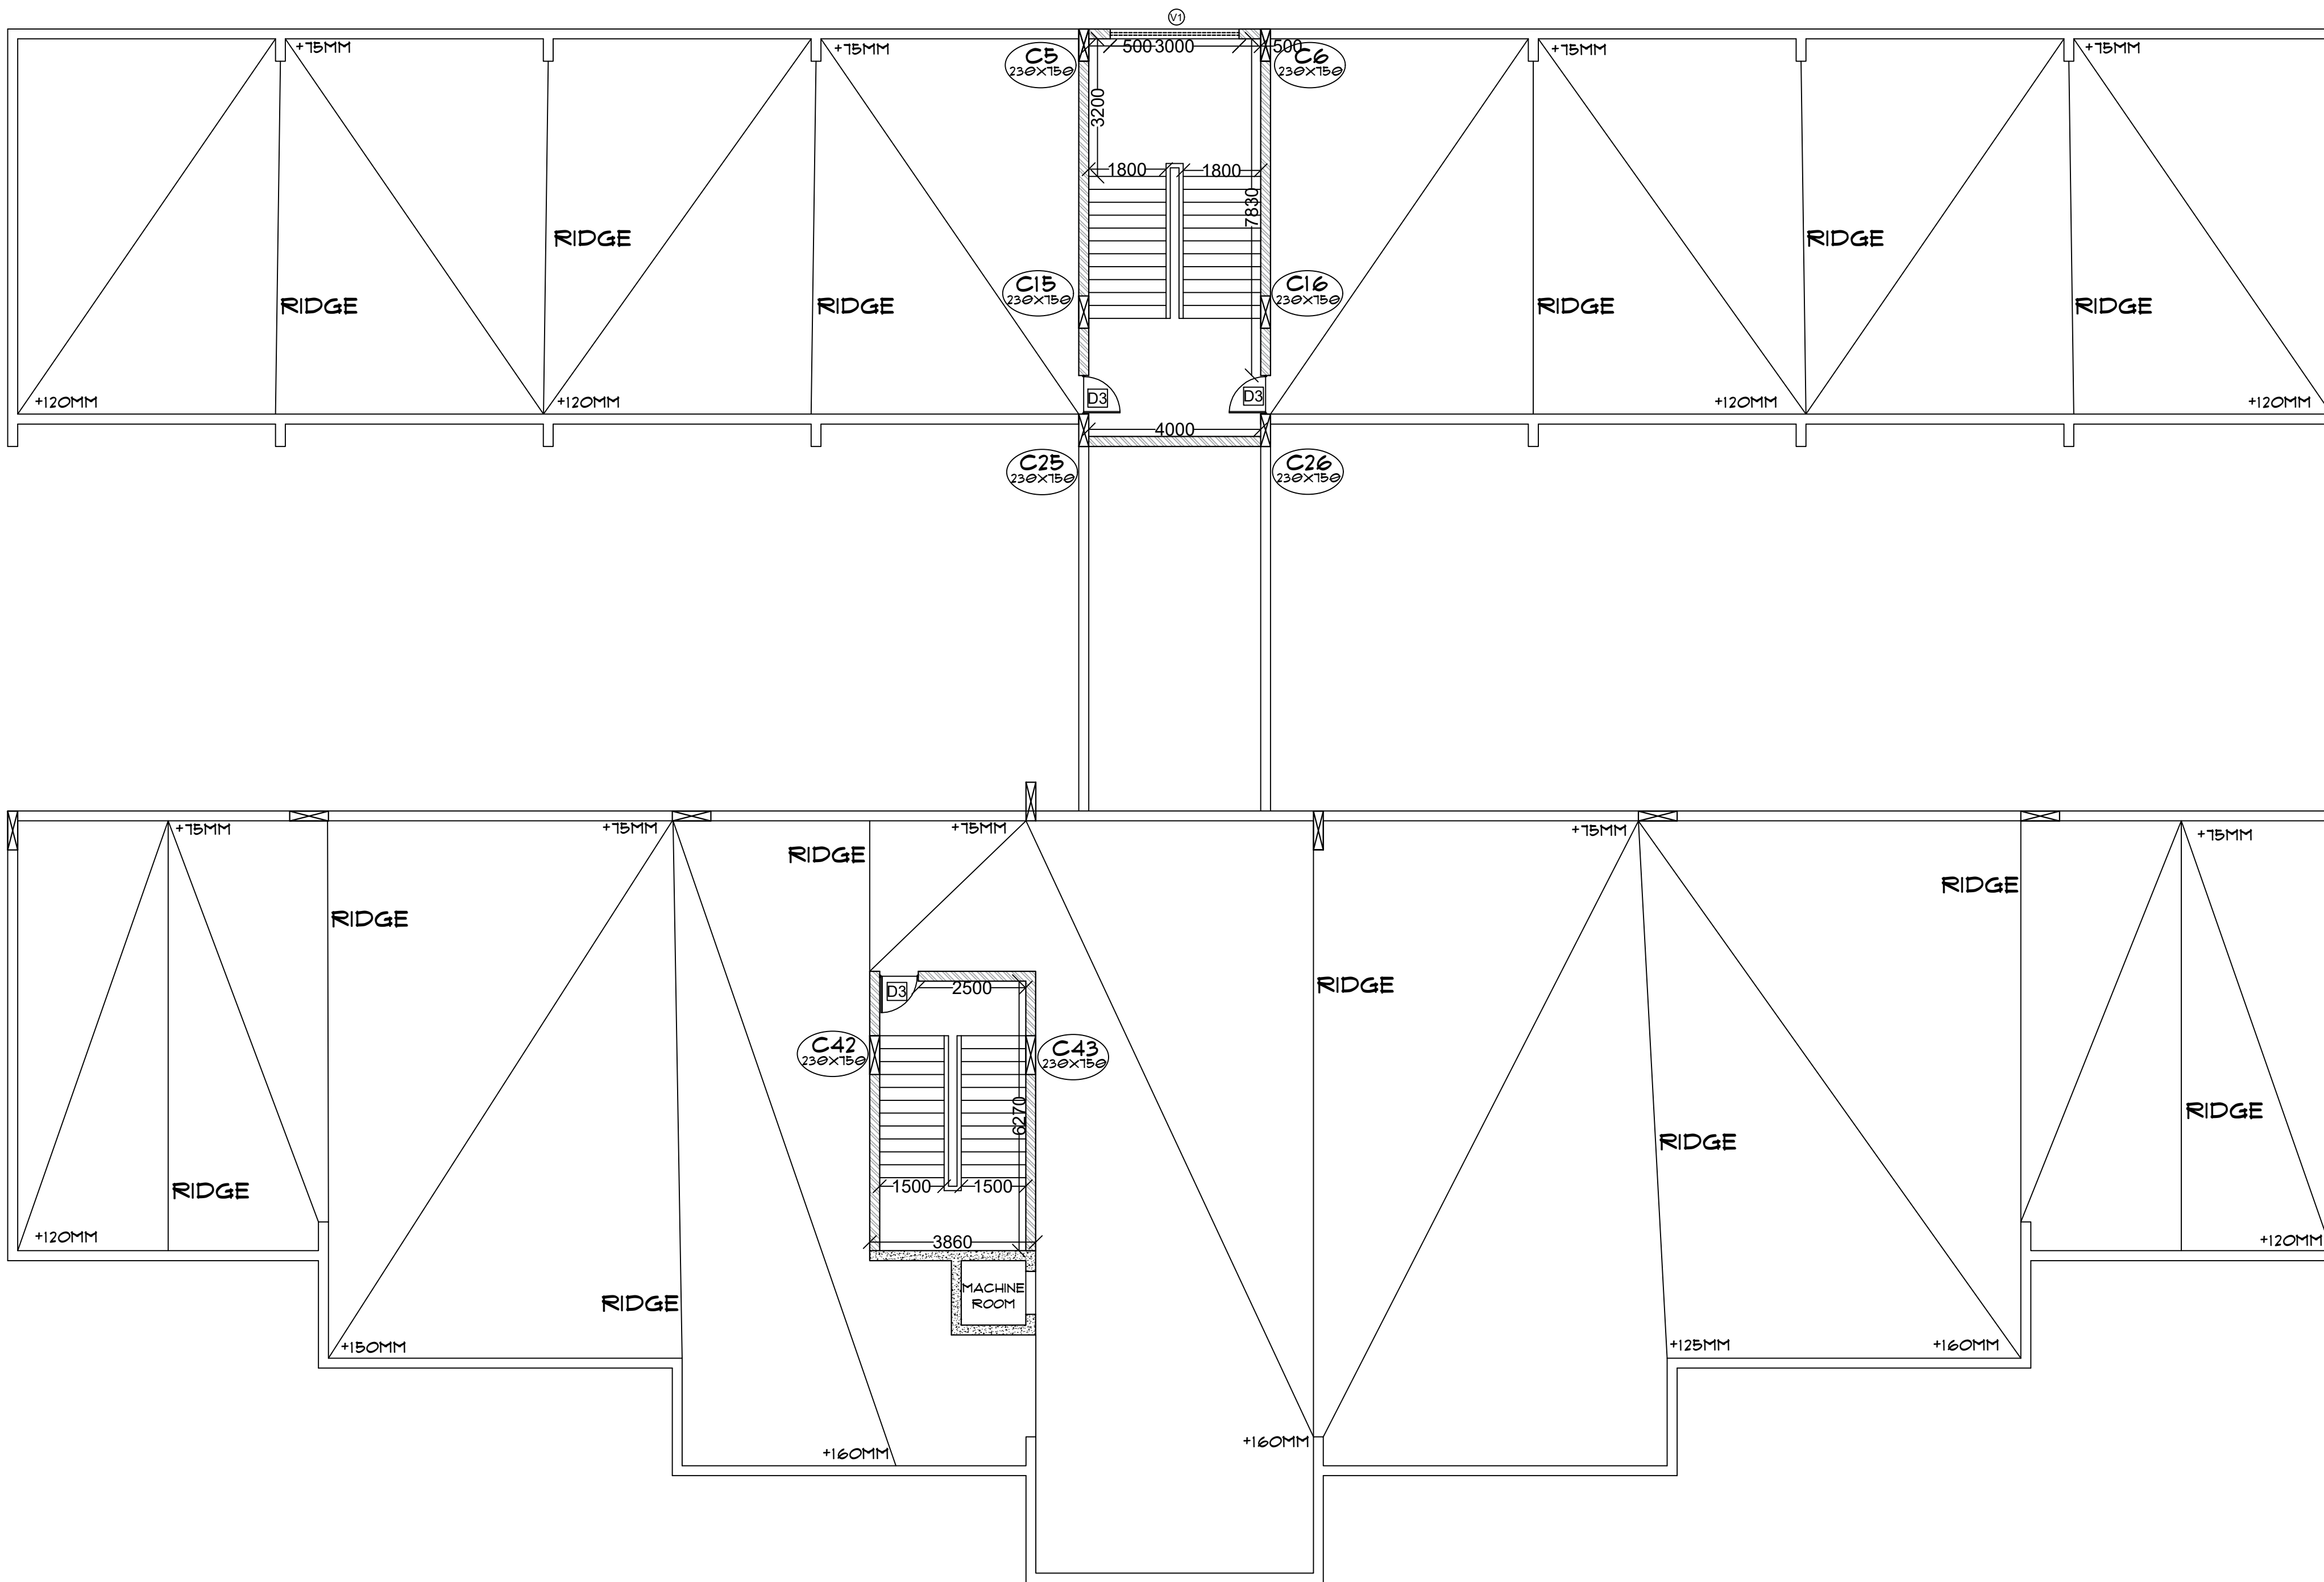

TERRACE FOOR PLAN
SCALE - 1:100

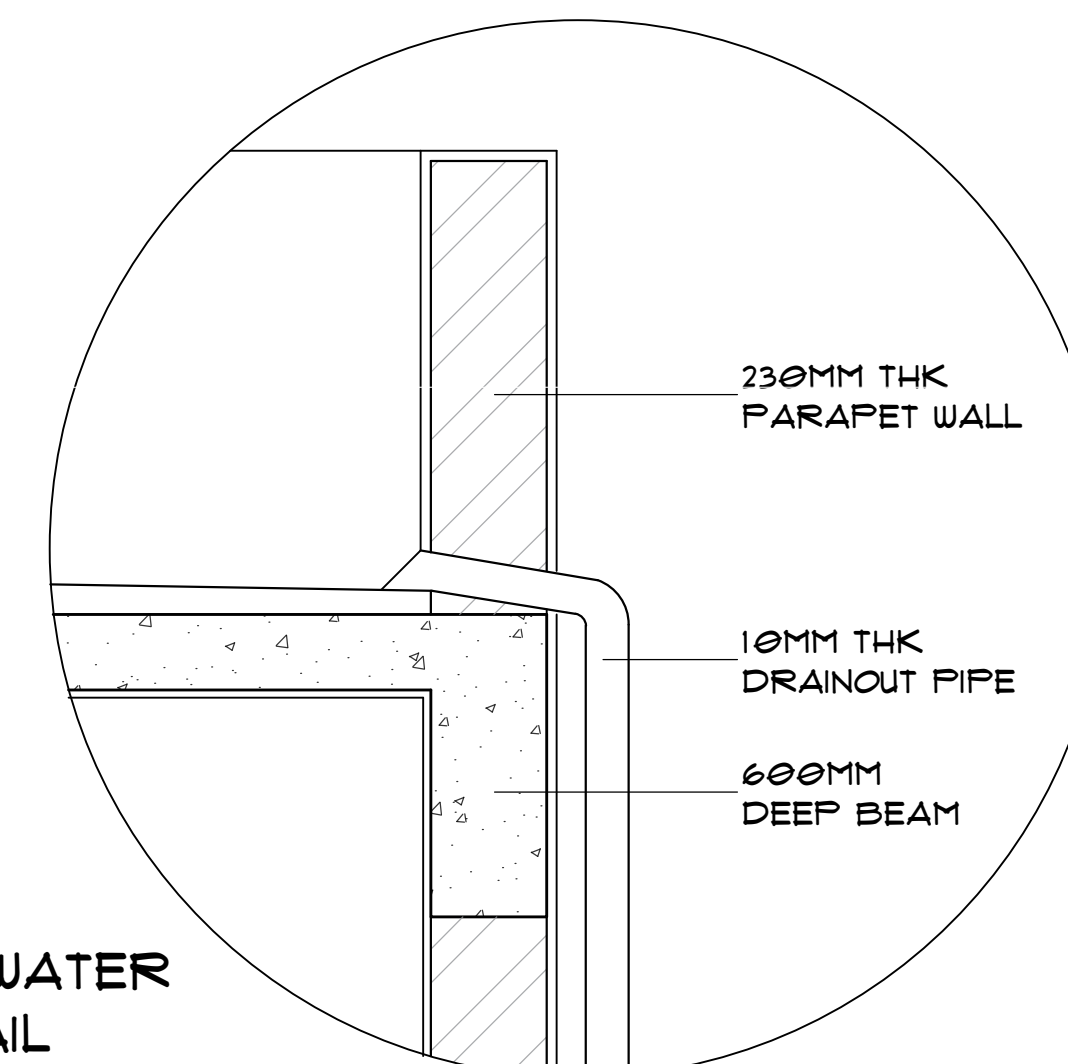

TERRACE RAINWATER
DRAINOUT DETAIL
SCALE - 1:15

PROFORMA -
WORKING DRAWING - II
SHEET TITLE -

TERRACE FLOOR PLAN

NOTES -

- 1) ALL DIMENSIONS ARE IN MM UNTIL SPECIFIED.
- 2) DO NOT MEASURE DRAWING, FOLLOW WRITTEN DIMENSIONS ONLY.
- 3) PLEASE REFER TO THE ARCHITECT IN CONCERN TO ANY QUERY OR DRAWING.
- 4) THIS DRAWING IS A PROPERTY OF THE ARCHITECT AND SHALL NOT BE REPRODUCED OR USED WITHOUT THEIR WRITTEN PERMISSION.

SCALE -	DATE -	REV NO. -
1 : 100	10/10/2024	
DRAWN BY -	CHECKED BY -	
YK	AR NS	

PROJECT -

PROPOSED SHOPPING COMPLEX AT SOLAPUR

ARCHITECT -

VAISHNAVI G. KARBHARI.
ROLL NO. - 55M/21/08
4TH YR, SEM VII (B.ARCH)
555M'S COLLEGE OF
ARCHITECTURE, SOLAPUR.

SIGN AND STAMP -

PROFORMA -

WORKING DRAWING - II

SHEET TITLE -

SECTIONS

NOTES -

- 1) ALL DIMENSIONS ARE IN MM UNTIL SPECIFIED.
2) DO NOT MEASURE DRAWING, FOLLOW WRITTEN DIMENSIONS ONLY.
3) PLEASE REFER TO THE ARCHITECT IN CONCERN TO ANY QUERY OR DRAWING.
4) THIS DRAWING IS A PROPERTY OF THE ARCHITECT AND SHALL NOT BE REPRODUCED OR USED WITHOUT THEIR WRITTEN PERMISSION.

SCALE -

DATE -

REV NO. -

1 : 100


05/11/2024

DRAWN BY -

CHECKED BY -

VK

AR NS

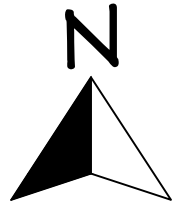


PROJECT -

PROPOSED
SHOPPING COMPLEX
AT SOLAPUR


ARCHITECT -

VAISHNAVI G. KARBHARI.
ROLL NO. - 99M/21/08
4TH YR, SEM VII (B.ARCH)
99M'S COLLEGE OF
ARCHITECTURE, SOLAPUR.

SIGN AND STAMP -

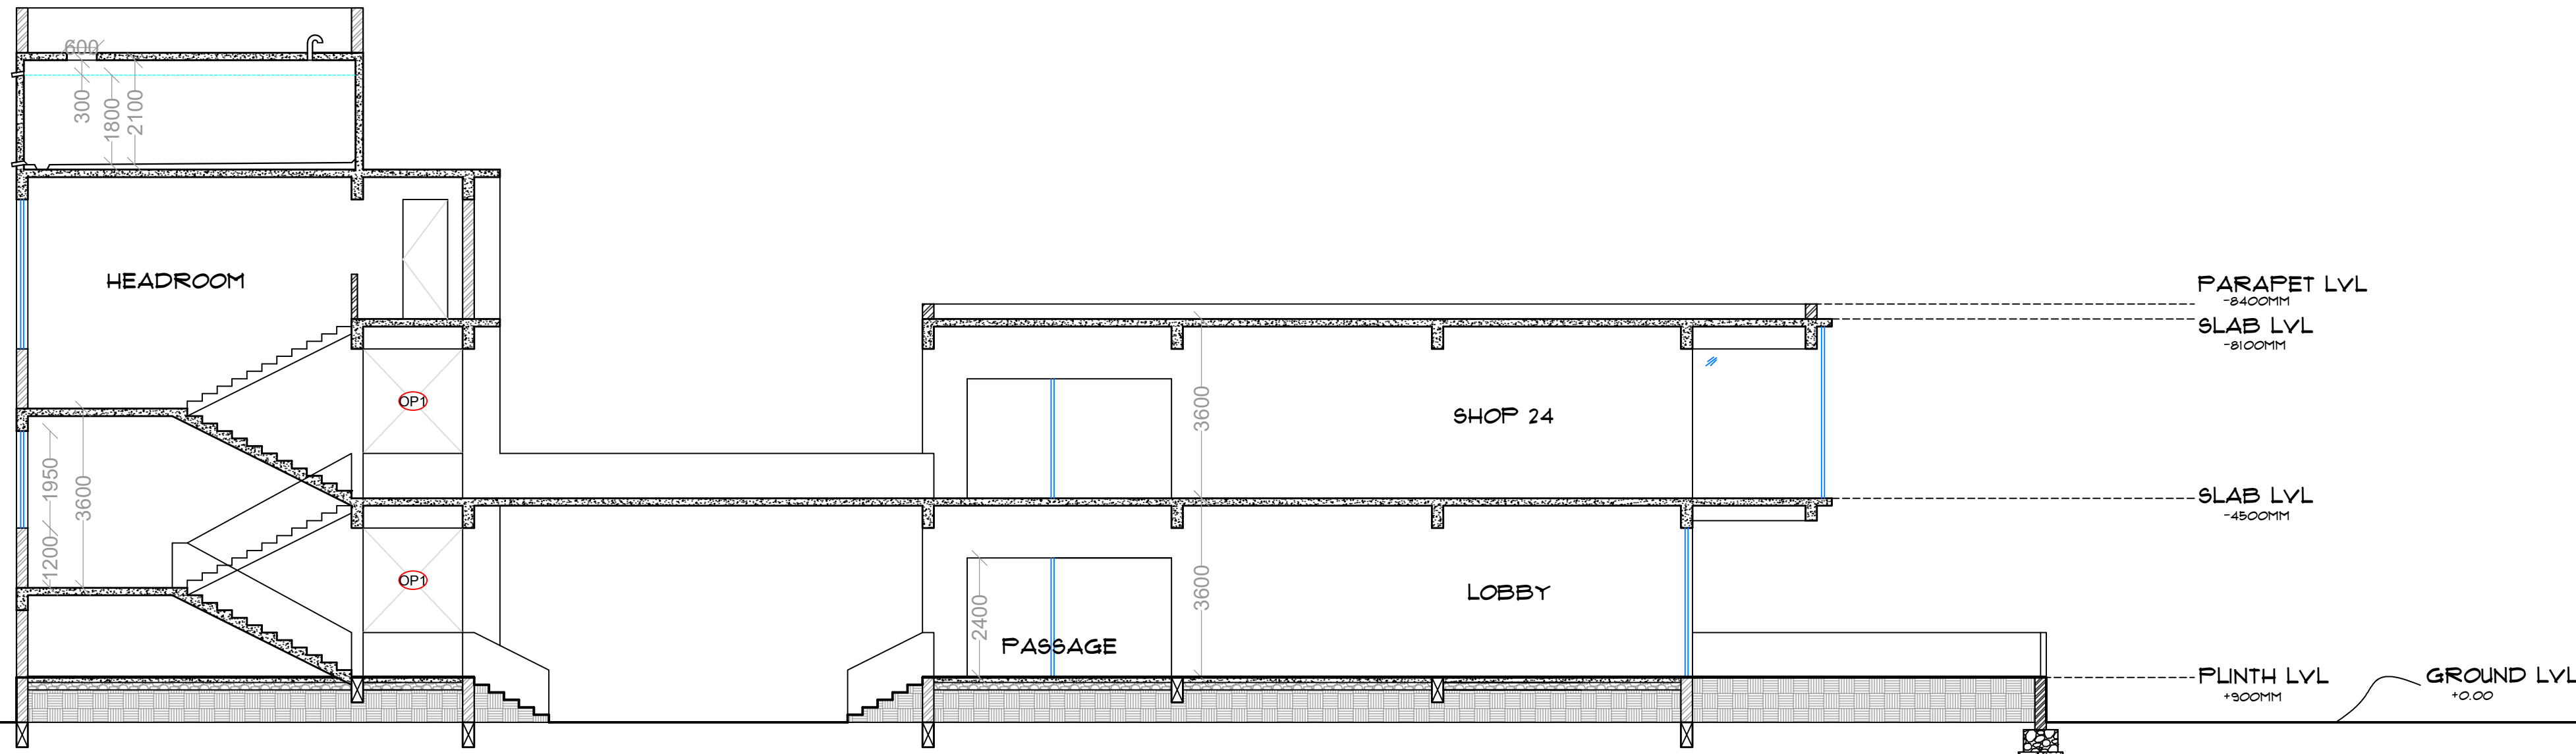

SECTION AA'
SCALE - 1:100

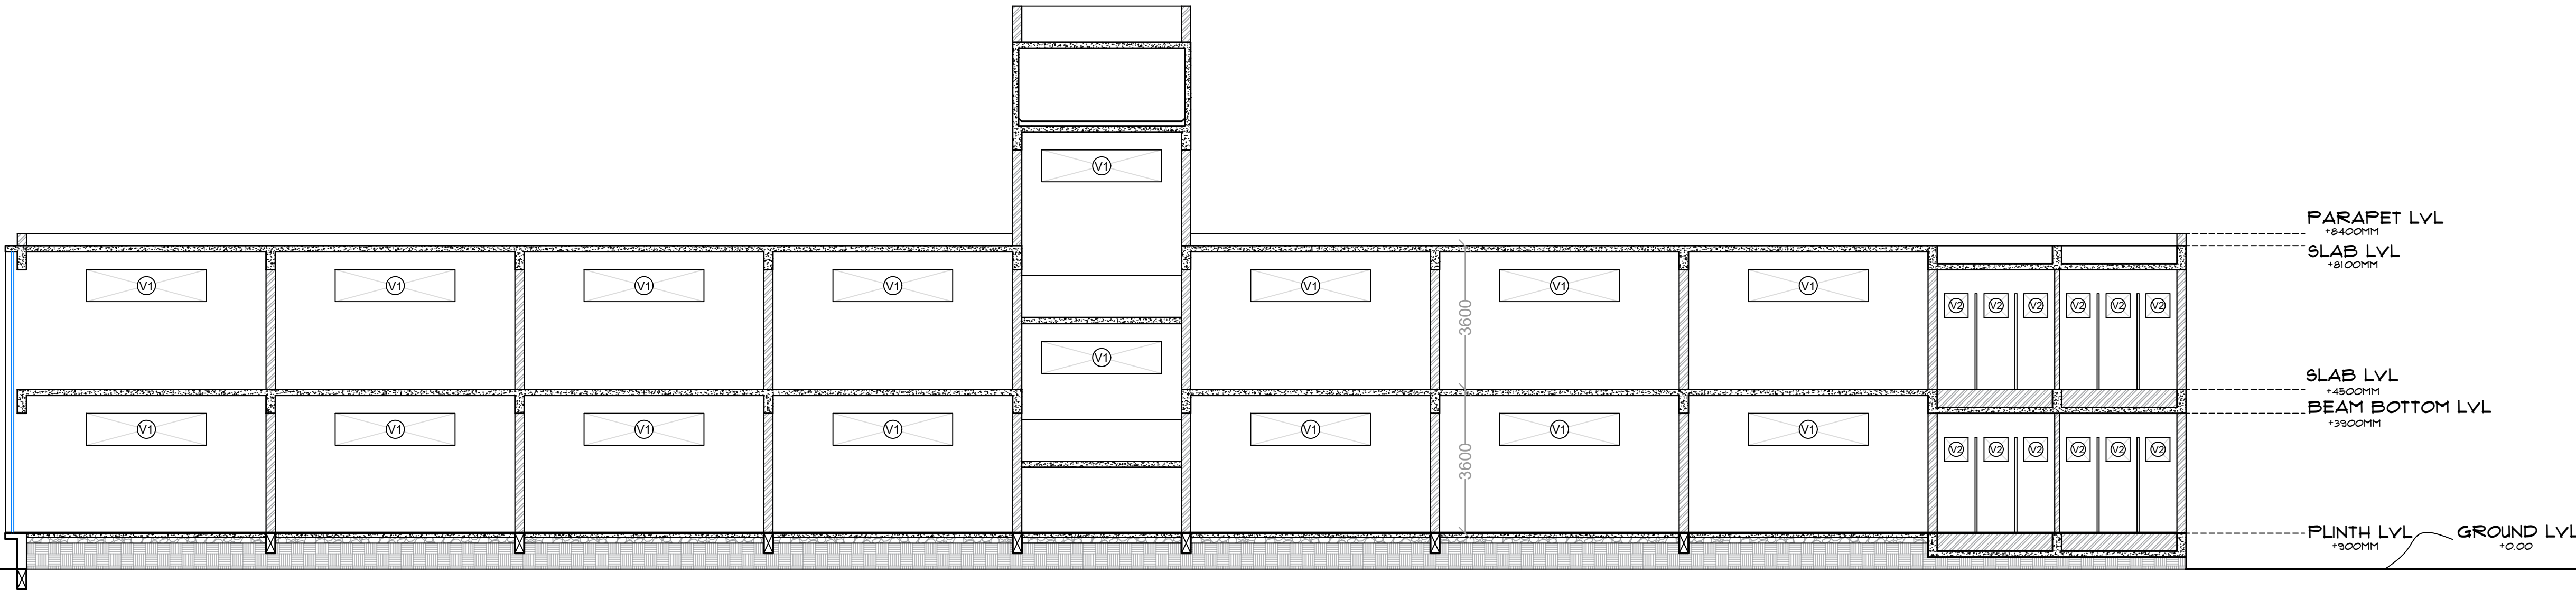

SECTION BB'
SCALE - 1:100

PROFORMA -

WORKING DRAWING - II

SHEET TITLE -

ELEVATIONS

NOTES -

- 1) ALL DIMENSIONS ARE IN MM UNTIL SPECIFIED.
- 2) DO NOT MEASURE DRAWING, FOLLOW WRITTEN DIMENSIONS ONLY.
- 3) PLEASE REFER TO THE ARCHITECT IN CONCERN TO ANY QUERY OR DRAWING.
- 4) THIS DRAWING IS A PROPERTY OF THE ARCHITECT AND SHALL NOT BE REPRODUCED OR USED WITHOUT THEIR WRITTEN PERMISSION.

SCALE -

DATE -

REV NO. -

1 : 100

10/10/2024

DRAWN BY -

CHECKED BY -

YK

AR NS


PROJECT -

PROPOSED
SHOPPING COMPLEX
AT SOLAPUR

ARCHITECT -


VAISHNAVI G. KARBHARI.
ROLL NO. - 99M/21/08
4TH YR, SEM VII (B.ARCH)
99M'S COLLEGE OF
ARCHITECTURE, SOLAPUR.

SIGN AND STAMP -

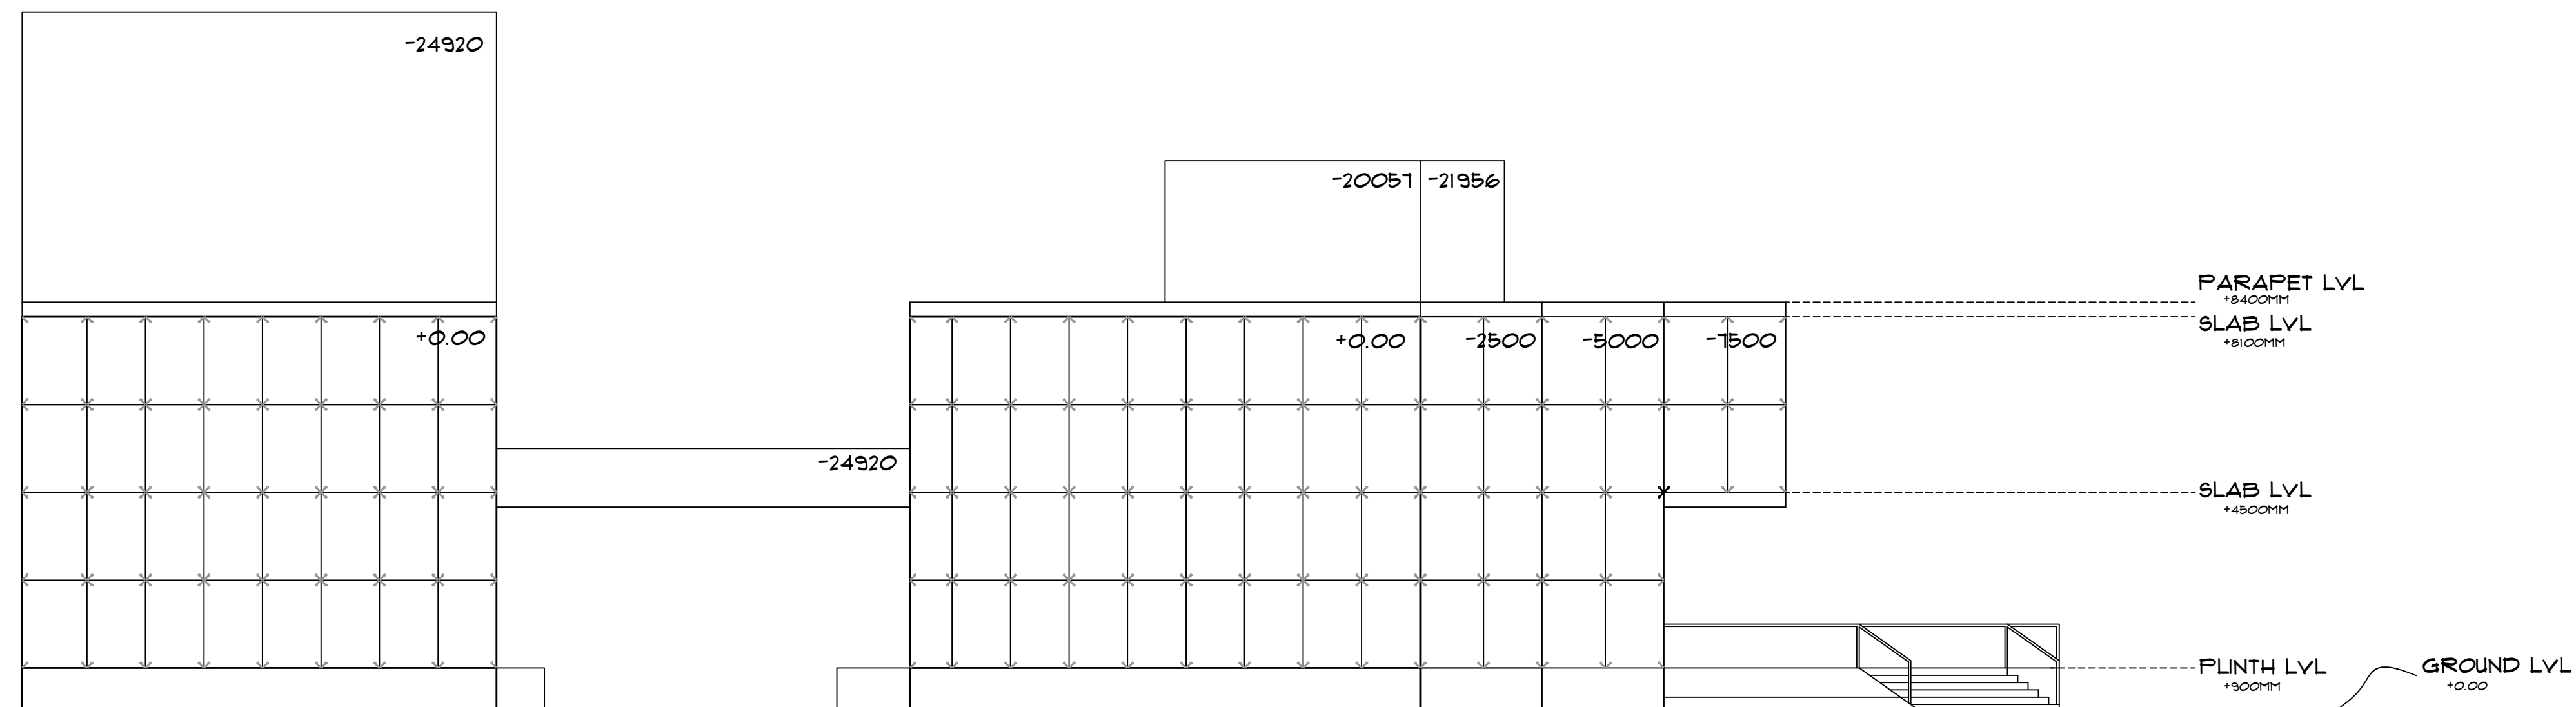


EAST-SIDE ELEVATION

SCALE - 1:100

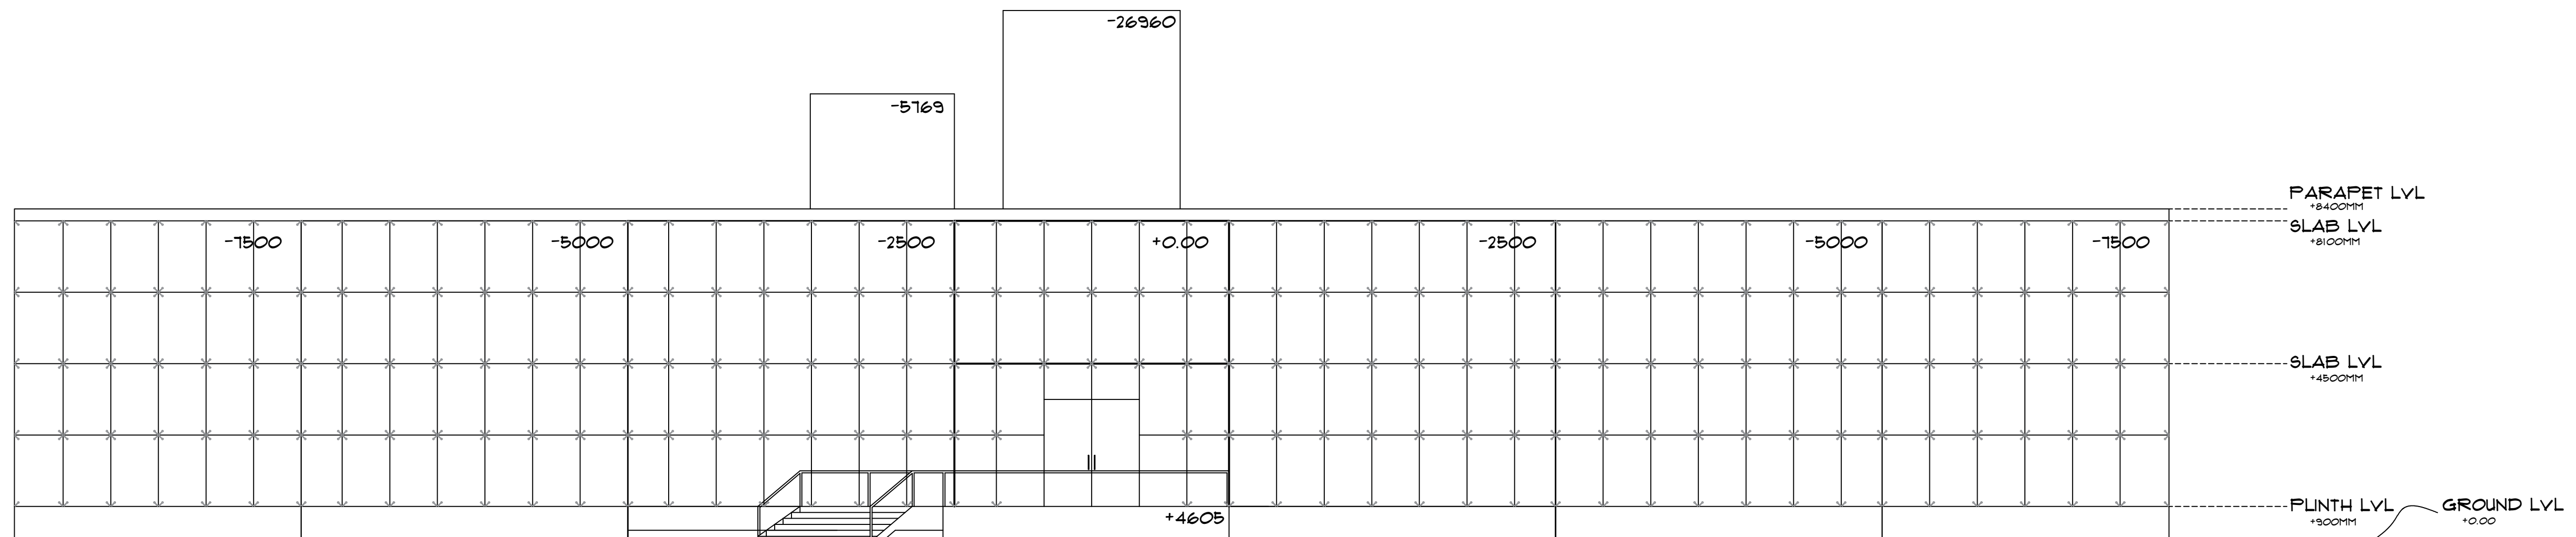


NORTH-SIDE ELEVATION

SCALE - 1:100

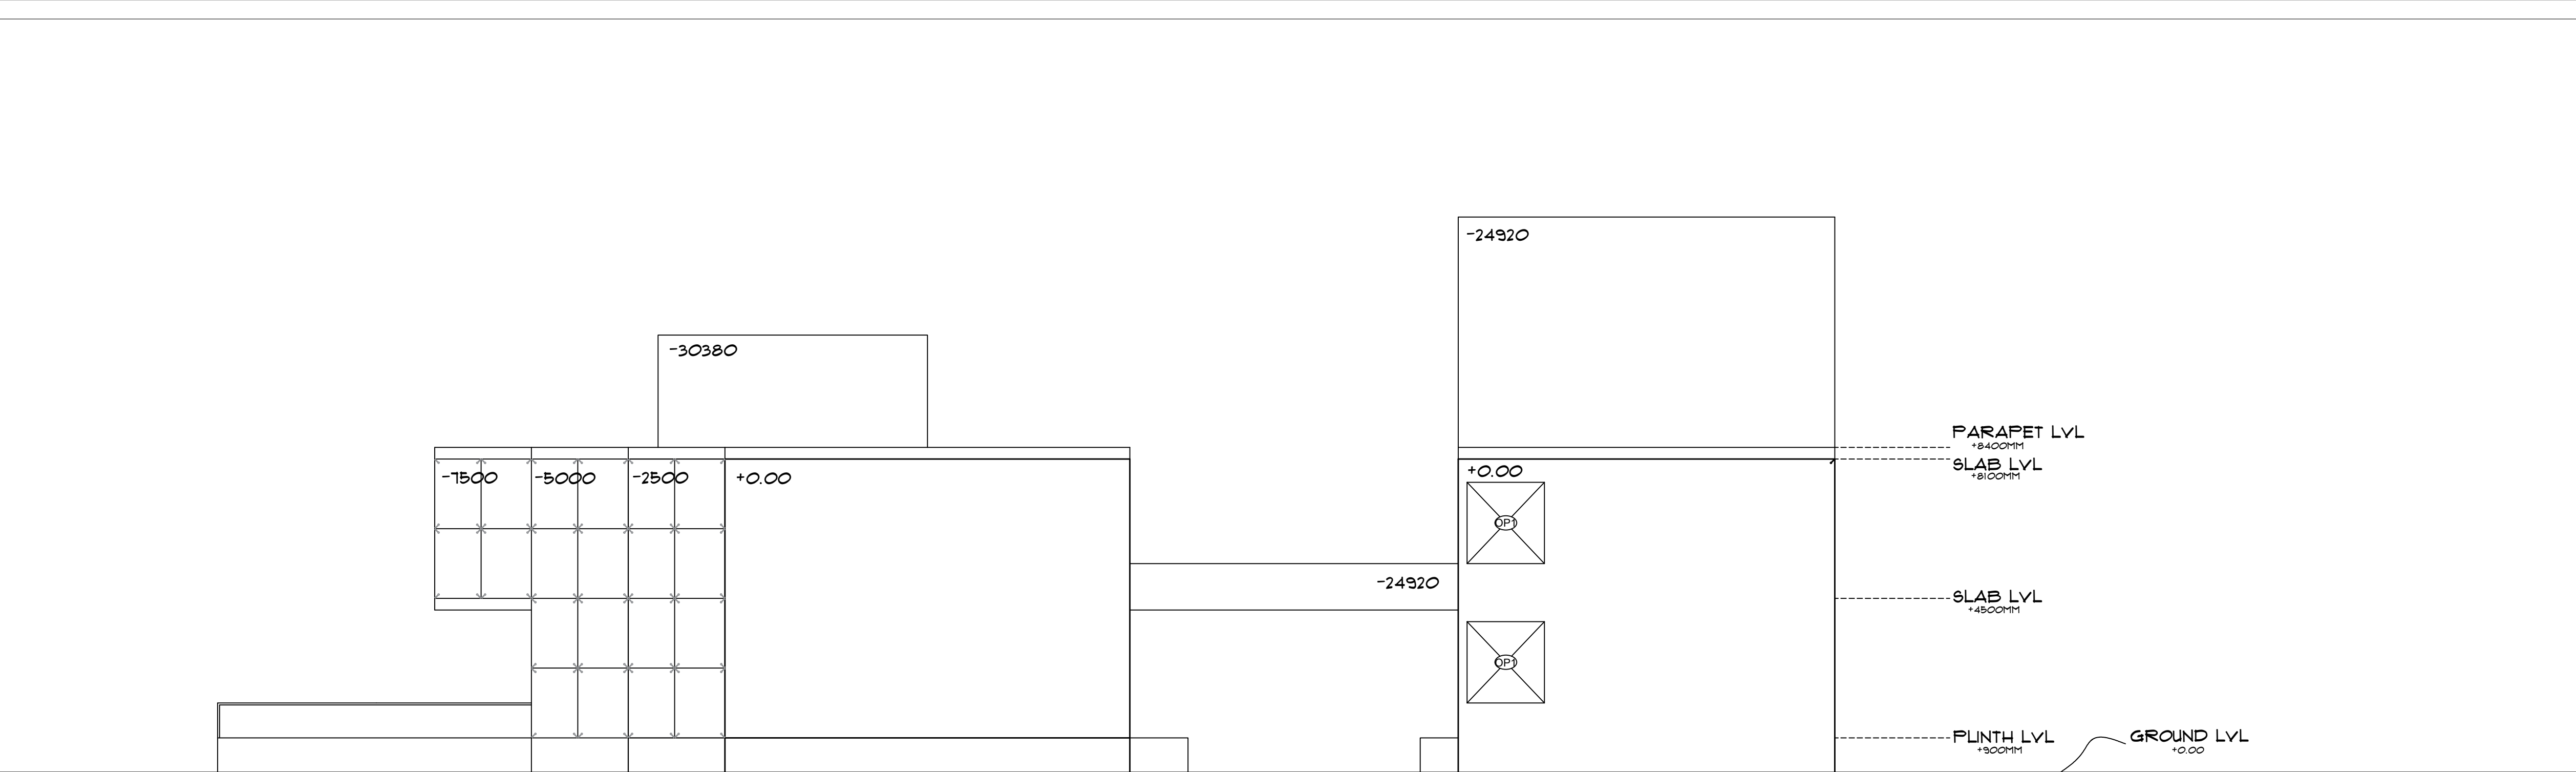

WEST-SIDE ELEVATION
SCALE - 1:100

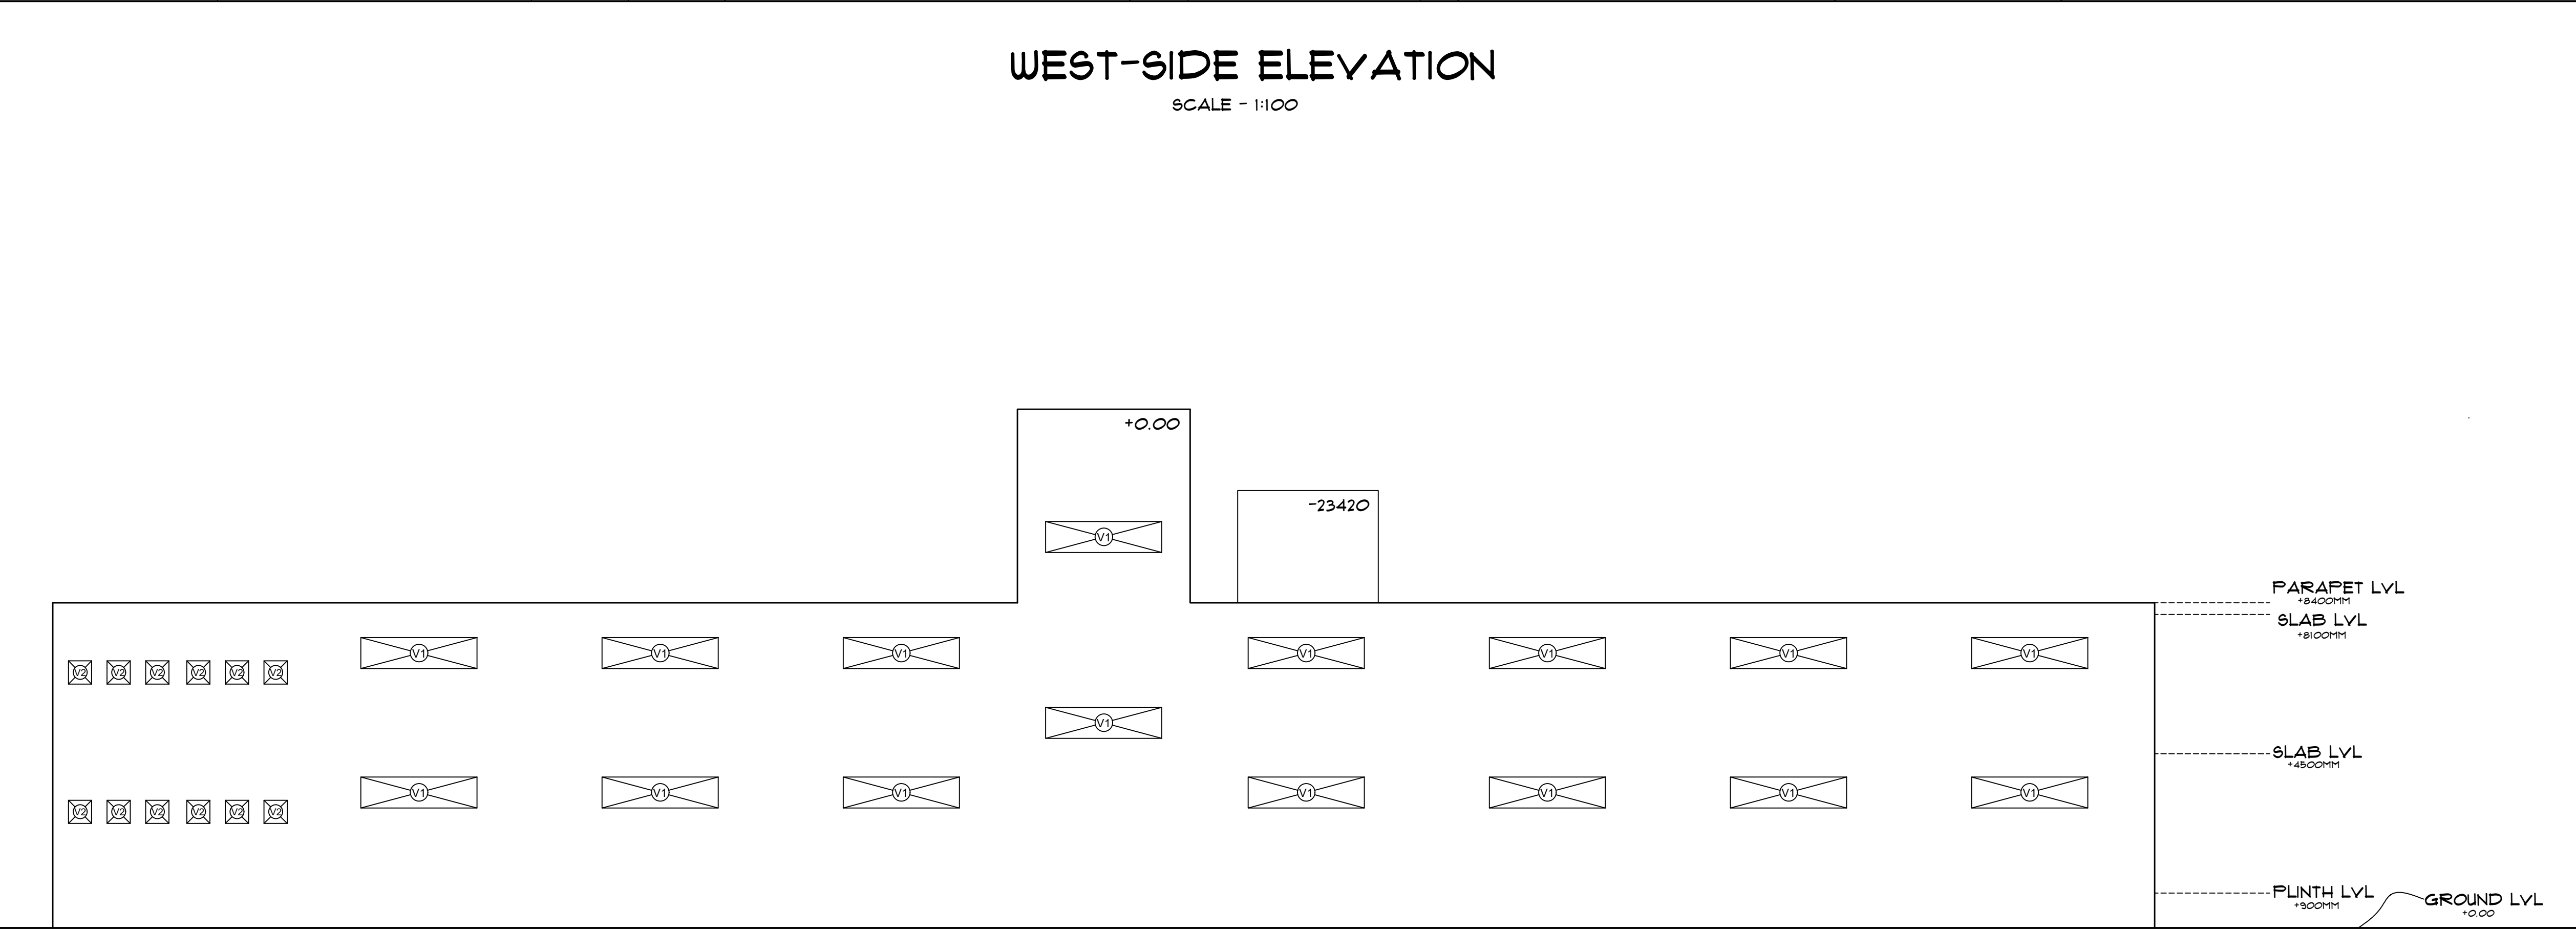

SOUTH-SIDE ELEVATION
SCALE - 1:100

PROFORMA -

WORKING DRAWING - II

SHEET TITLE -

ELEVATIONS

NOTES -

- 1) ALL DIMENSIONS ARE IN MM UNTIL SPECIFIED.
- 2) DO NOT MEASURE DRAWING, FOLLOW WRITTEN DIMENSIONS ONLY.
- 3) PLEASE REFER TO THE ARCHITECT IN CONCERN TO ANY QUERY OR DRAWING.
- 4) THIS DRAWING IS A PROPERTY OF THE ARCHITECT AND SHALL NOT BE REPRODUCED OR USED WITHOUT THEIR WRITTEN PERMISSION.

SCALE -

DATE -

REV NO. -

1 : 100

10/10/2024

DRAWN BY -

CHECKED BY -

YK

AR NS


PROJECT -

PROPOSED
SHOPPING COMPLEX
AT SOLAPUR

ARCHITECT -

VAISHNAVI G. KARBHARI.
ROLL NO. - 55M/21/08
4TH YR, SEM VII (B.ARCH)
555M'S COLLEGE OF
ARCHITECTURE, SOLAPUR.

SIGN AND STAMP -

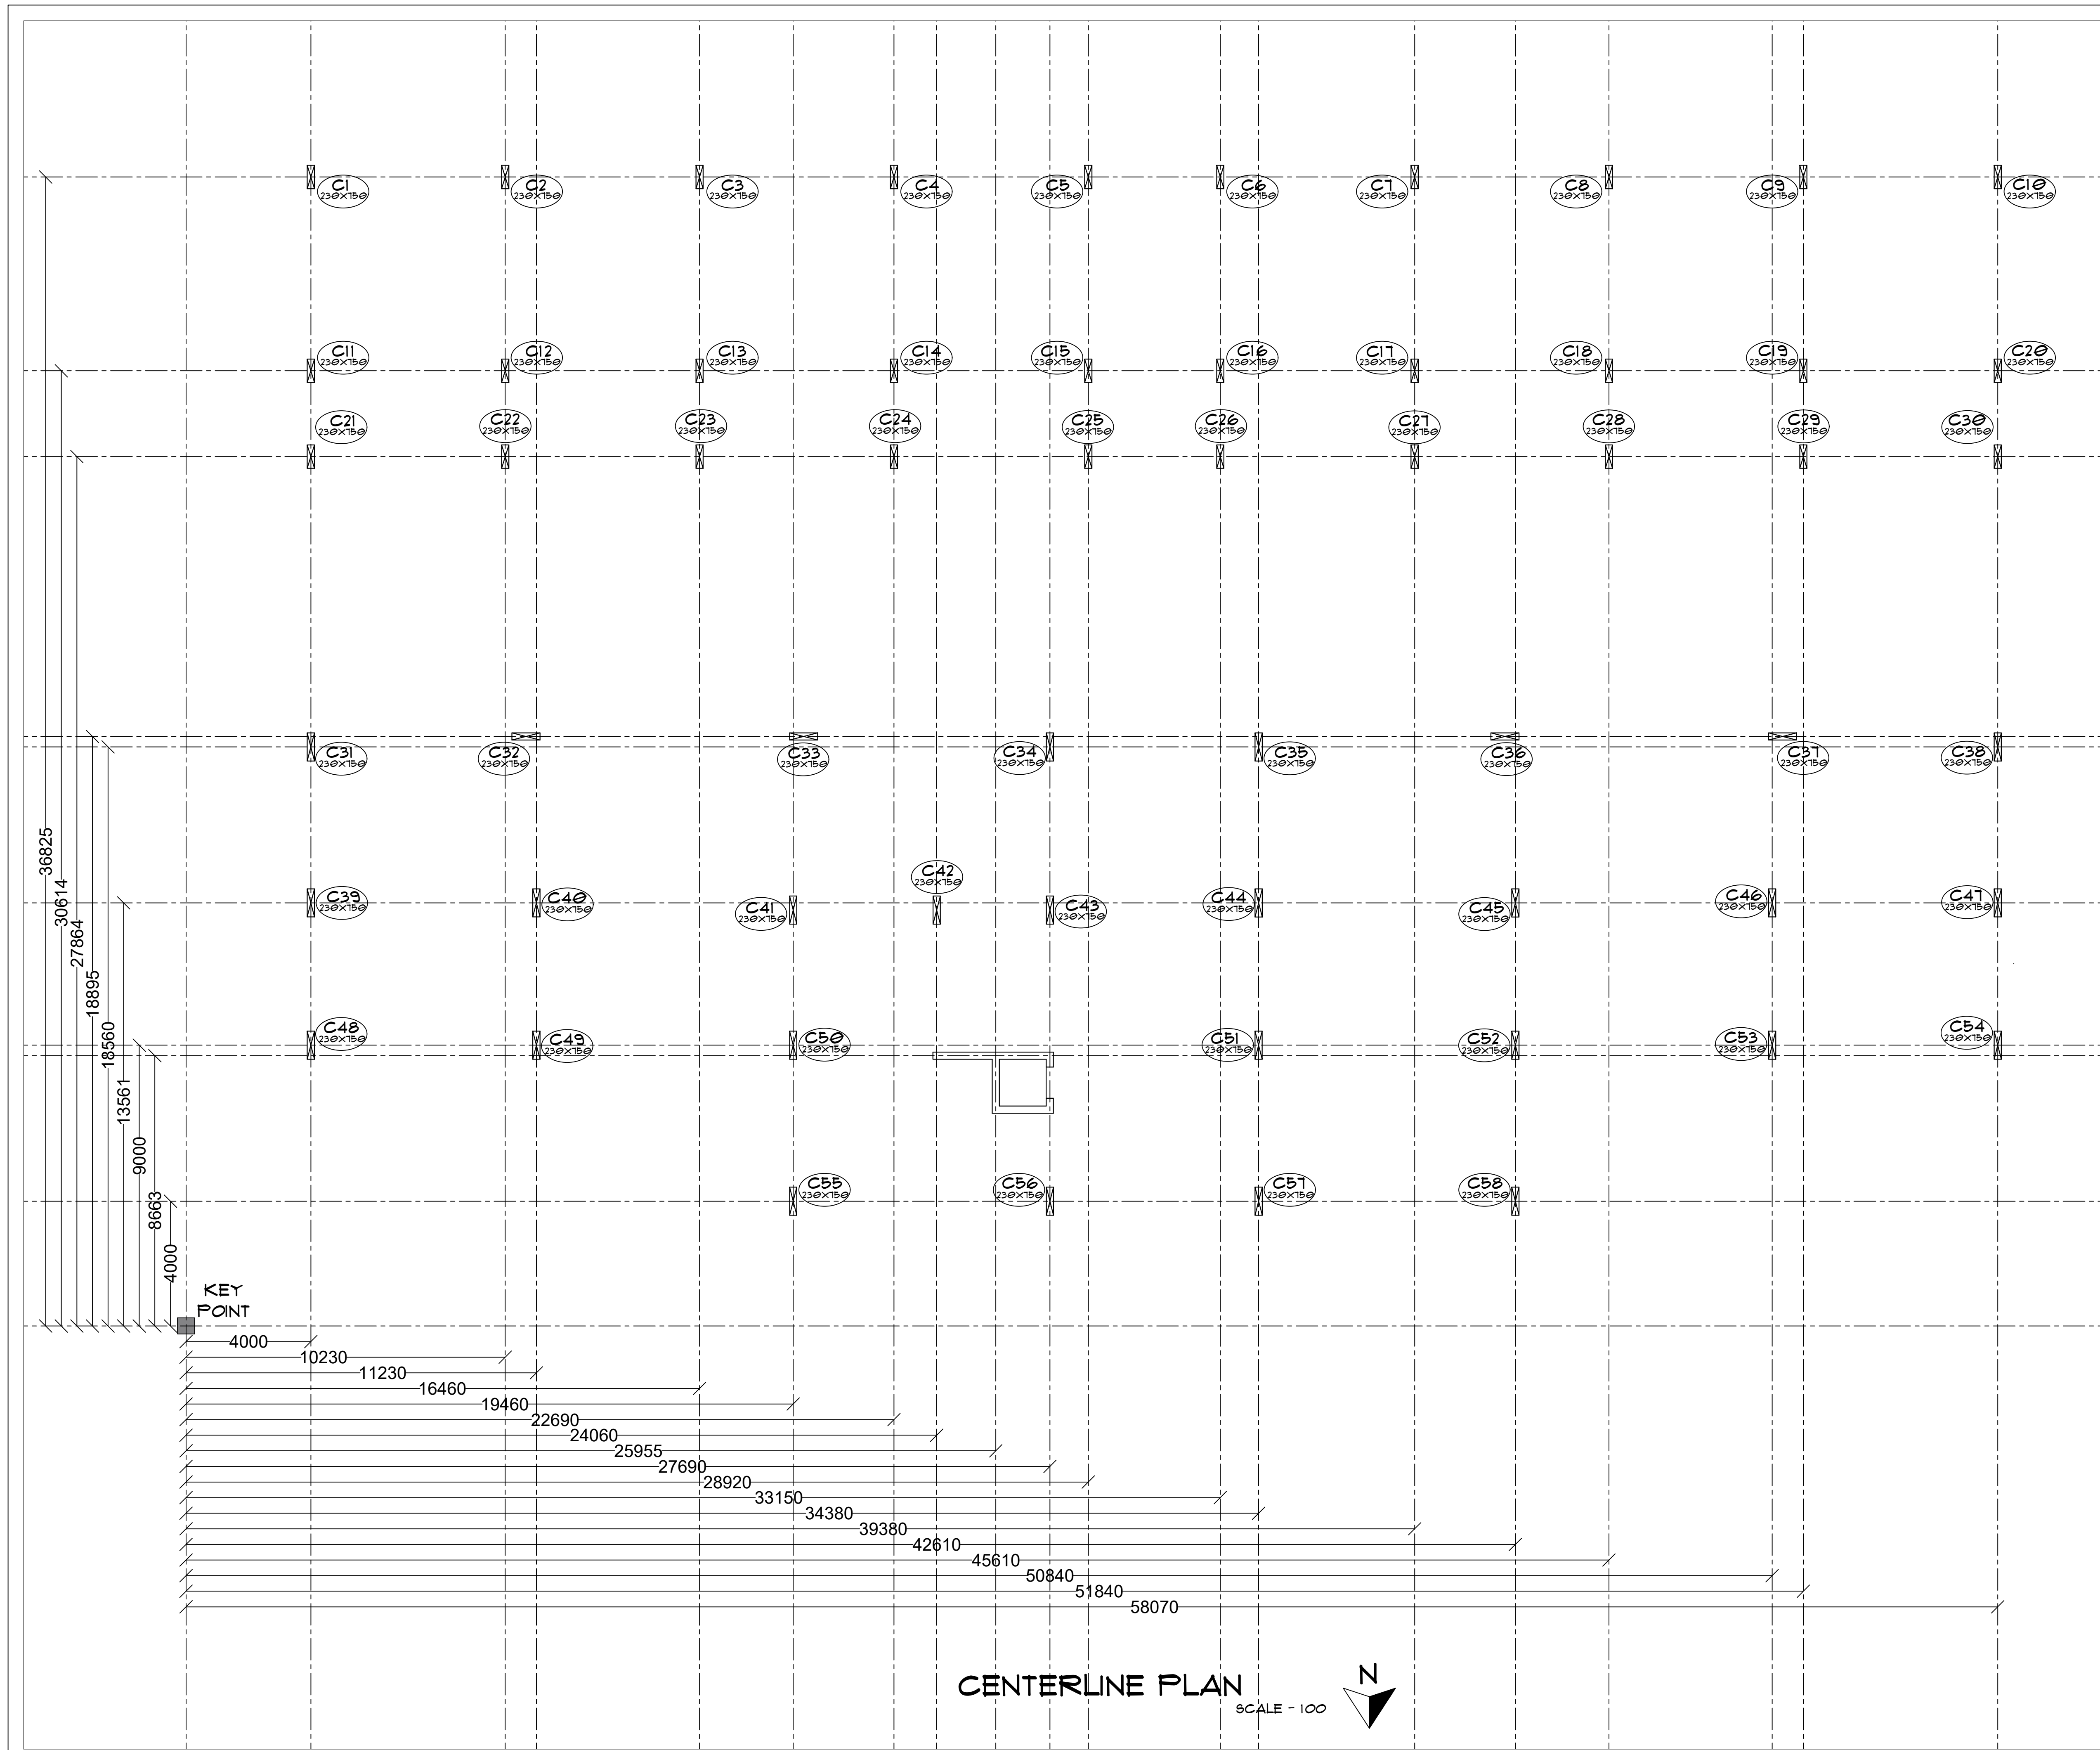


PROFORMA -

WORKING DRAWING - II

SHEET TITLE -

CENTERLINE PLAN

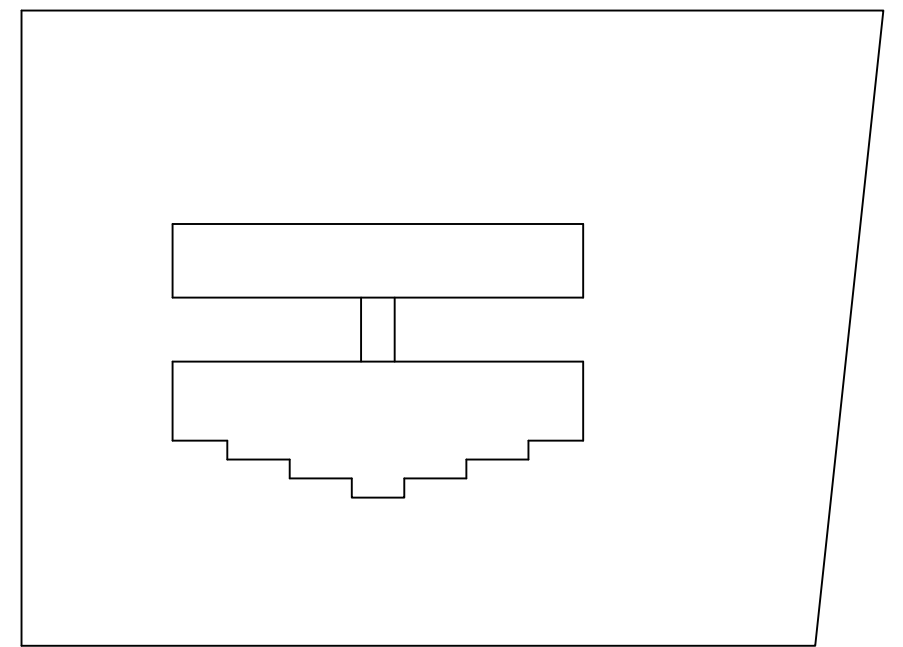

KEY BLOCK PLAN
SCALE - 1000

NOTES -

- 1) ALL DIMENSIONS ARE IN MM UNTIL SPECIFIED.
- 2) DO NOT MEASURE DRAWING, FOLLOW WRITTEN DIMENSIONS ONLY.
- 3) PLEASE REFER TO THE ARCHITECT IN CONCERN TO ANY QUERY OR DRAWING.
- 4) THIS DRAWING IS A PROPERTY OF THE ARCHITECT AND SHALL NOT BE REPRODUCED OR USED WITHOUT THEIR WRITTEN PERMISSION.

SCALE -	DATE -	REV NO. -
1 : 100	06/11/2024	
DRAWN BY -	CHECKED BY -	
VK	AR NS	



PROJECT -

PROPOSED
SHOPPING COMPLEX
AT SOLAPUR

ARCHITECT -


VAISHNAVI G. KARBHARI.
ROLL NO. - 99M/21/08
4TH YR, SEM VII (B.ARCH)
99M'S COLLEGE OF
ARCHITECTURE, SOLAPUR.

SIGN AND STAMP -

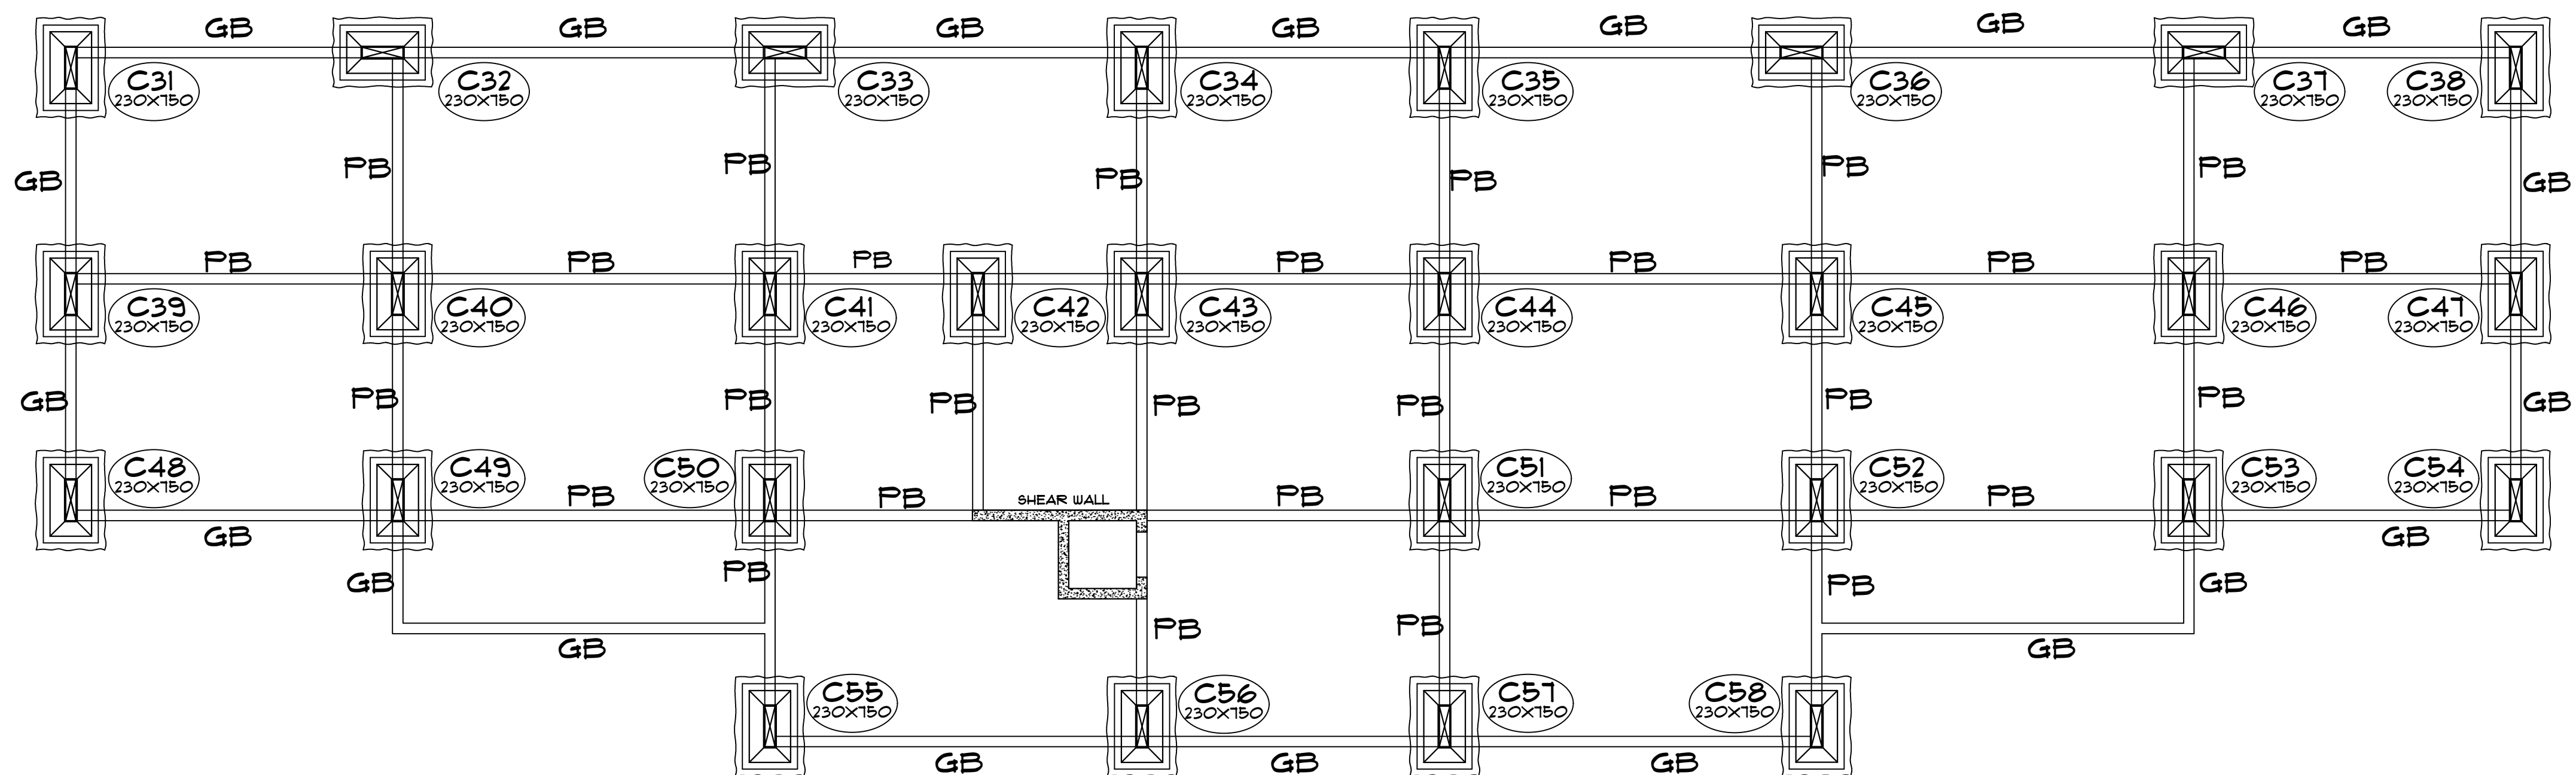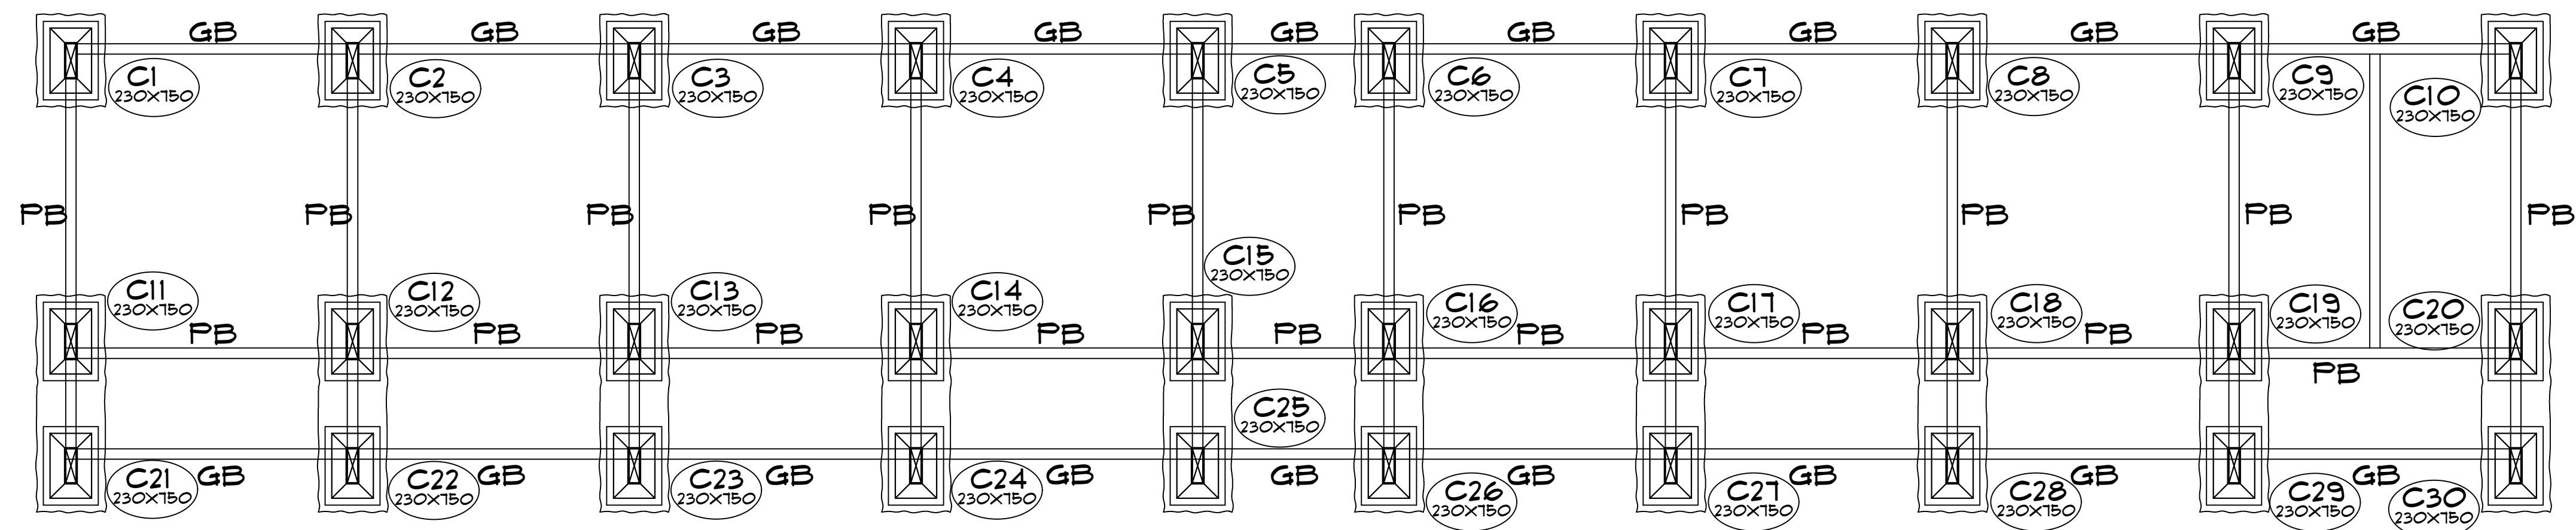


GROUND AND PLINTH BEAM PLAN

SCALE - 1:100

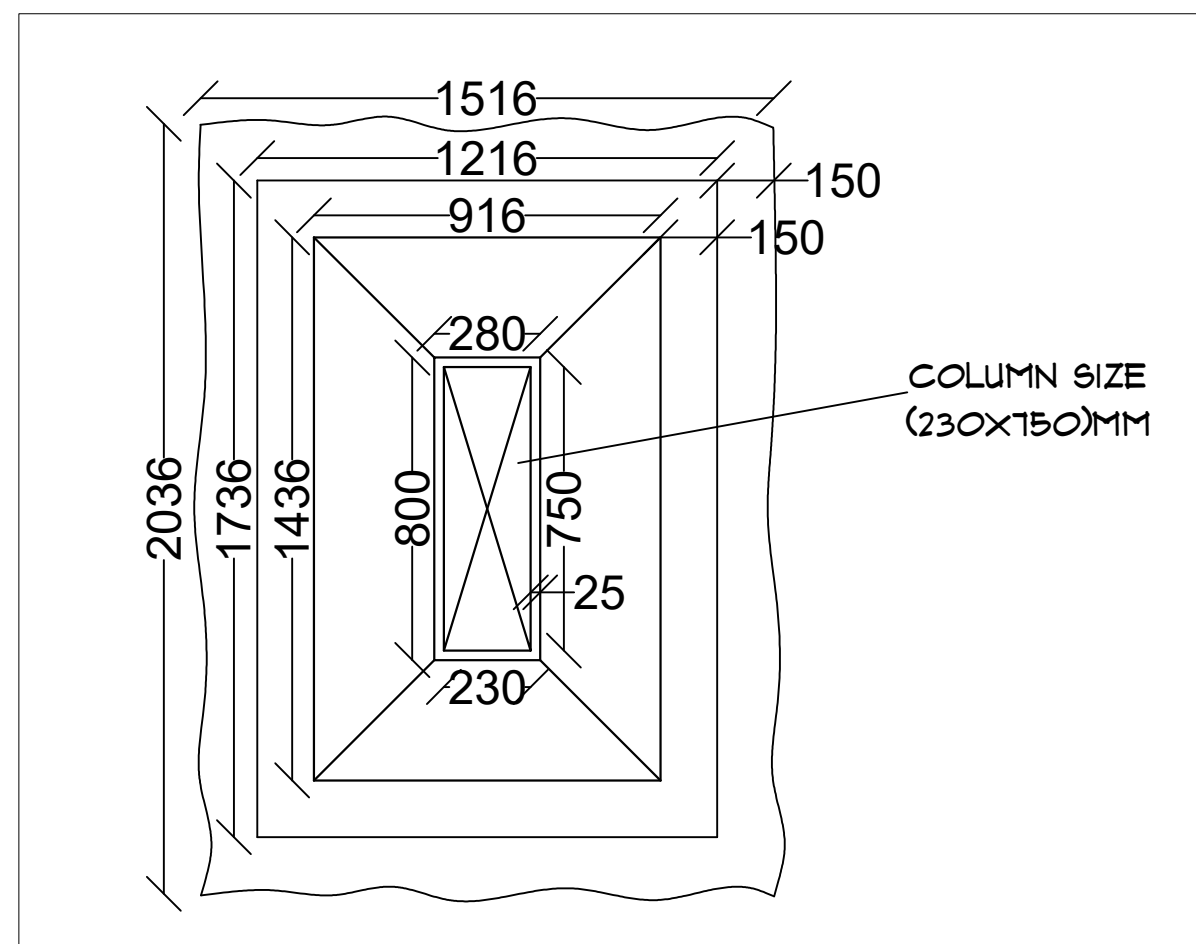

FOUNDATION IN PLAN
SCALE - 1:20

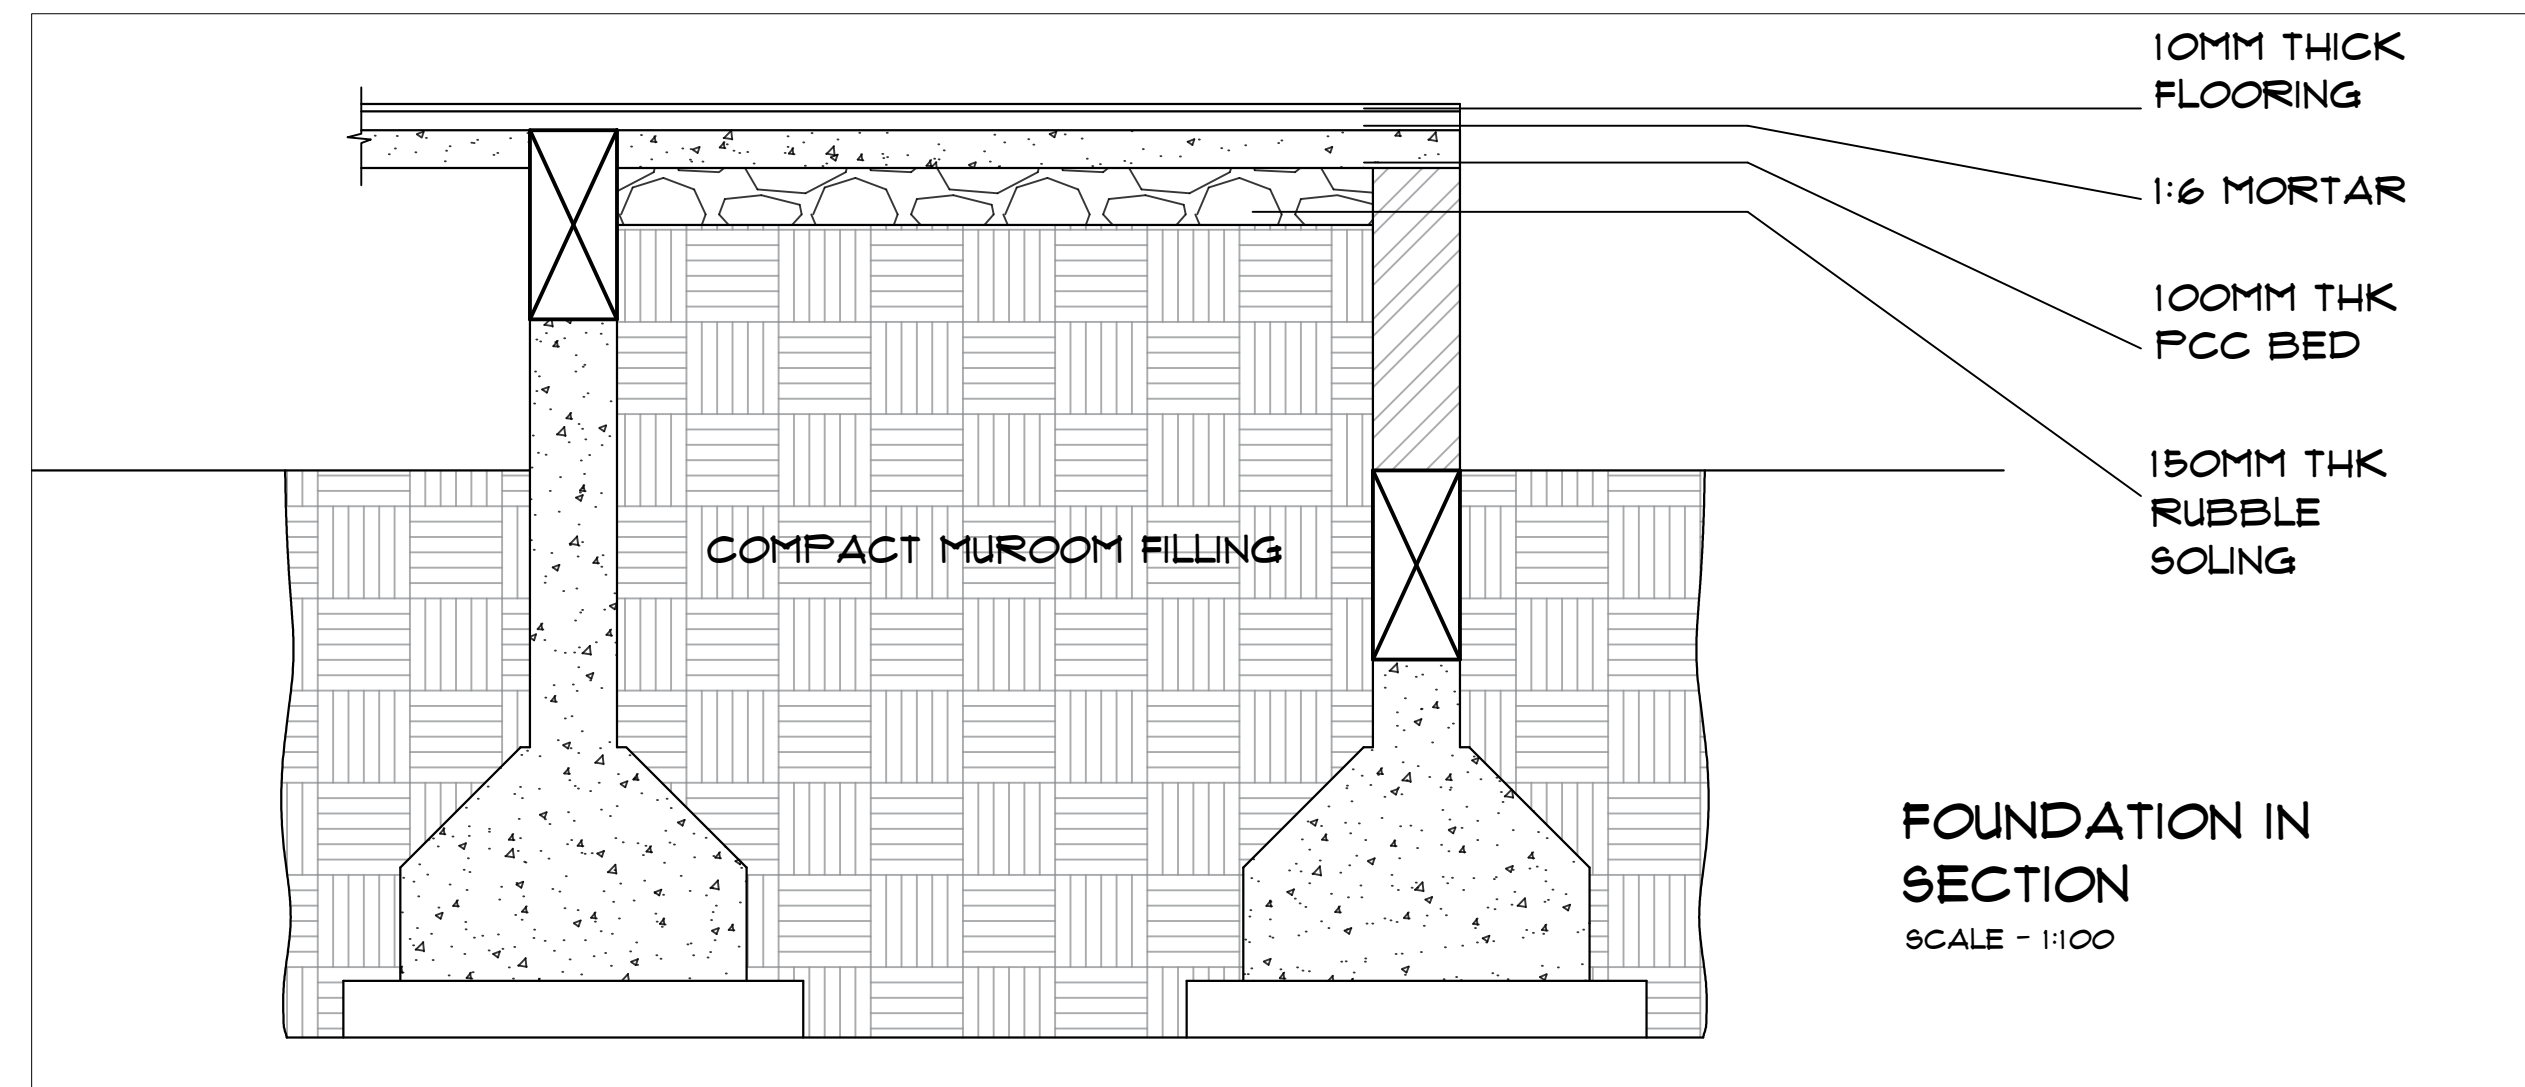

FOUNDATION IN SECTION
SCALE - 1:100

PROFORMA -

WORKING DRAWING - II

SHEET TITLE -

**GROUND AND PLINTH
BEAM PLAN WITH
FOUNDATION**

NOTES -

- 1) ALL DIMENSIONS ARE IN MM UNTIL SPECIFIED.
- 2) DO NOT MEASURE DRAWING, FOLLOW WRITTEN DIMENSIONS ONLY.
- 3) PLEASE REFER TO THE ARCHITECT IN CONCERN TO ANY QUERY OR DRAWING.
- 4) THIS DRAWING IS A PROPERTY OF THE ARCHITECT AND SHALL NOT BE REPRODUCED OR USED WITHOUT THEIR WRITTEN PERMISSION.

SCALE -

DATE -

REV NO. -

1 : 100


10/10/2024

DRAWN BY -

CHECKED BY -

VK

AR NS

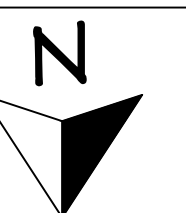


PROJECT -

**PROPOSED
SHOPPING COMPLEX
AT SOLAPUR**

ARCHITECT -


VAISHNAVI G. KARBHARI.
ROLL NO. - 99M/21/08
4TH YR, SEM VII (B.ARCH)
99M'S COLLEGE OF
ARCHITECTURE, SOLAPUR.

SIGN AND STAMP -

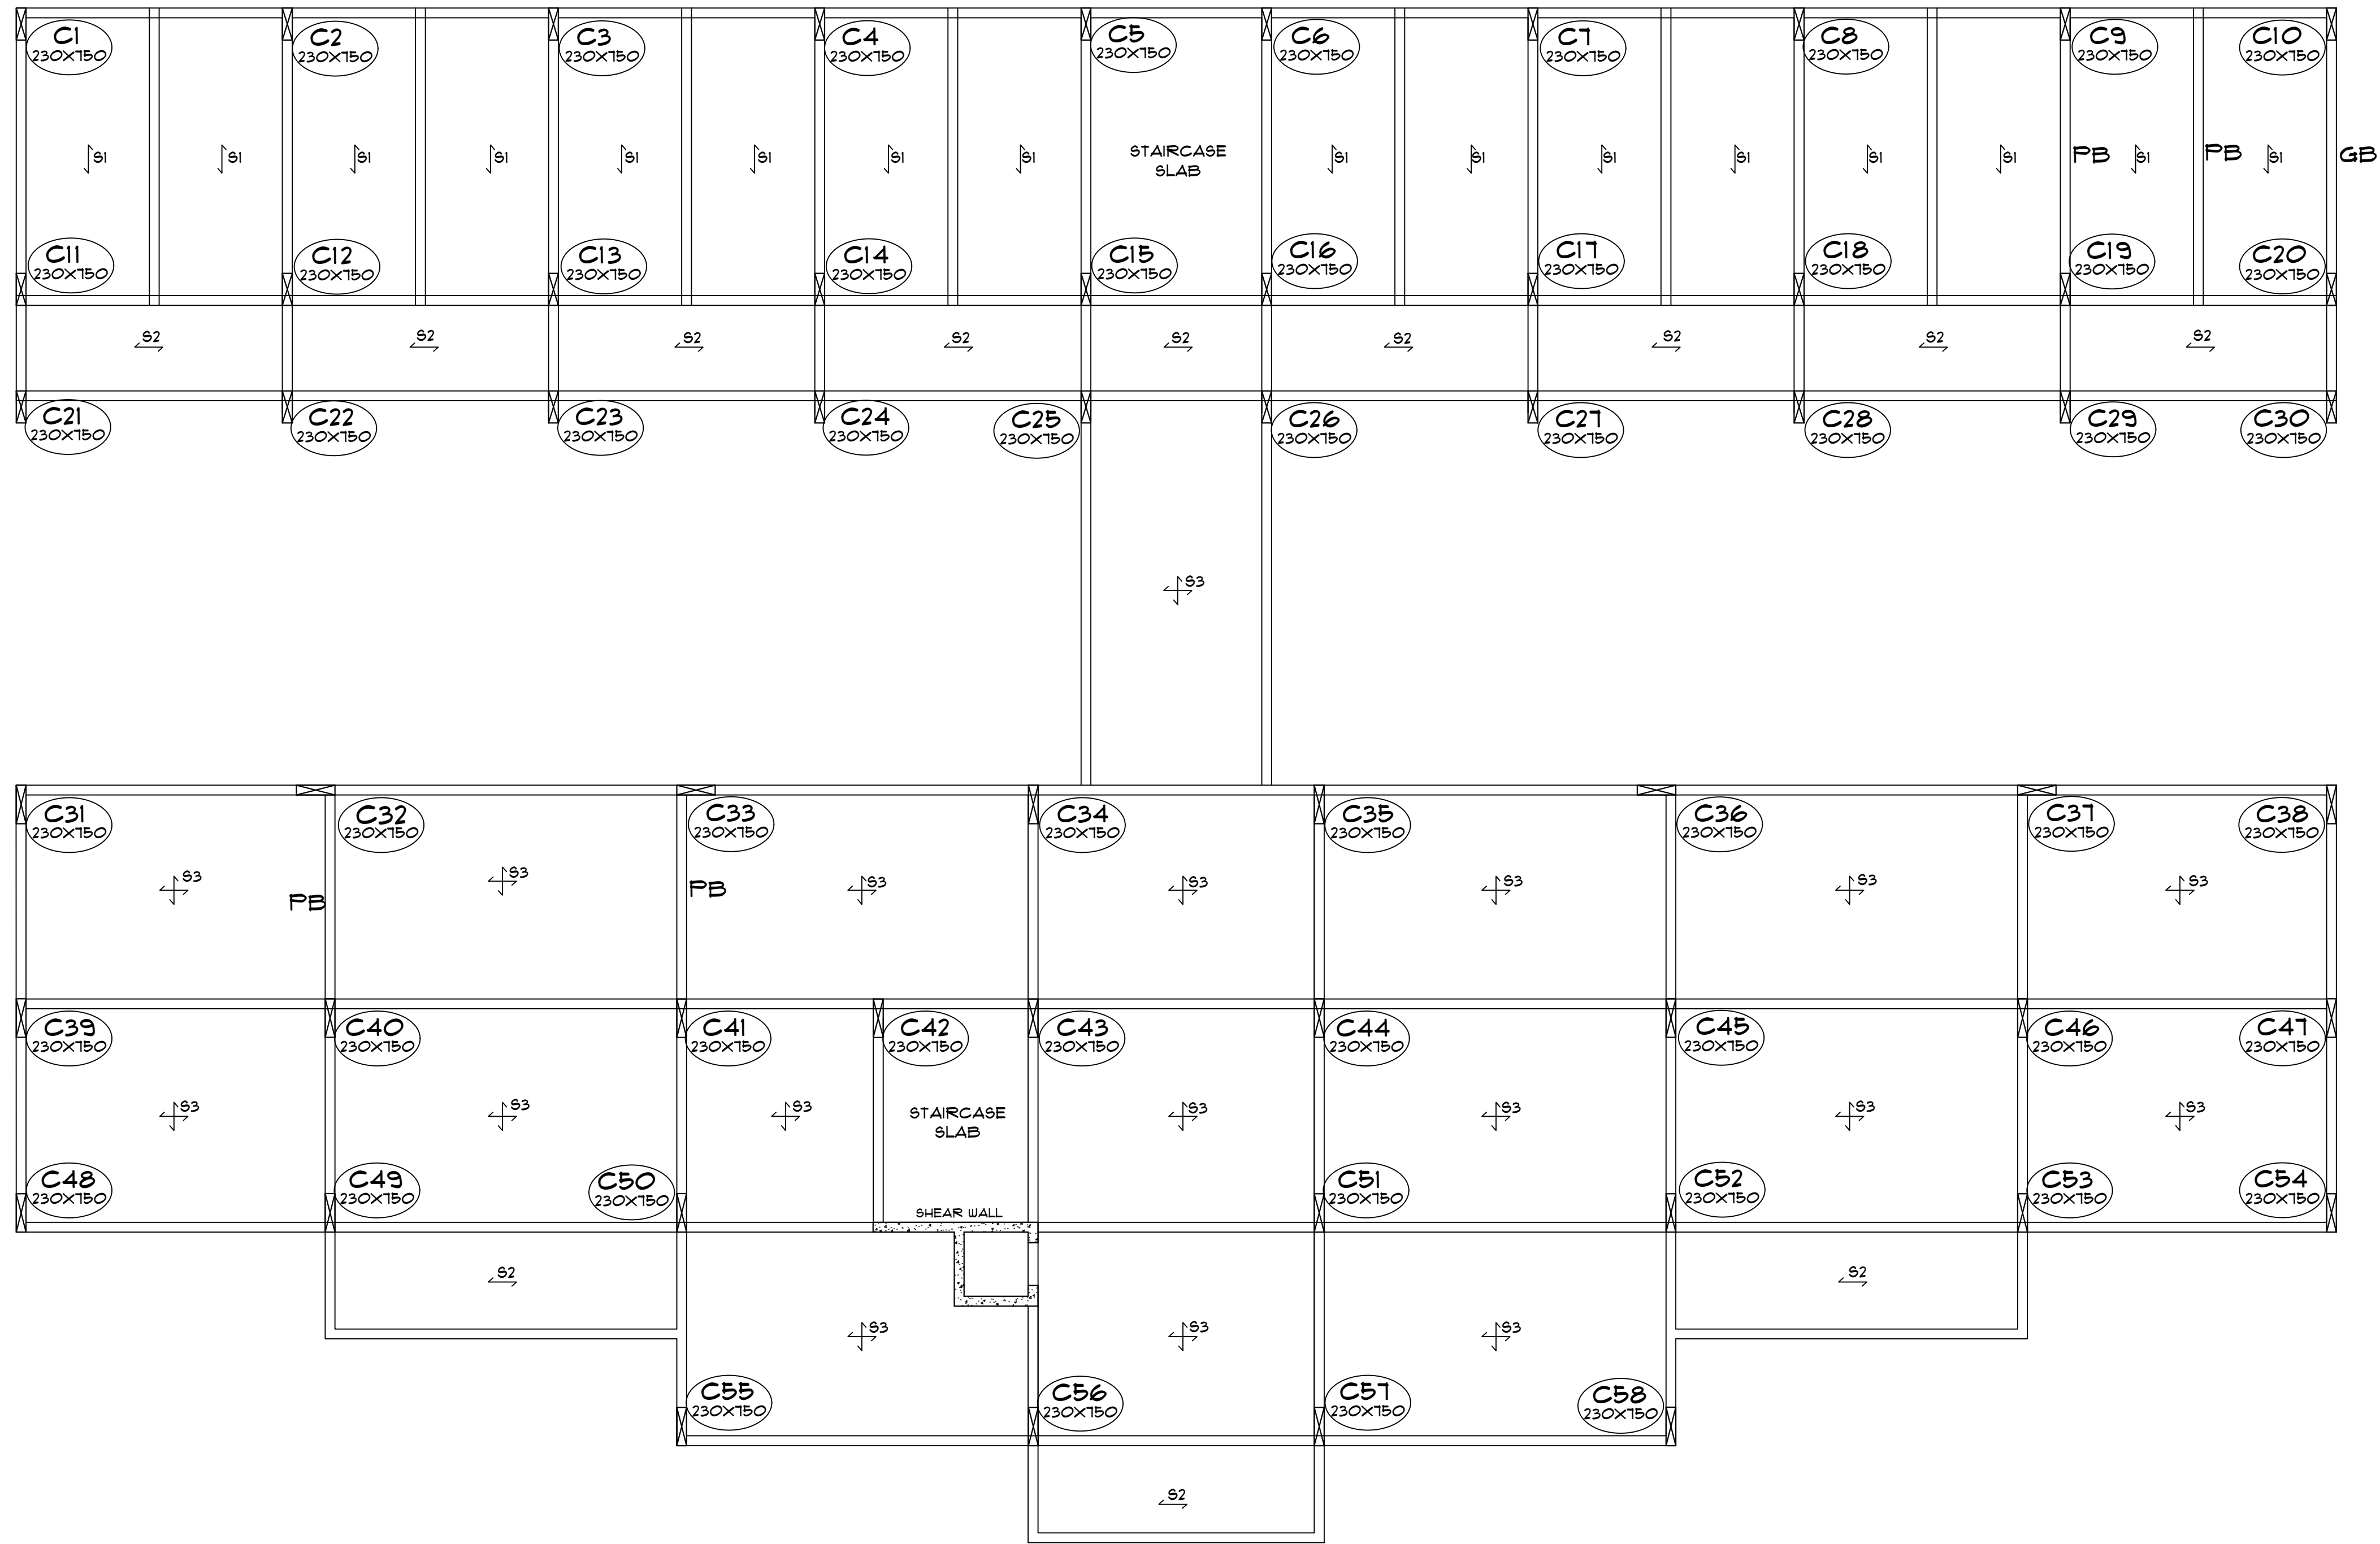

GROUND FLOOR SLAB PLAN

SCALE - 1:100

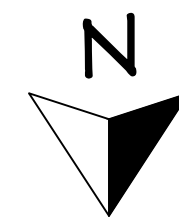

PROFORMA -

WORKING DRAWING - II

SHEET TITLE -

GROUND FLOOR SLAB
LEVEL FRAMING PLAN

NOTES -

- 1) ALL DIMENSIONS ARE IN MM UNTIL SPECIFIED.
- 2) DO NOT MEASURE DRAWING, FOLLOW WRITTEN DIMENSIONS ONLY.
- 3) PLEASE REFER TO THE ARCHITECT IN CONCERN TO ANY QUERY OR DRAWING.
- 4) THIS DRAWING IS A PROPERTY OF THE ARCHITECT AND SHALL NOT BE REPRODUCED OR USED WITHOUT THEIR WRITTEN PERMISSION.

SCALE -

DATE -

REV NO. -

1 : 100


10/10/2024

DRAWN BY -

CHECKED BY -

YK

AR NS

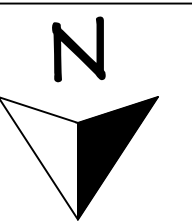



PROJECT -

PROPOSED
SHOPPING COMPLEX
AT SOLAPUR


ARCHITECT -

VAISHNAVI G. KARBHARI.
ROLL NO. - 99M/21/08
4TH YR, SEM VII (B.ARCH)
999M'S COLLEGE OF
ARCHITECTURE, SOLAPUR.

SIGN AND STAMP -

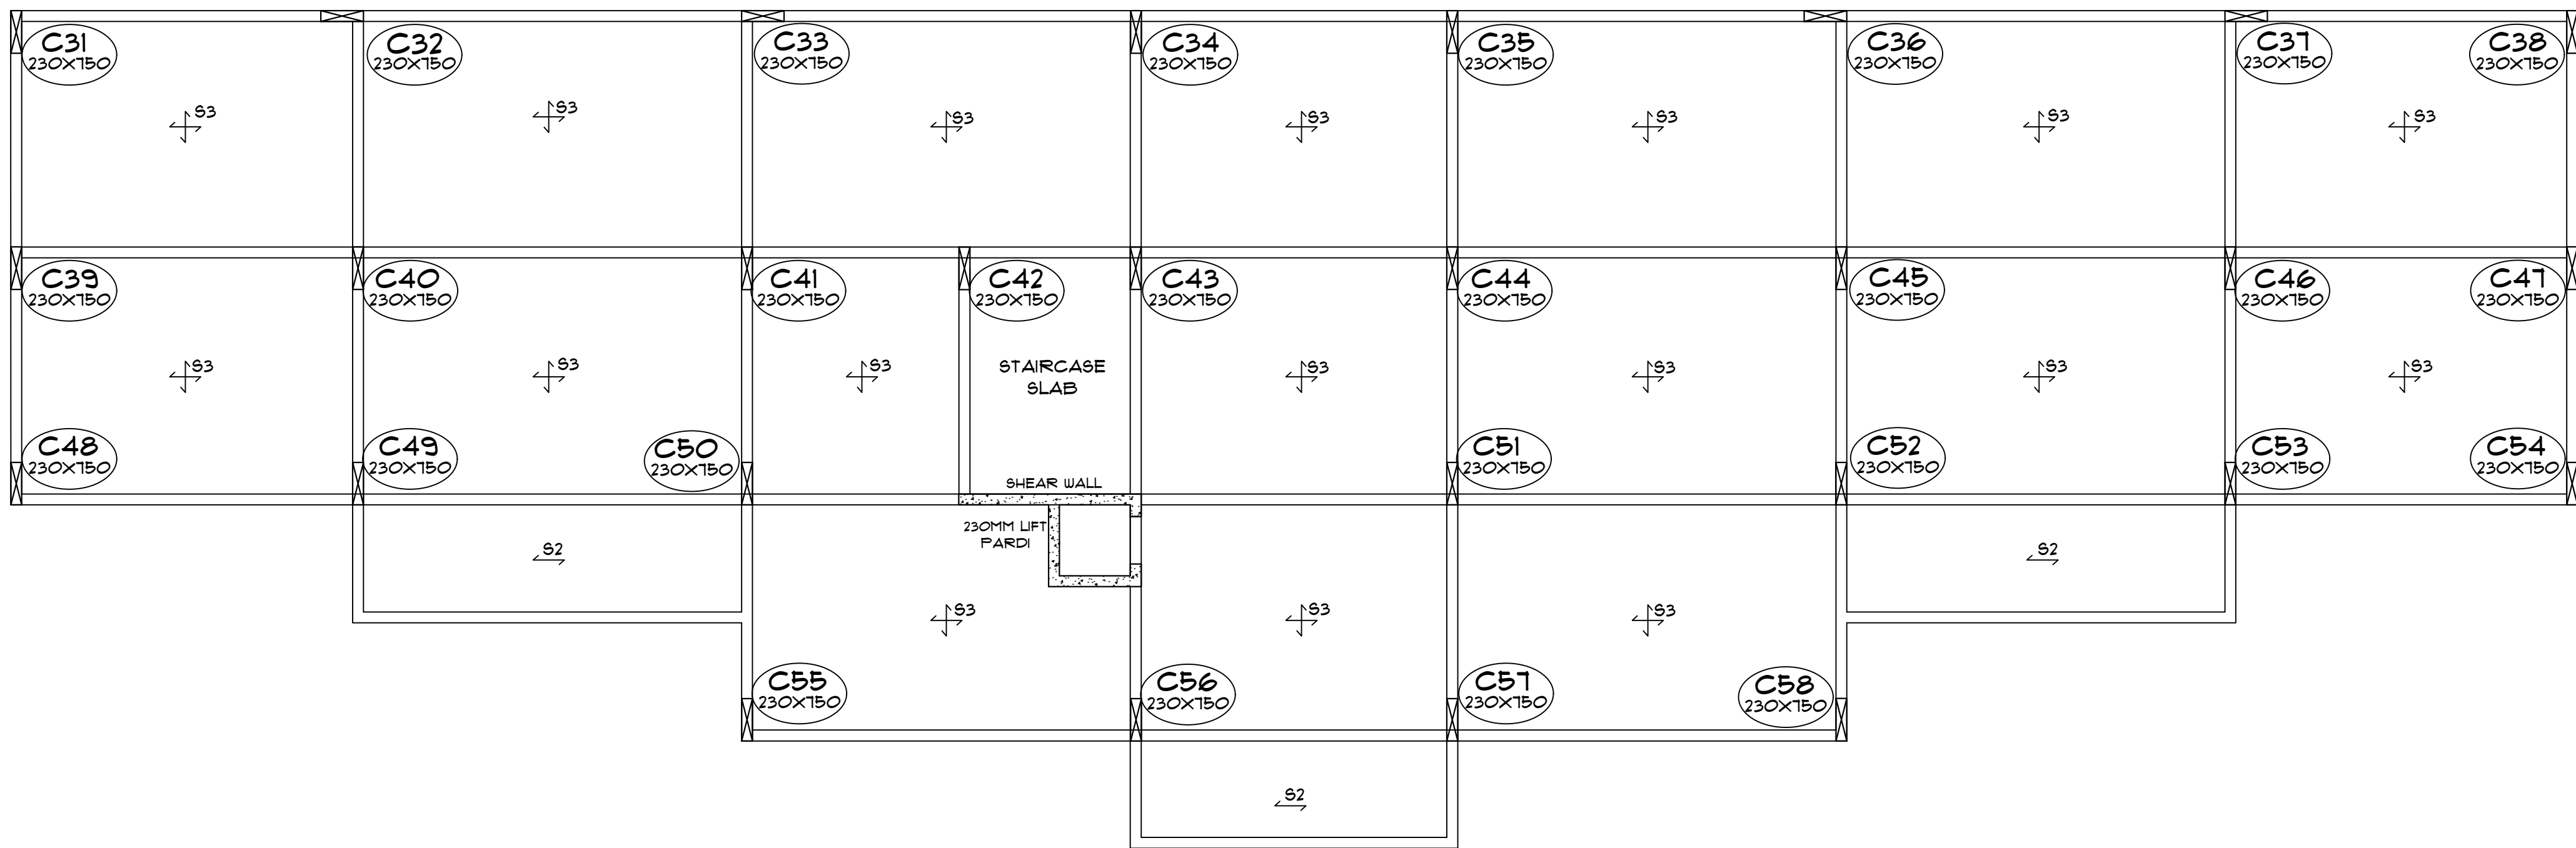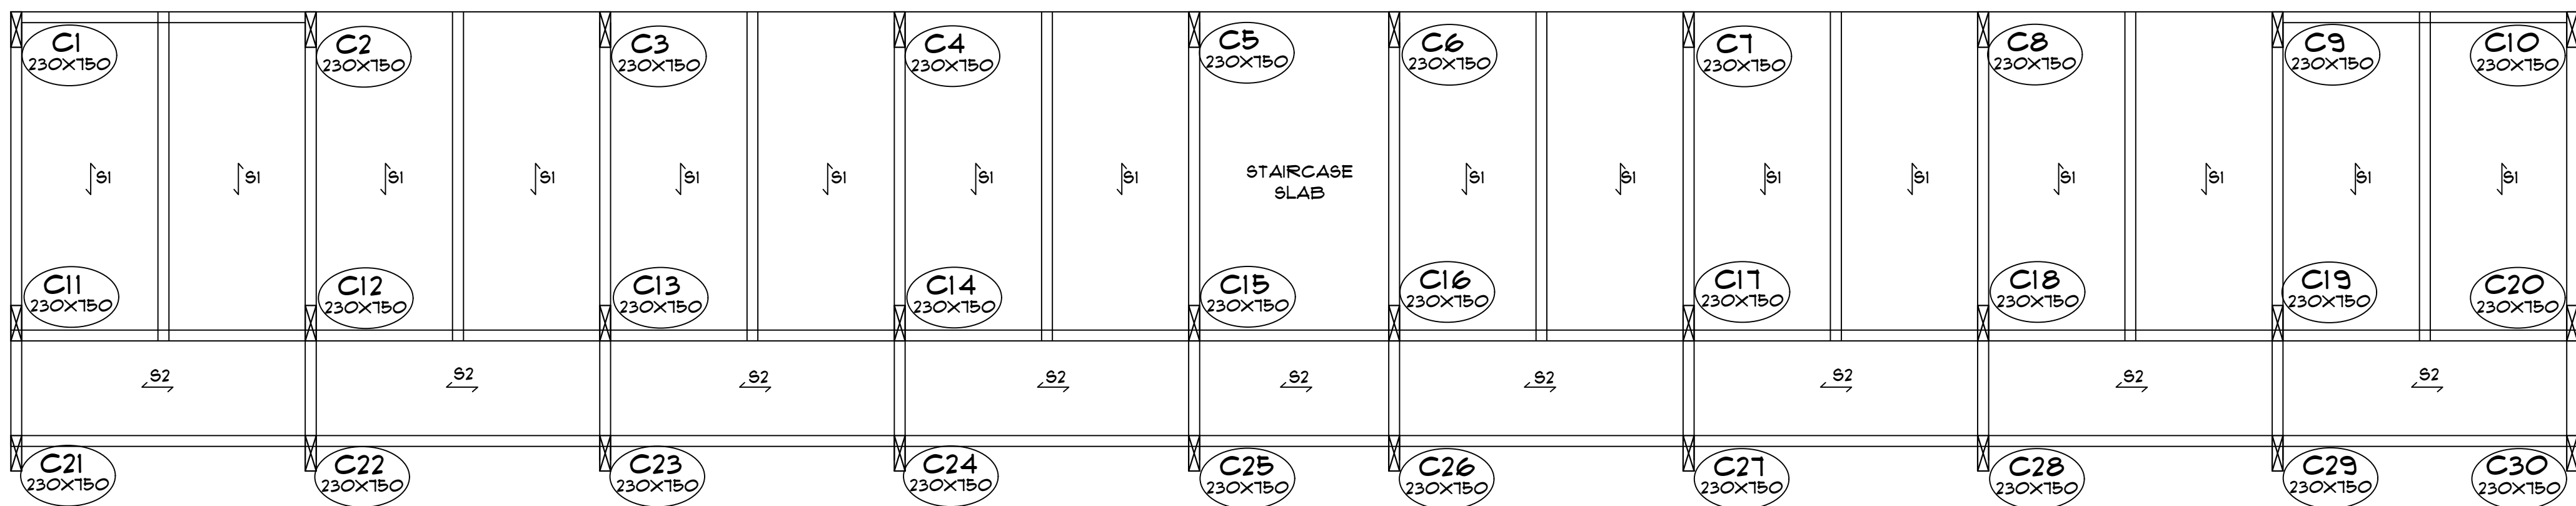

FIRST FLOOR SLAB PLAN
SCALE - 1:100

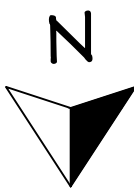

PROFORMA -

WORKING DRAWING - II

SHEET TITLE -

FIRST FLOOR SLAB
LEVEL FRAMING PLAN

NOTES -

- 1) ALL DIMENSIONS ARE IN MM UNTIL SPECIFIED.
- 2) DO NOT MEASURE DRAWING, FOLLOW WRITTEN DIMENSIONS ONLY.
- 3) PLEASE REFER TO THE ARCHITECT IN CONCERN TO ANY QUERY OR DRAWING.
- 4) THIS DRAWING IS A PROPERTY OF THE ARCHITECT AND SHALL NOT BE REPRODUCED OR USED WITHOUT THEIR WRITTEN PERMISSION.

SCALE -

DATE -

REV NO. -

1 : 100

05/11/2024

DRAWN BY -

CHECKED BY -

YK

AR NS




PROJECT -

PROPOSED
SHOPPING COMPLEX
AT SOLAPUR


ARCHITECT -

VAISHNAVI G. KARBHARI.
ROLL NO. - 55M/21/08
4TH YR, SEM VII (B.ARCH)
555M'S COLLEGE OF
ARCHITECTURE, SOLAPUR.


SIGN AND STAMP -

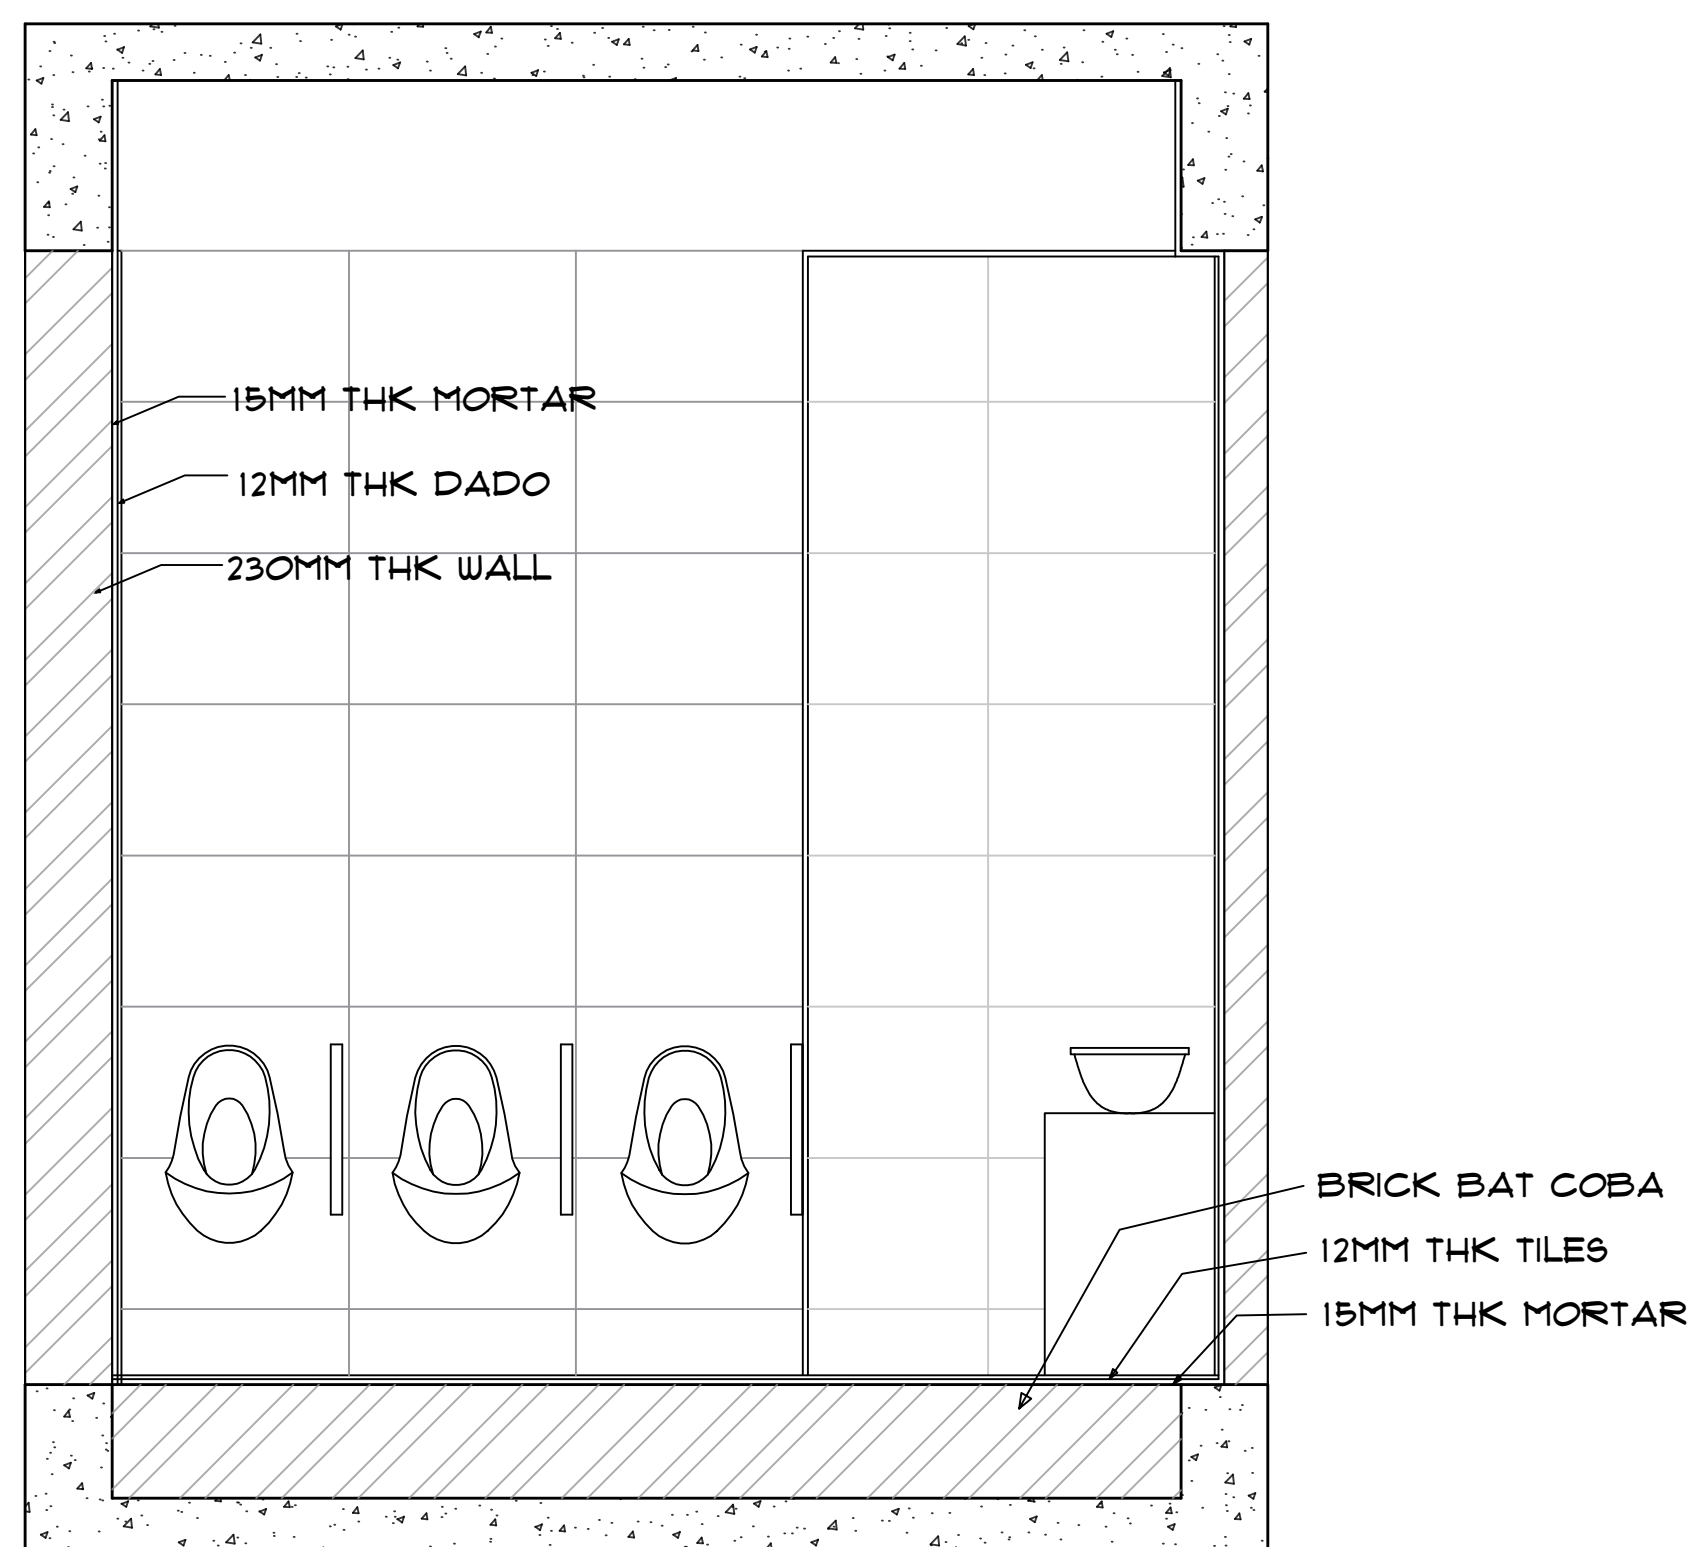

SECTION DD'
SCALE - 1:20

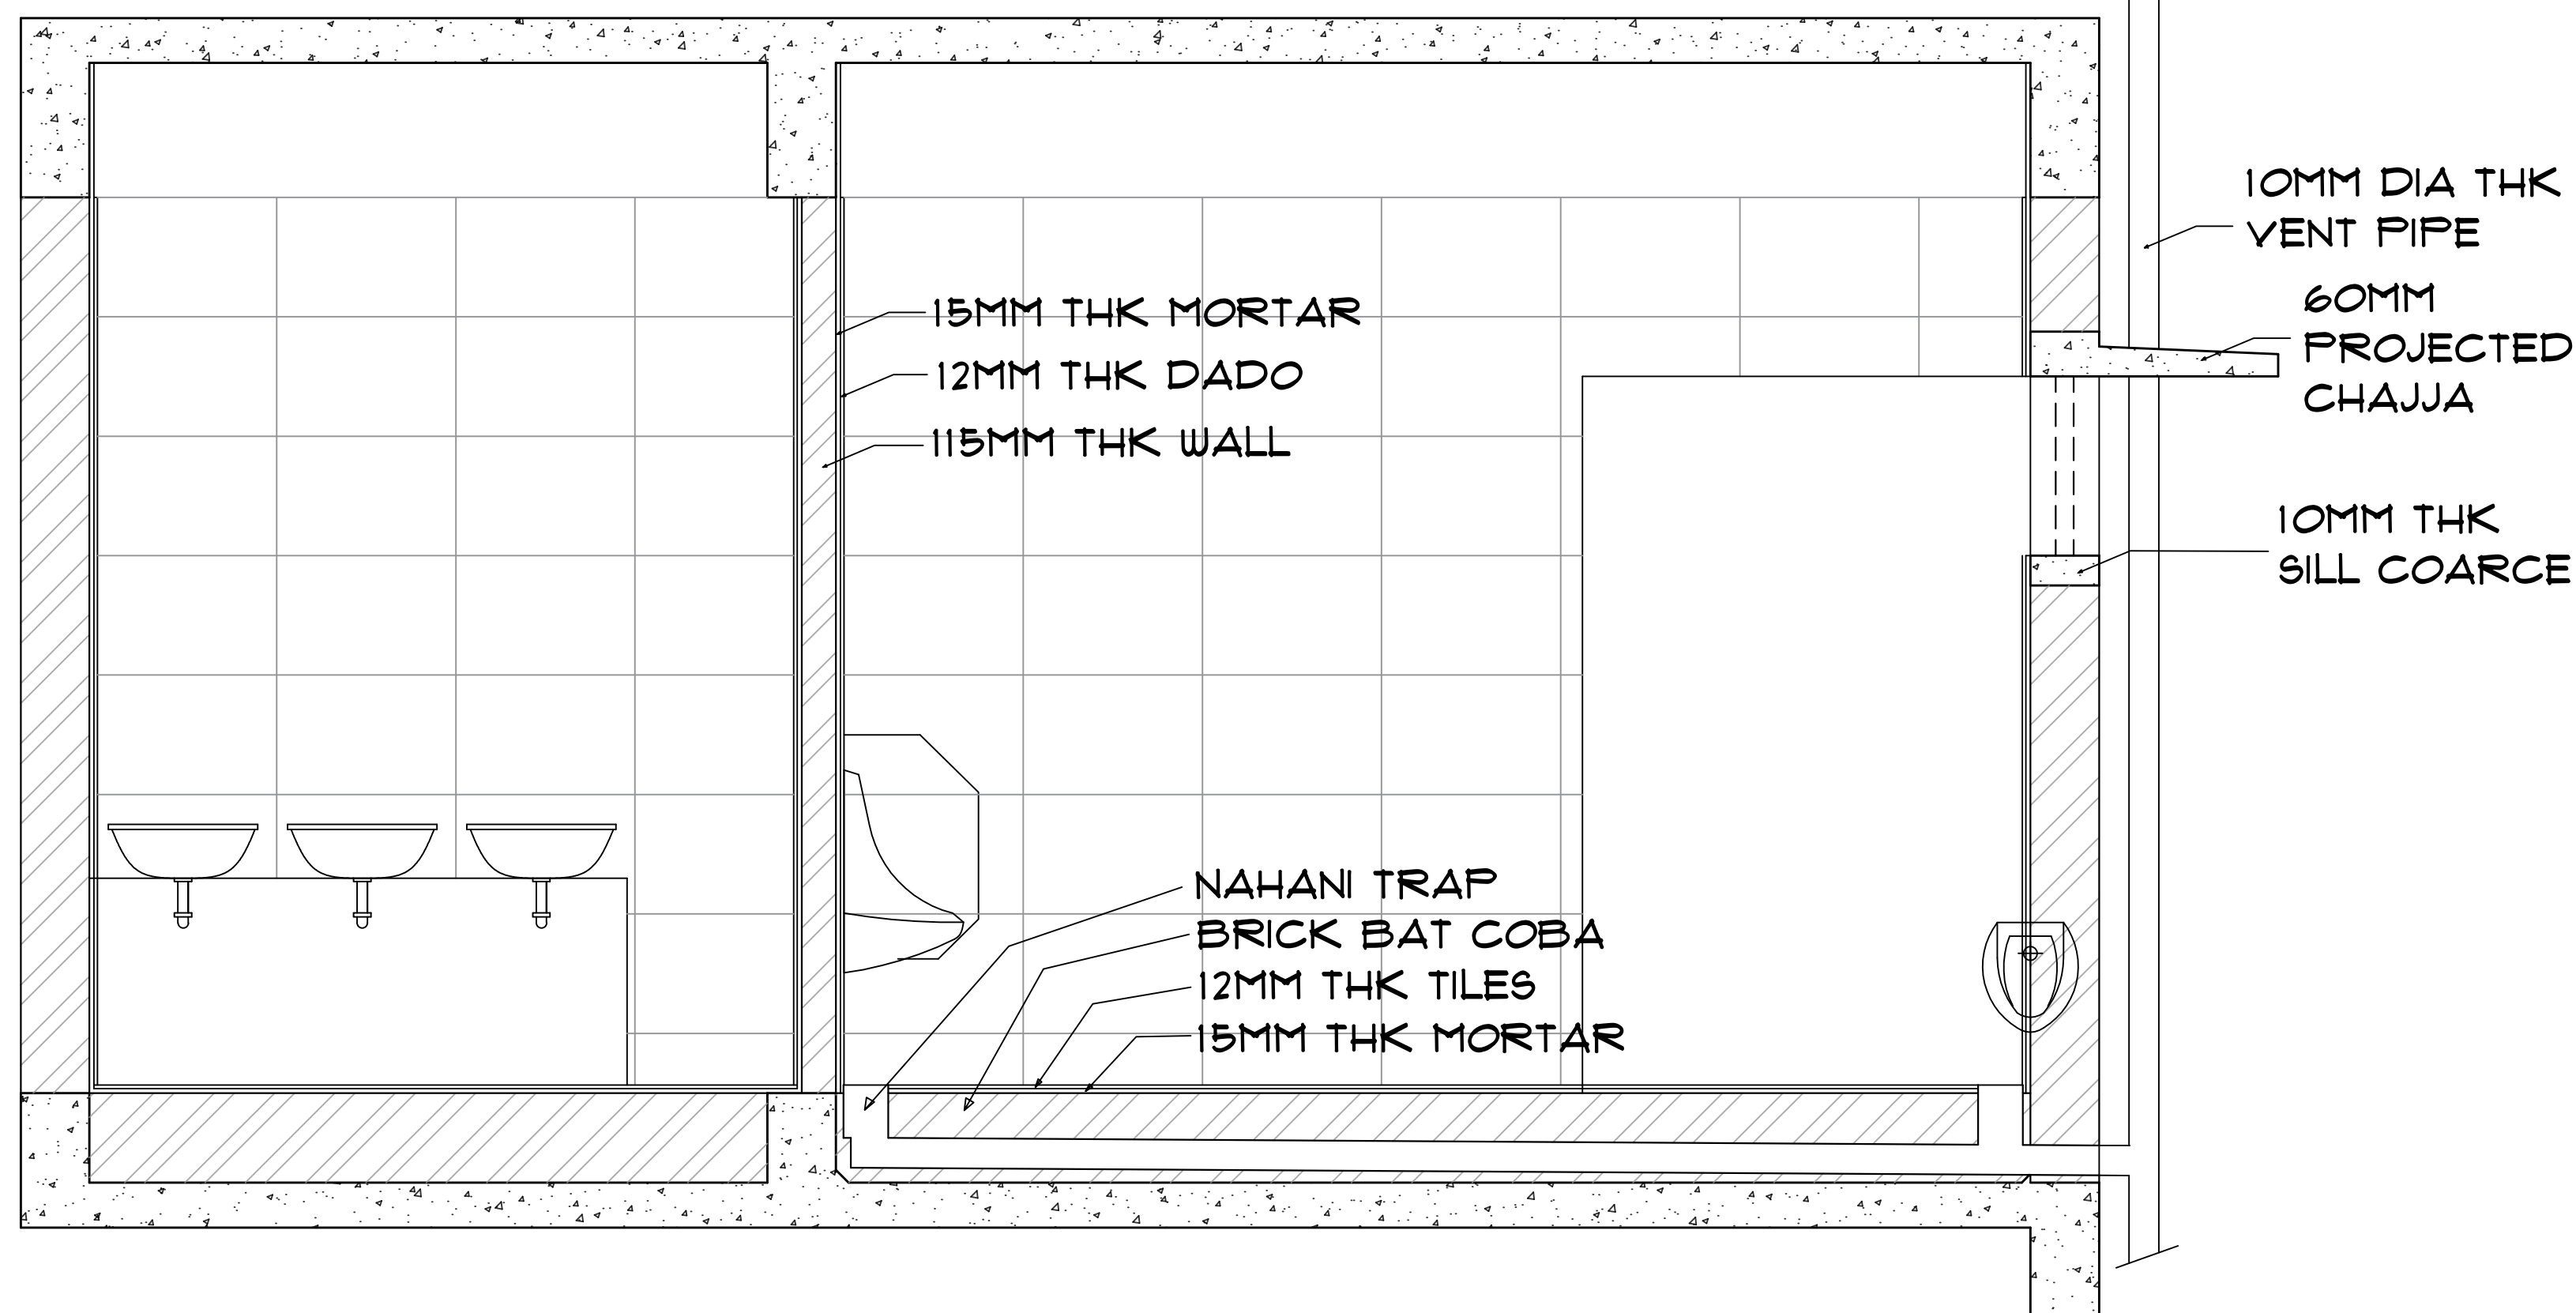

SECTION CC'
SCALE - 1:20

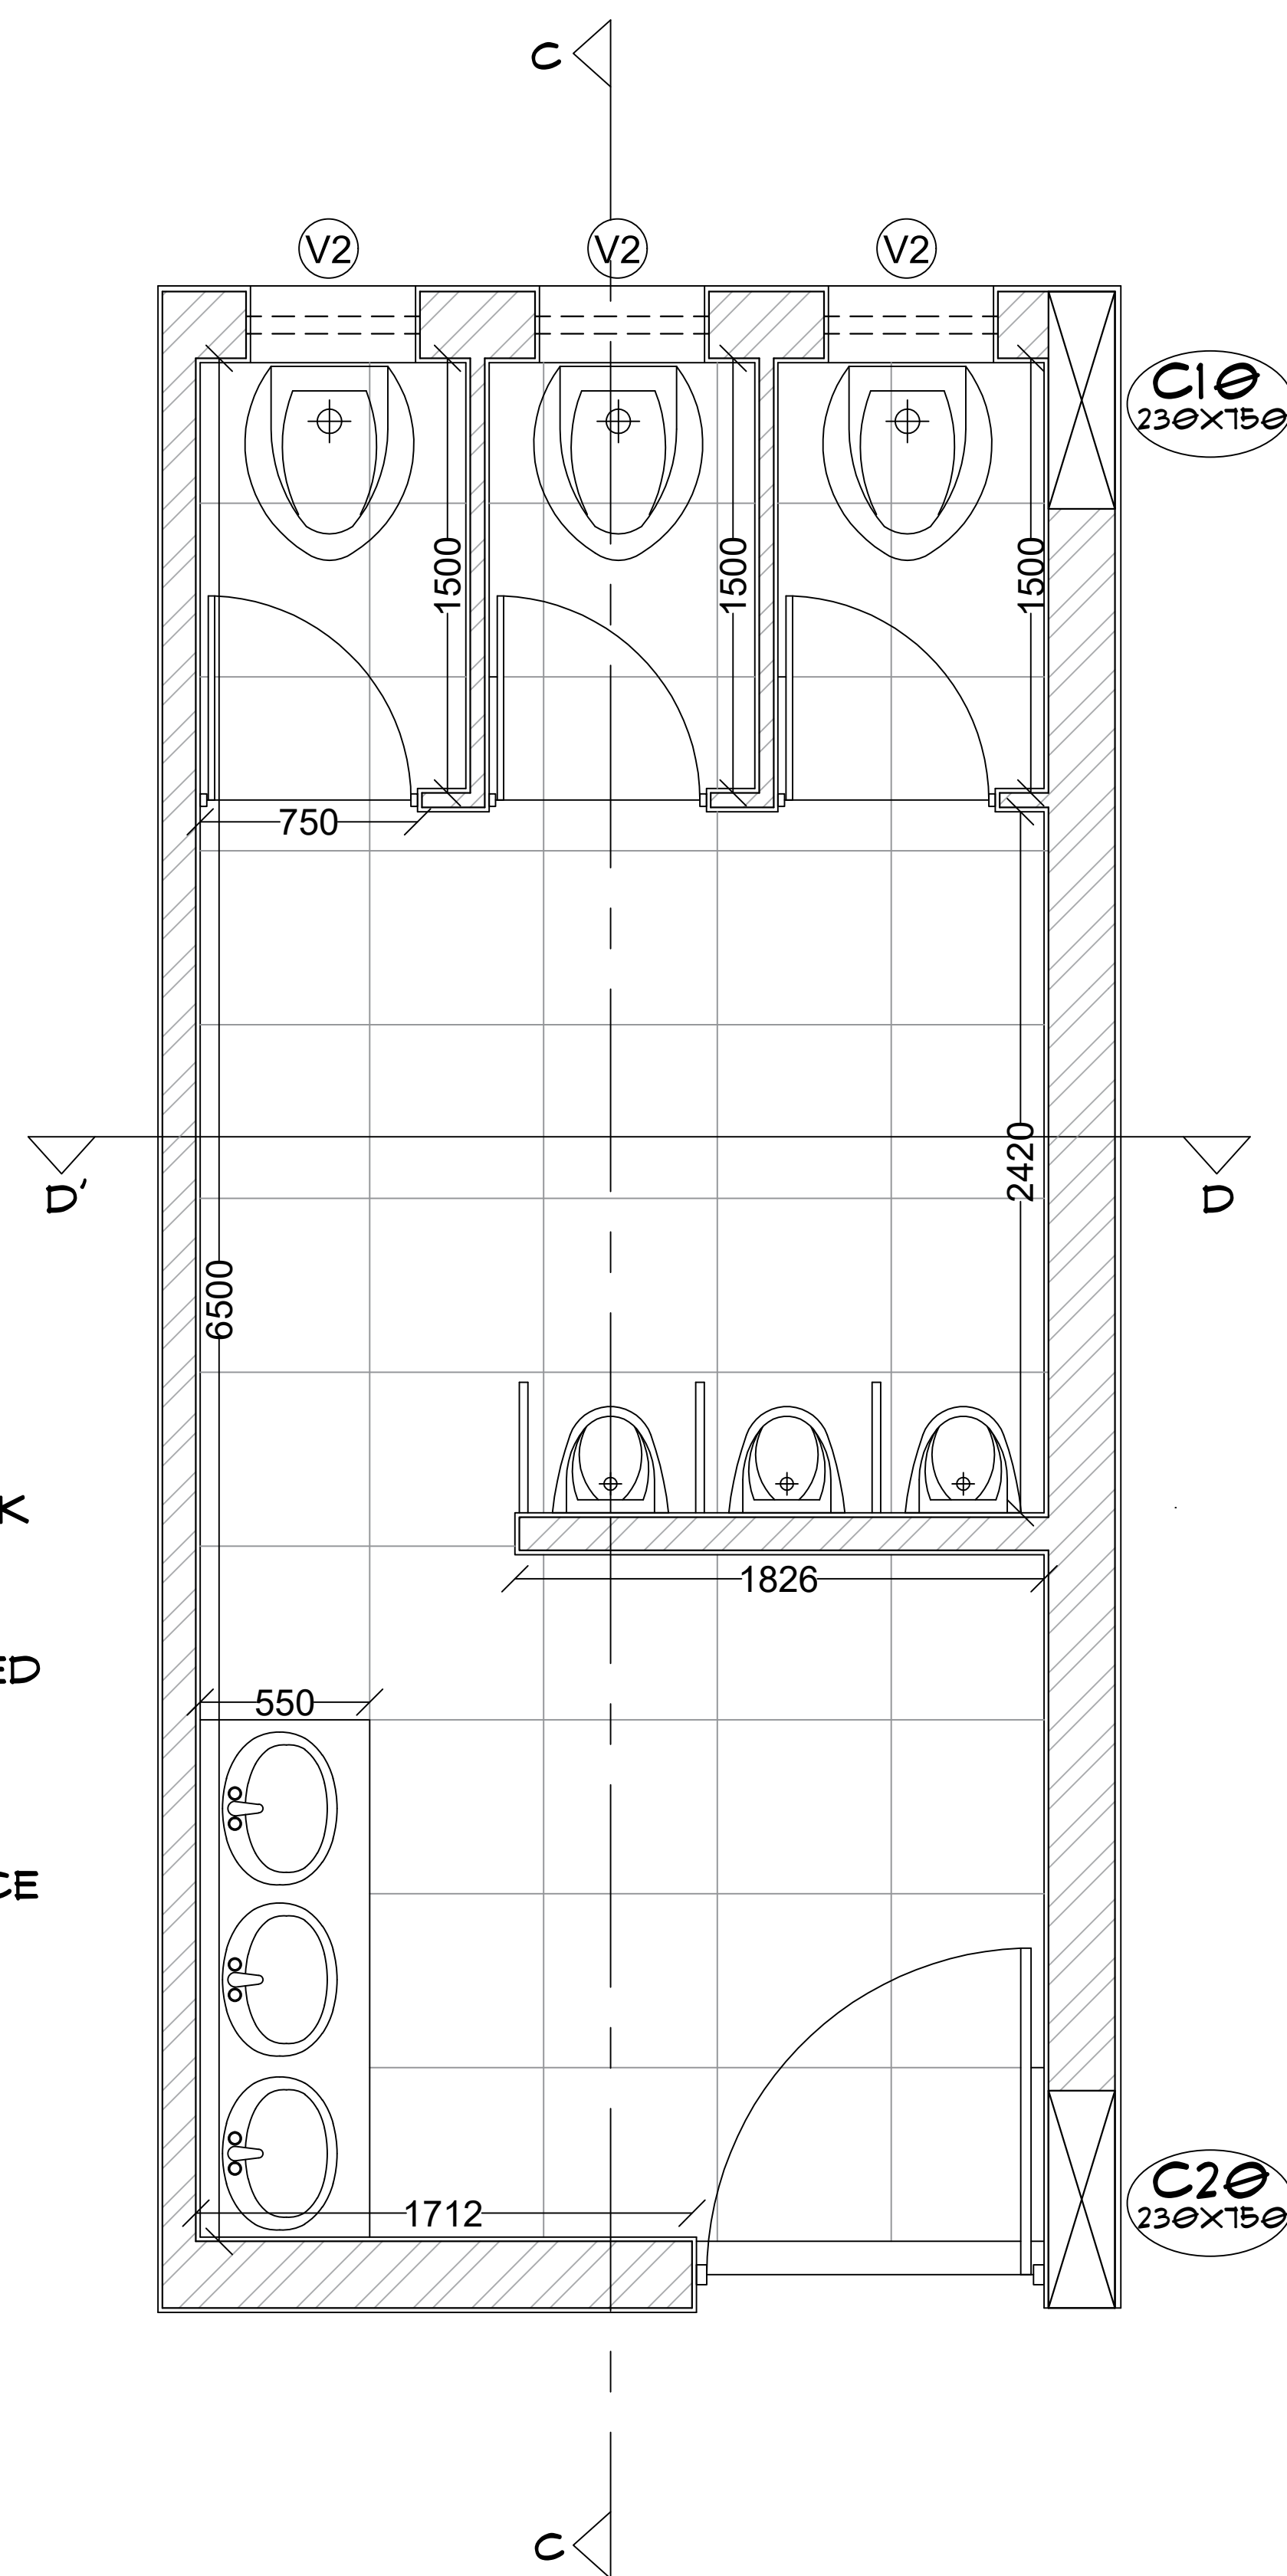

FIRST FLOOR TOILET DETAIL
SCALE - 1:20

PROFORMA -
WORKING DRAWING - II
SHEET TITLE -

TOILET DETAIL

NOTES -

- 1) ALL DIMENSIONS ARE IN MM UNTIL SPECIFIED.
- 2) DO NOT MEASURE DRAWING, FOLLOW WRITTEN DIMENSIONS ONLY.
- 3) PLEASE REFER TO THE ARCHITECT IN CONCERN TO ANY QUERY OR DRAWING.
- 4) THIS DRAWING IS A PROPERTY OF THE ARCHITECT AND SHALL NOT BE REPRODUCED OR USED WITHOUT THEIR WRITTEN PERMISSION.

SCALE - DATE - REV NO. -

1 : 20 10/10/2024

DRAWN BY - CHECKED BY -

VK AR NS




PROJECT -

PROPOSED SHOPPING COMPLEX AT SOLAPUR


ARCHITECT -

VAISHNAVI G. KARBHARI.
ROLL NO. - 99M/21/08
4TH YR, SEM VII (B.ARCH)
99M'S COLLEGE OF
ARCHITECTURE, SOLAPUR.


SIGN AND STAMP -

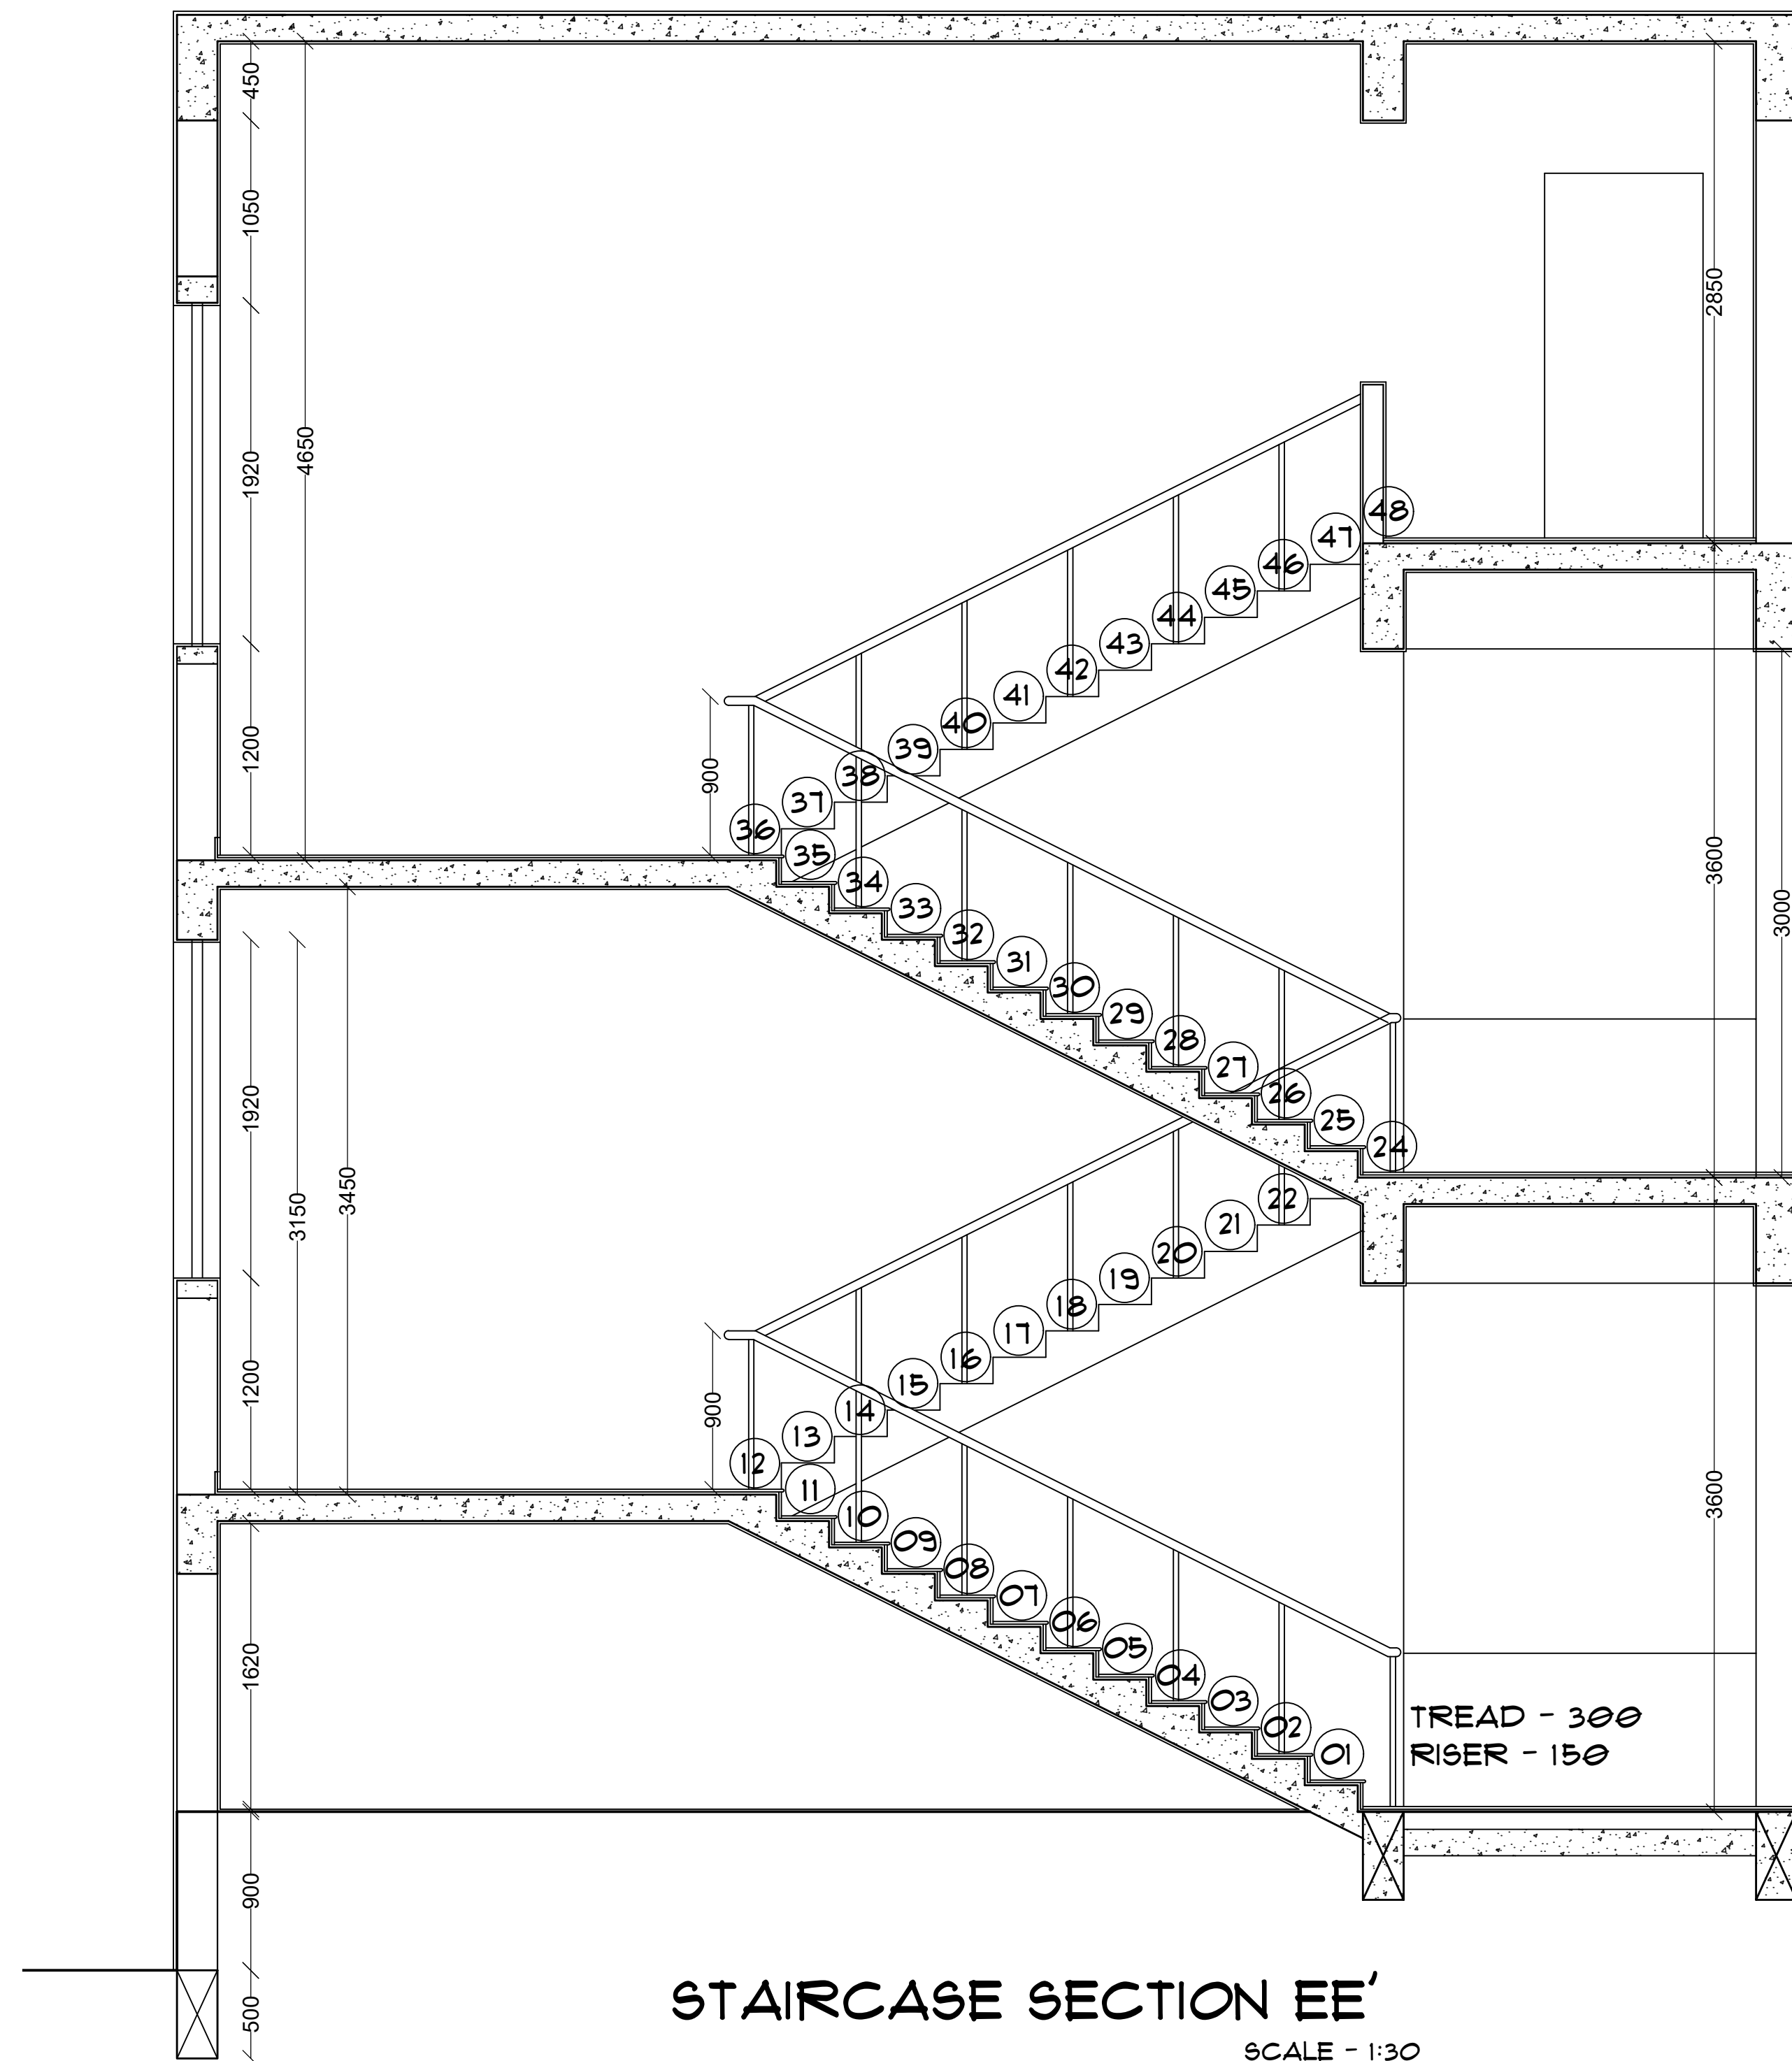


STAIRCASE SECTION EE'
SCALE - 1:30

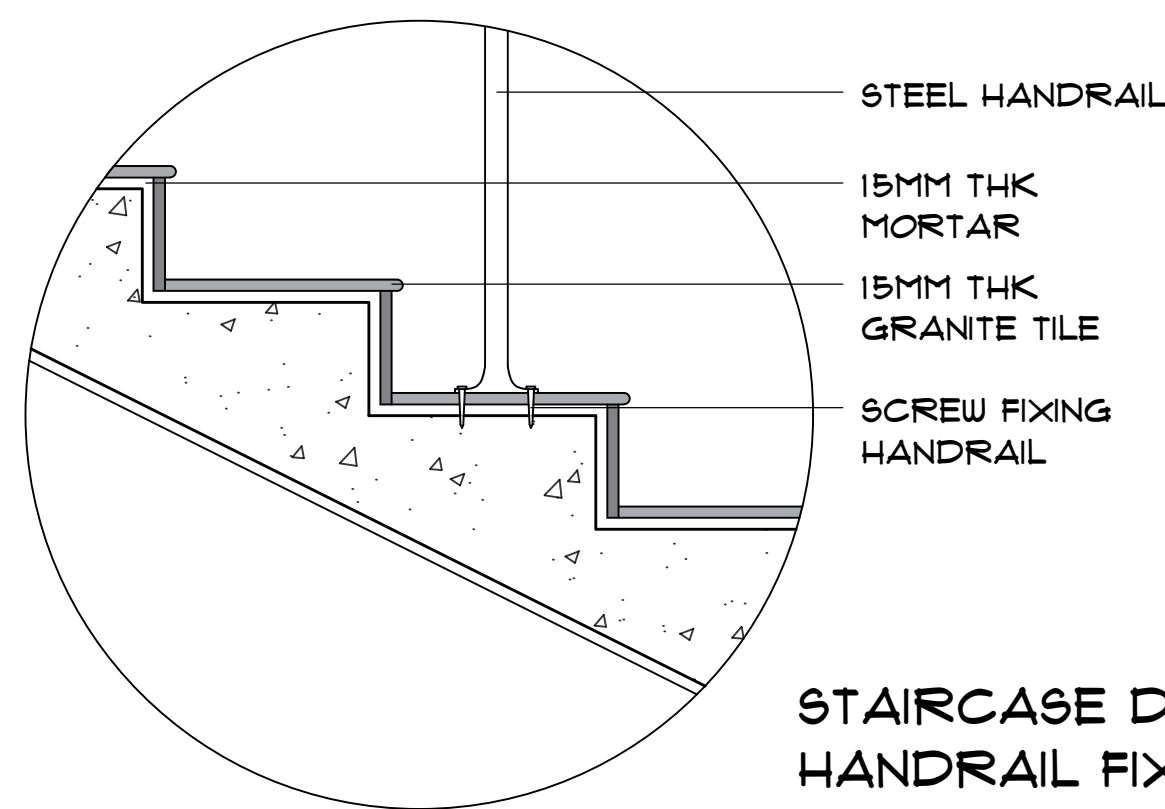

STAIRCASE DETAIL WITH
HANDRAIL FIXING
SCALE - 1:10

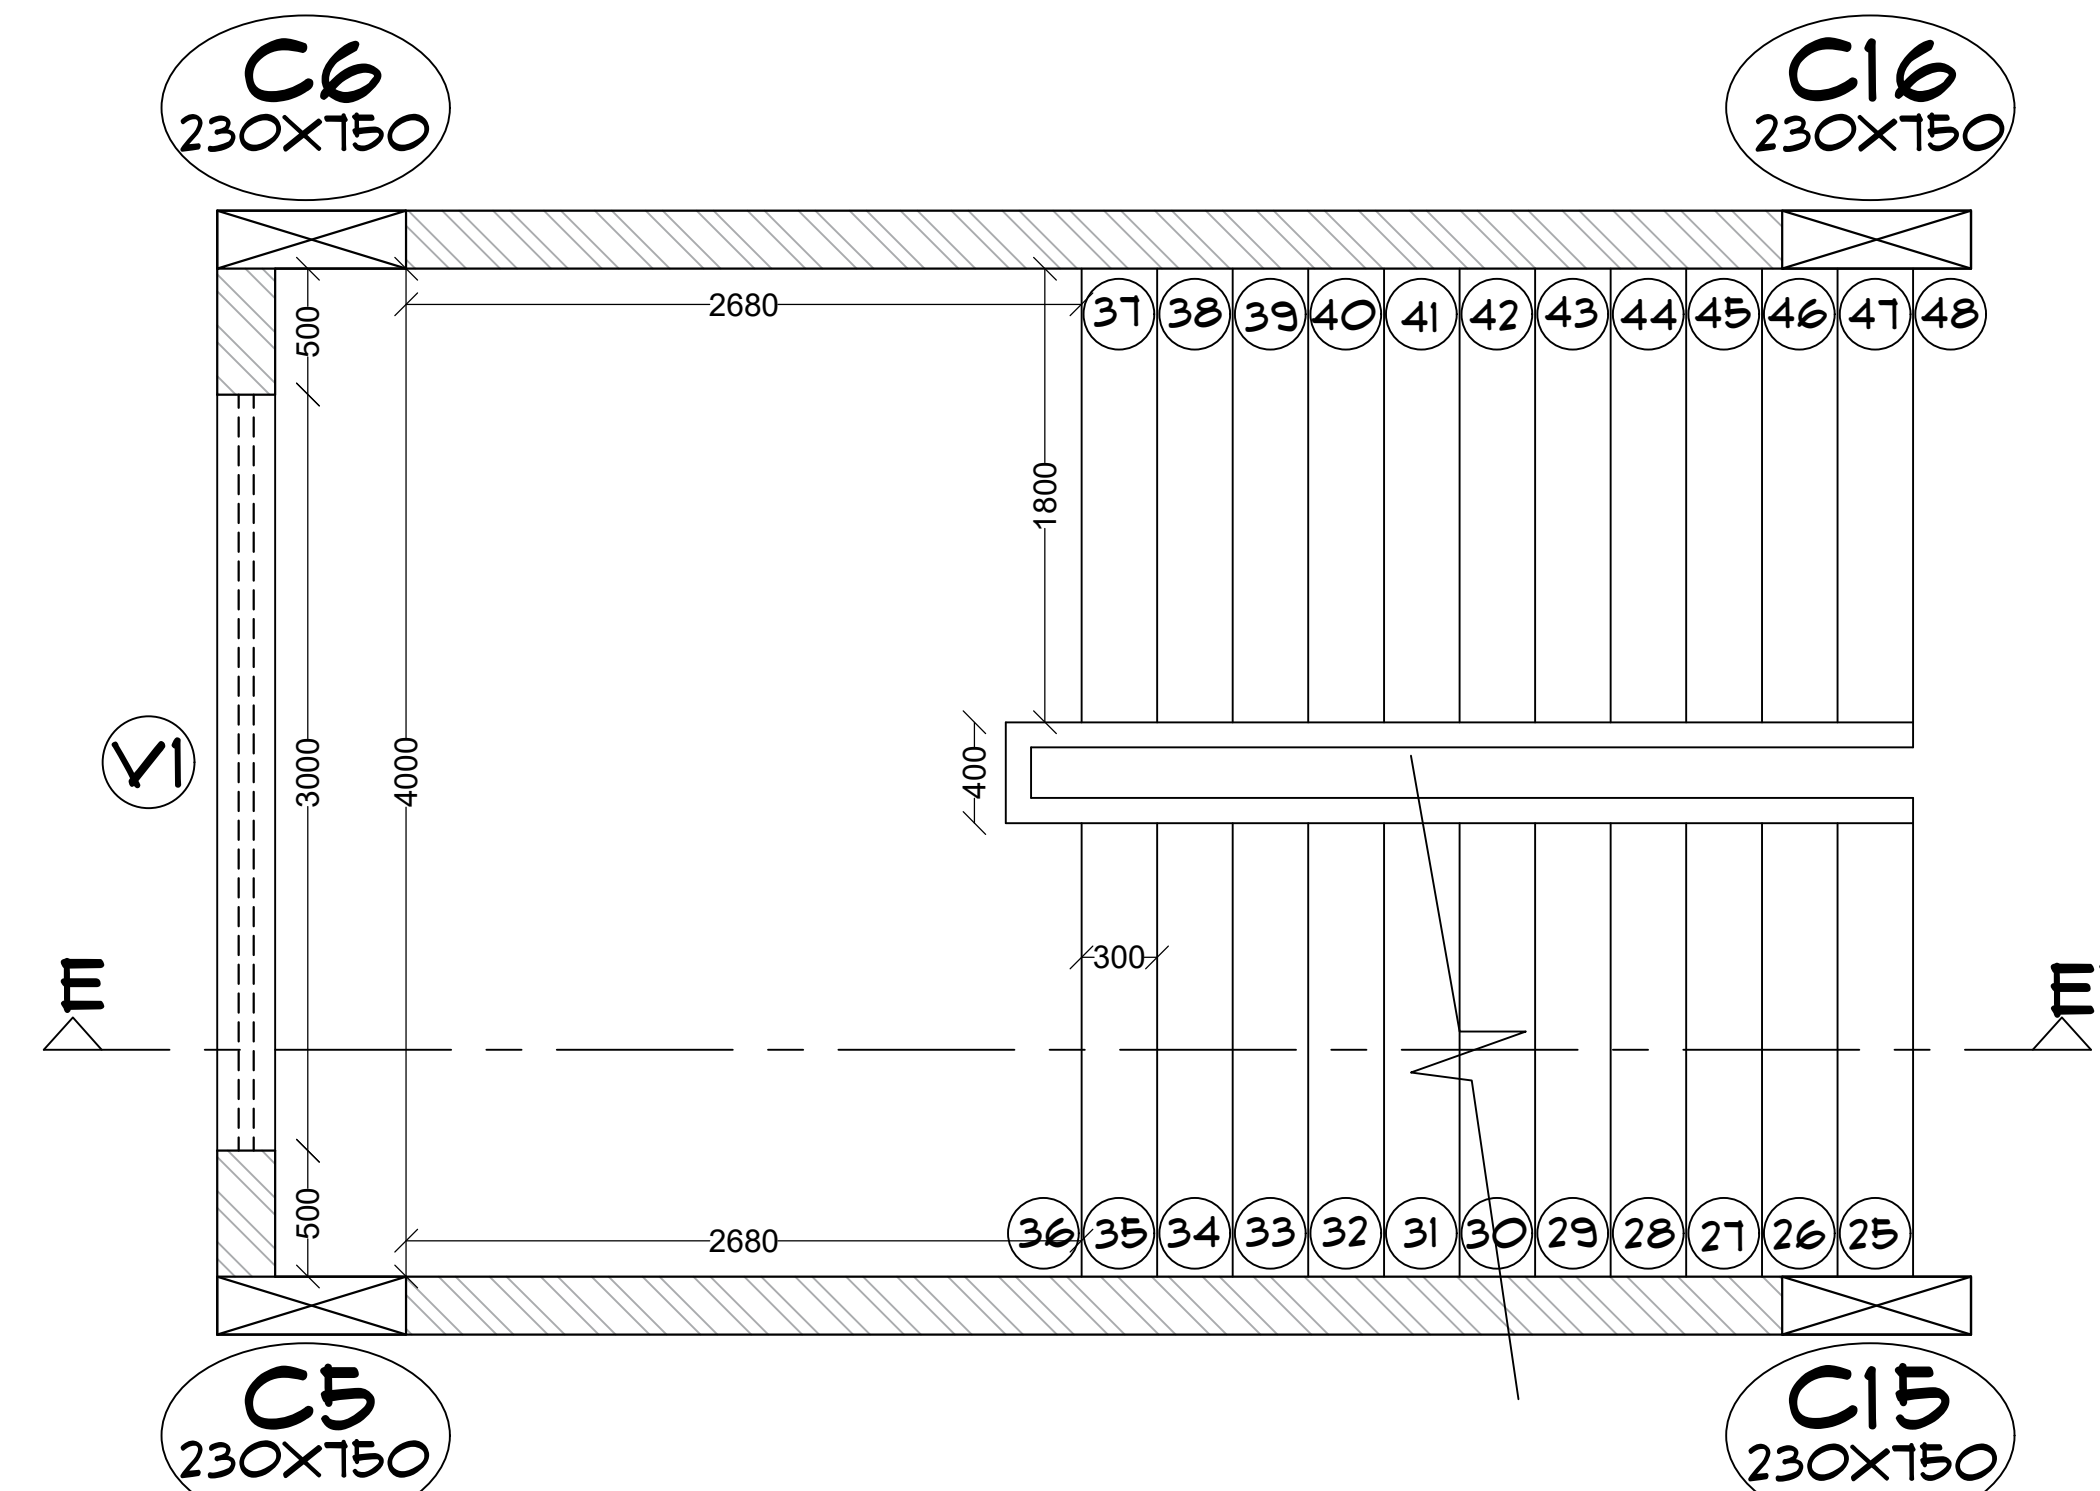

FIRST FLOOR STAIRCASE DETAIL
PLAN
SCALE - 1:30

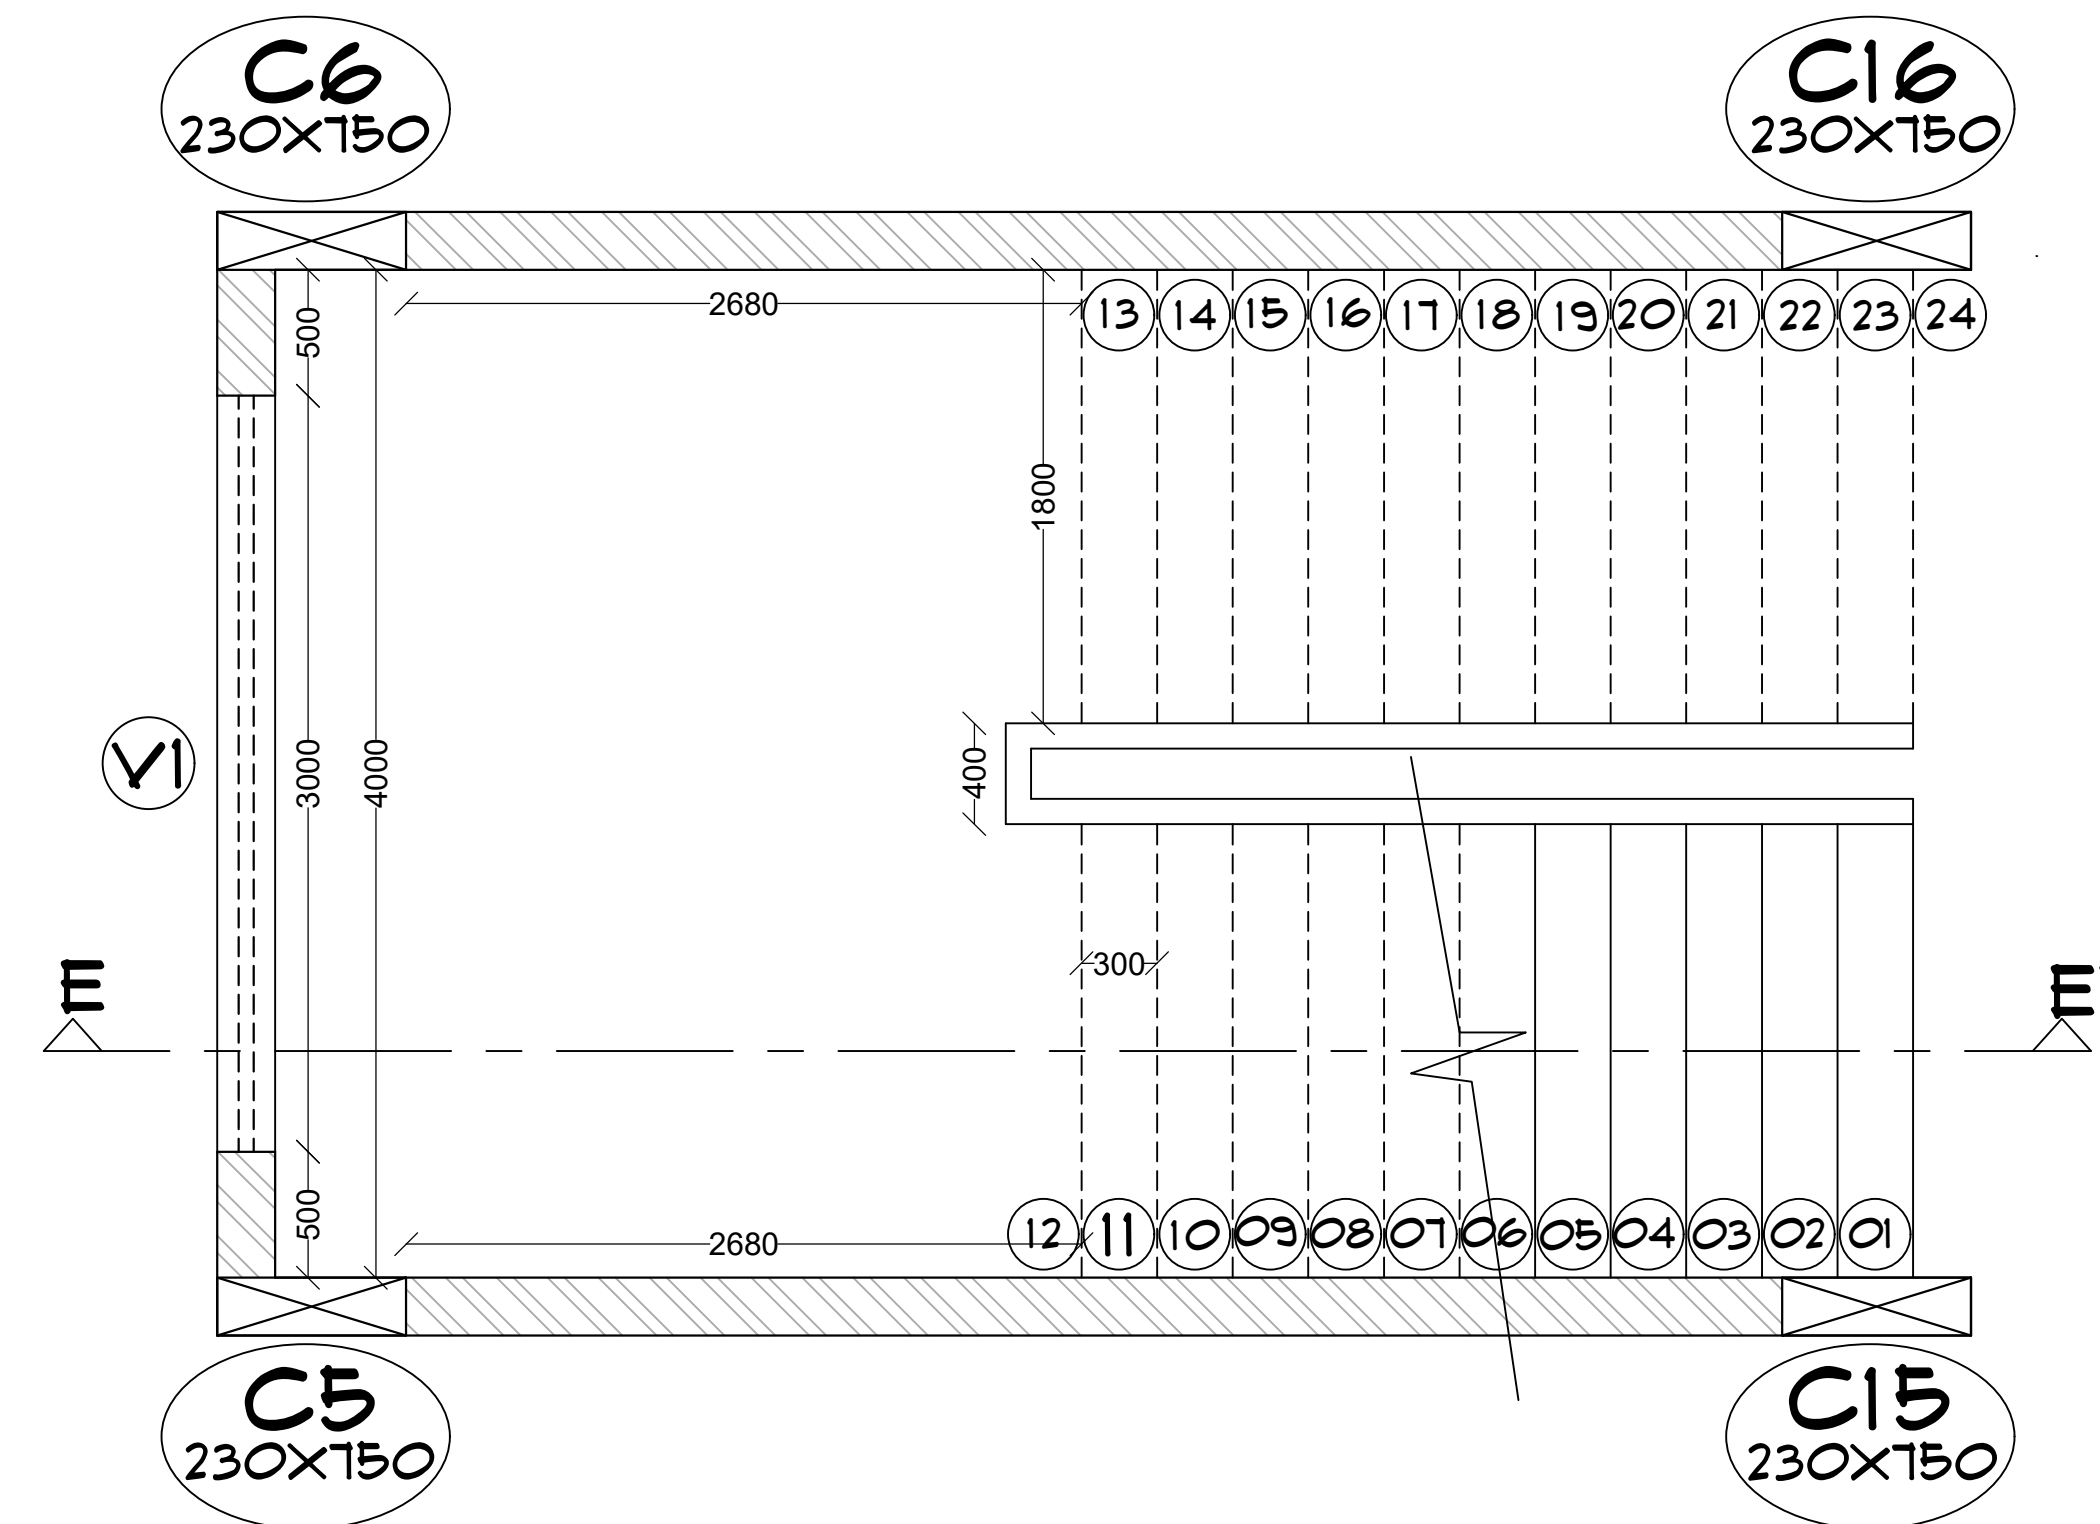

GROUND FLOOR STAIRCASE DETAIL
PLAN
SCALE - 1:30

PROFORMA -
WORKING DRAWING - II
SHEET TITLE -

STAIRCASE DETAIL

NOTES -

- 1) ALL DIMENSIONS ARE IN MM UNTIL SPECIFIED.
- 2) DO NOT MEASURE DRAWING, FOLLOW WRITTEN DIMENSIONS ONLY.
- 3) PLEASE REFER TO THE ARCHITECT IN CONCERN TO ANY QUERY OR DRAWING.
- 4) THIS DRAWING IS A PROPERTY OF THE ARCHITECT AND SHALL NOT BE REPRODUCED OR USED WITHOUT THEIR WRITTEN PERMISSION.

SCALE -	DATE -	REV NO. -
1 : 30	05/11/2024	
DRAWN BY -	CHECKED BY -	
VK	AR NS	

PROJECT -

PROPOSED
SHOPPING COMPLEX
AT SOLAPUR

ARCHITECT -

VAISHNAVI G. KARBHARI.
ROLL NO. - 99M/21/08
4TH YR, SEM VII (B.ARCH)
99M'S COLLEGE OF
ARCHITECTURE, SOLAPUR.

SIGN AND STAMP -

PROFORMA -

WORKING DRAWING - II

SHEET TITLE -

FLOORING LAYOUT

NOTES -

- 1) ALL DIMENSIONS ARE IN MM UNTIL SPECIFIED.
- 2) DO NOT MEASURE DRAWING, FOLLOW WRITTEN DIMENSIONS ONLY.
- 3) PLEASE REFER TO THE ARCHITECT IN CONCERN TO ANY QUERY OR DRAWING.
- 4) THIS DRAWING IS A PROPERTY OF THE ARCHITECT AND SHALL NOT BE REPRODUCED OR USED WITHOUT THEIR WRITTEN PERMISSION.

SCALE -

DATE -

REV NO. -

1 : 100


05/11/2024

DRAWN BY -

CHECKED BY -

YK

AR NS

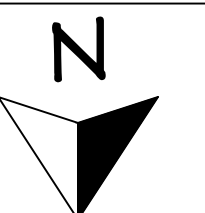


PROJECT -

**PROPOSED
SHOPPING COMPLEX
AT SOLAPUR**

ARCHITECT -



VAISHNAVI G. KARBHARI.
ROLL NO. - 55M/21/08
4TH YR, SEM VII (B.ARCH)
55M'S COLLEGE OF
ARCHITECTURE, SOLAPUR.

SIGN AND STAMP -

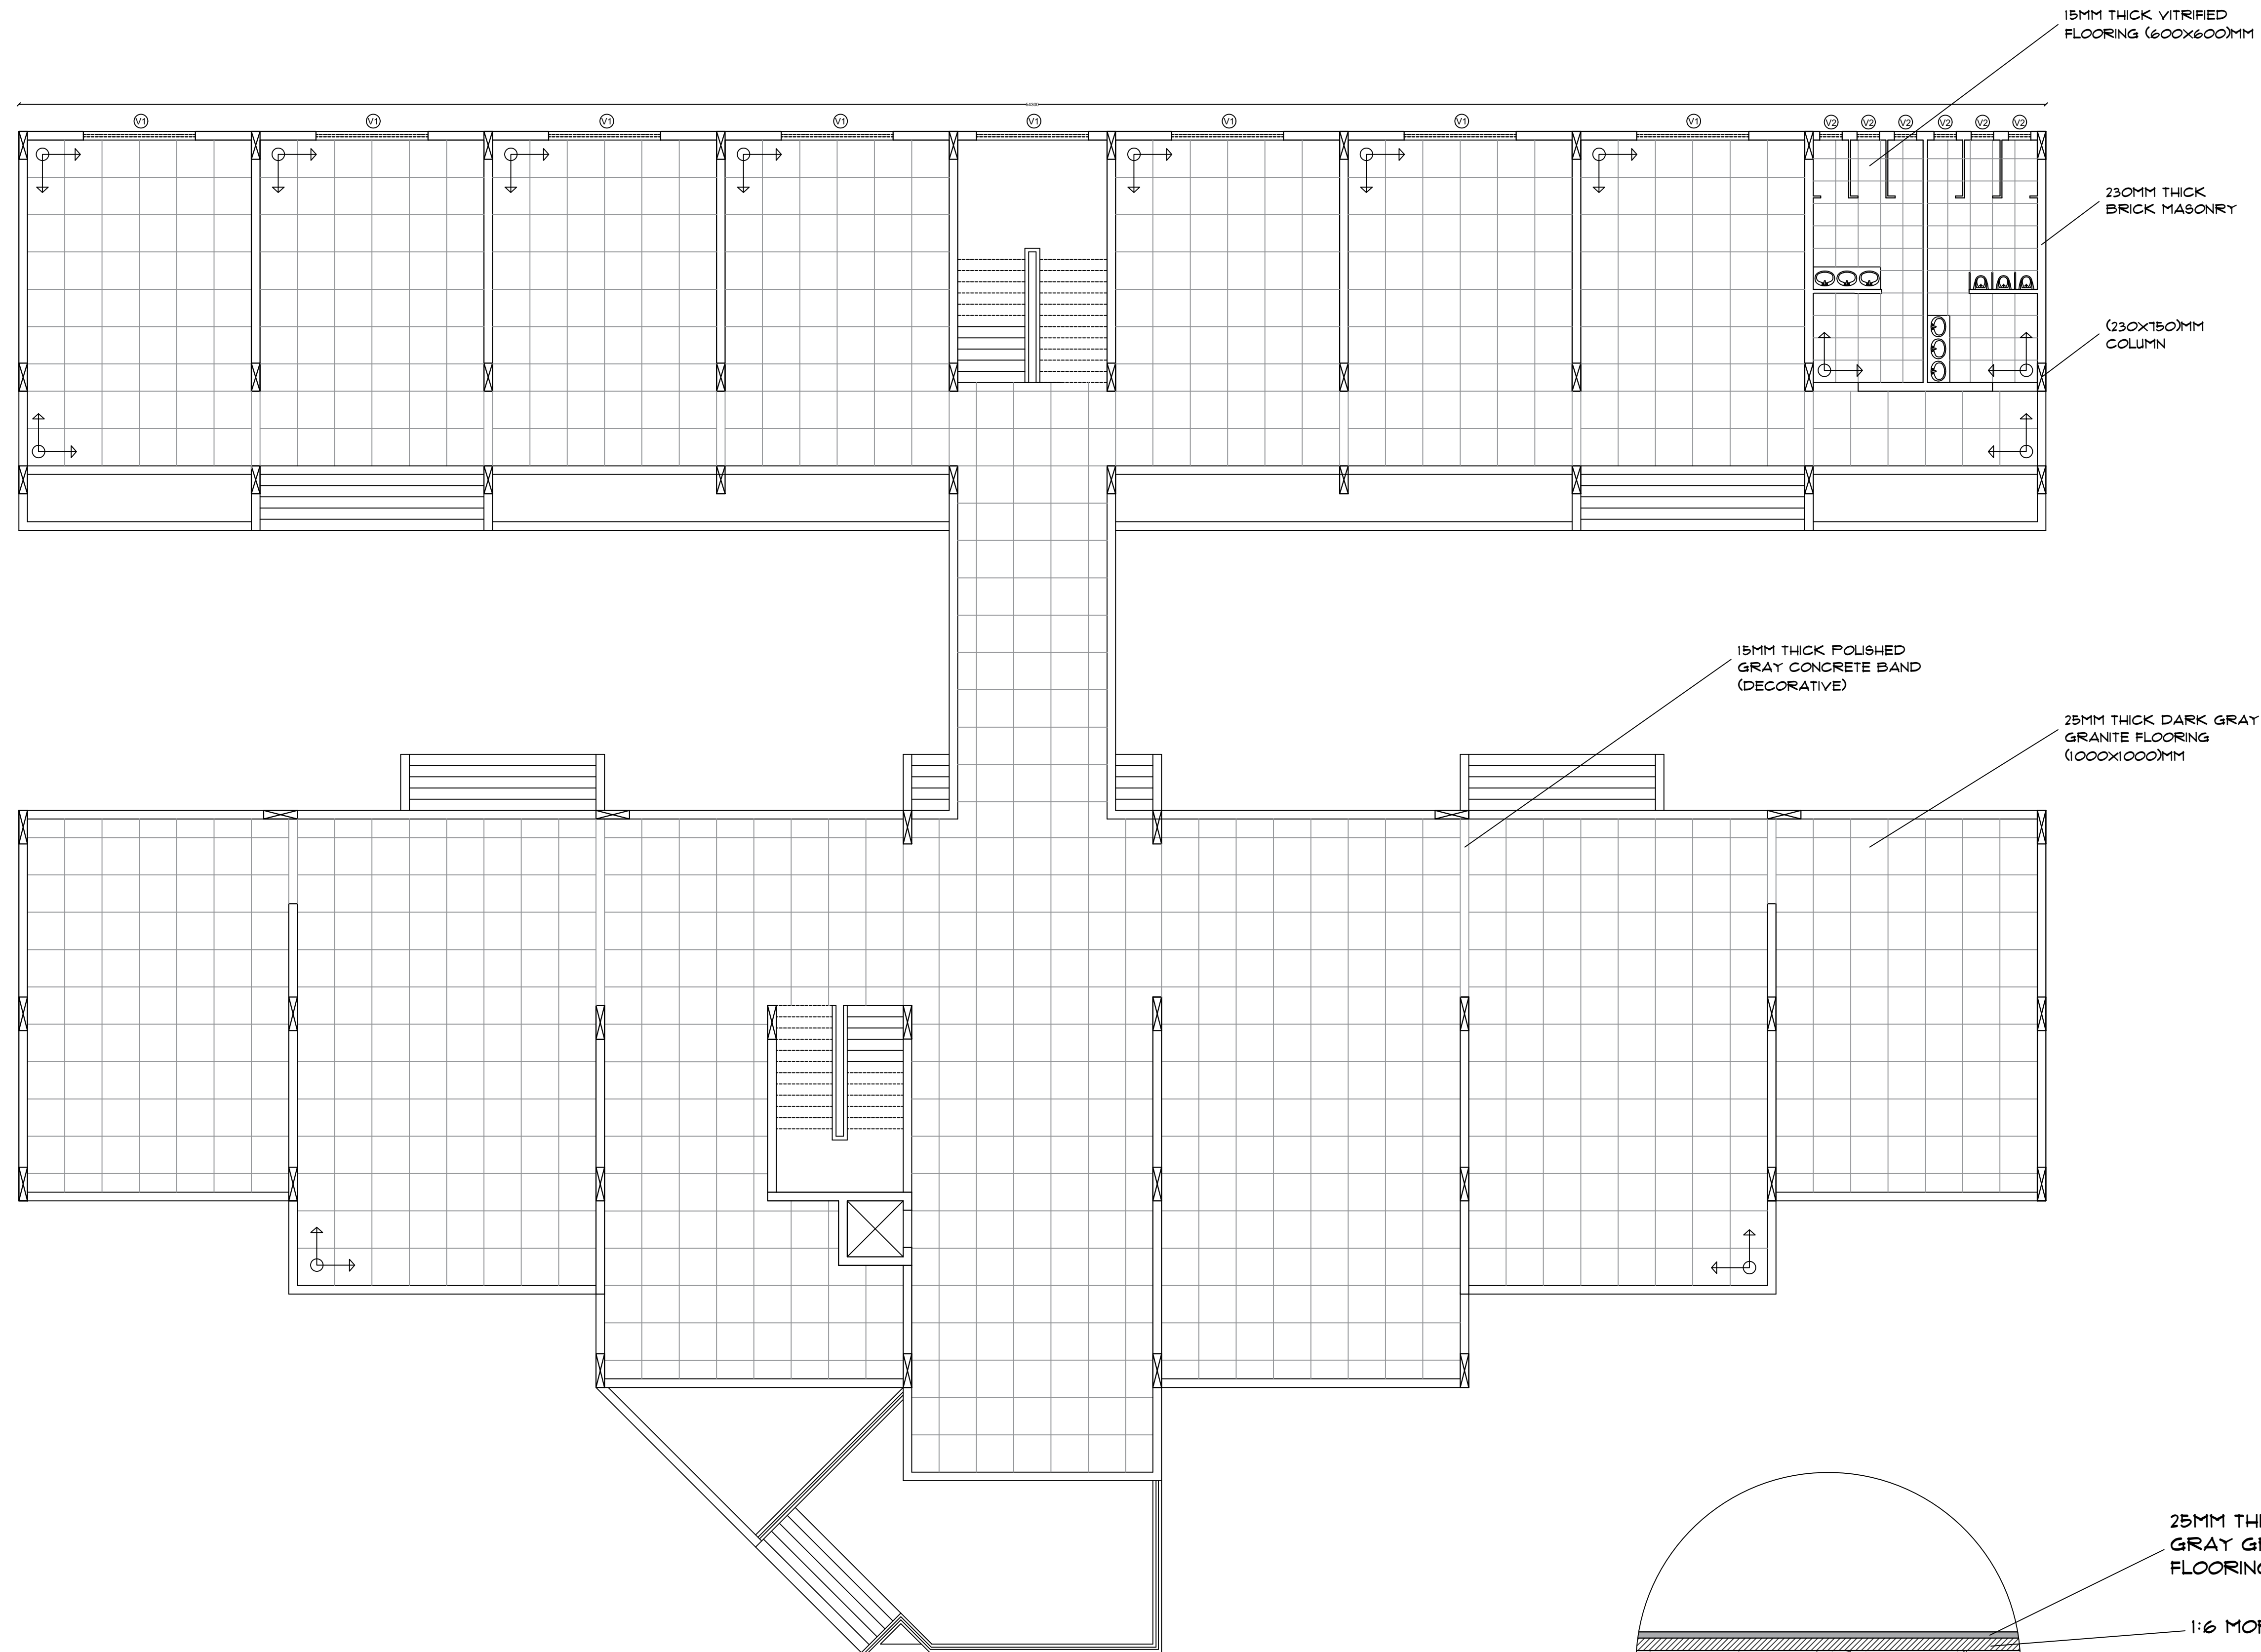


FIRST FLOOR FLOORING LAYOUT

SCALE - 1:100

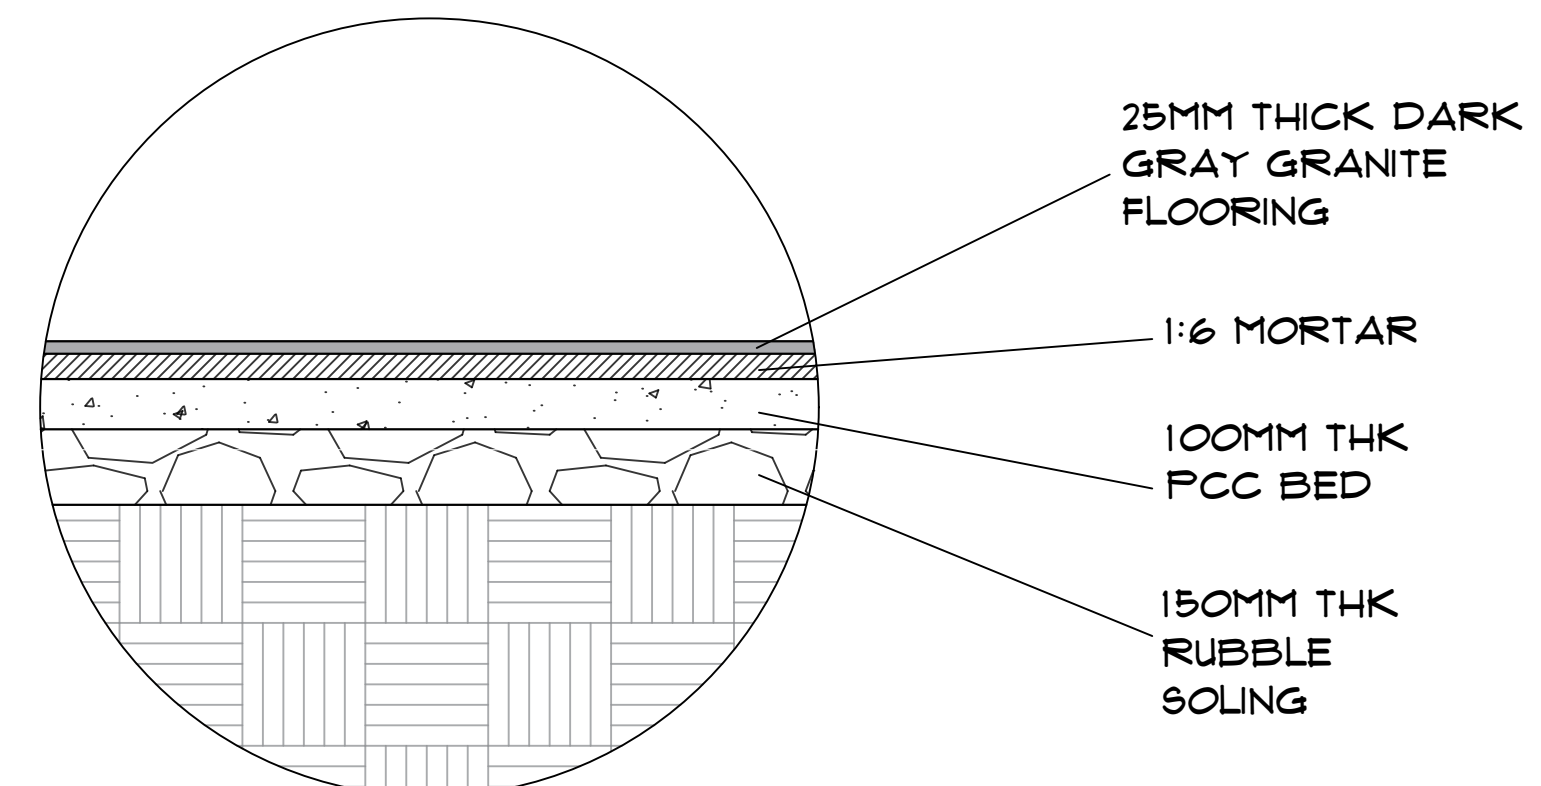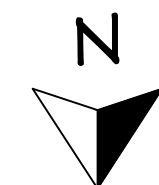


FLOORING DETAIL


SCALE - 1:100

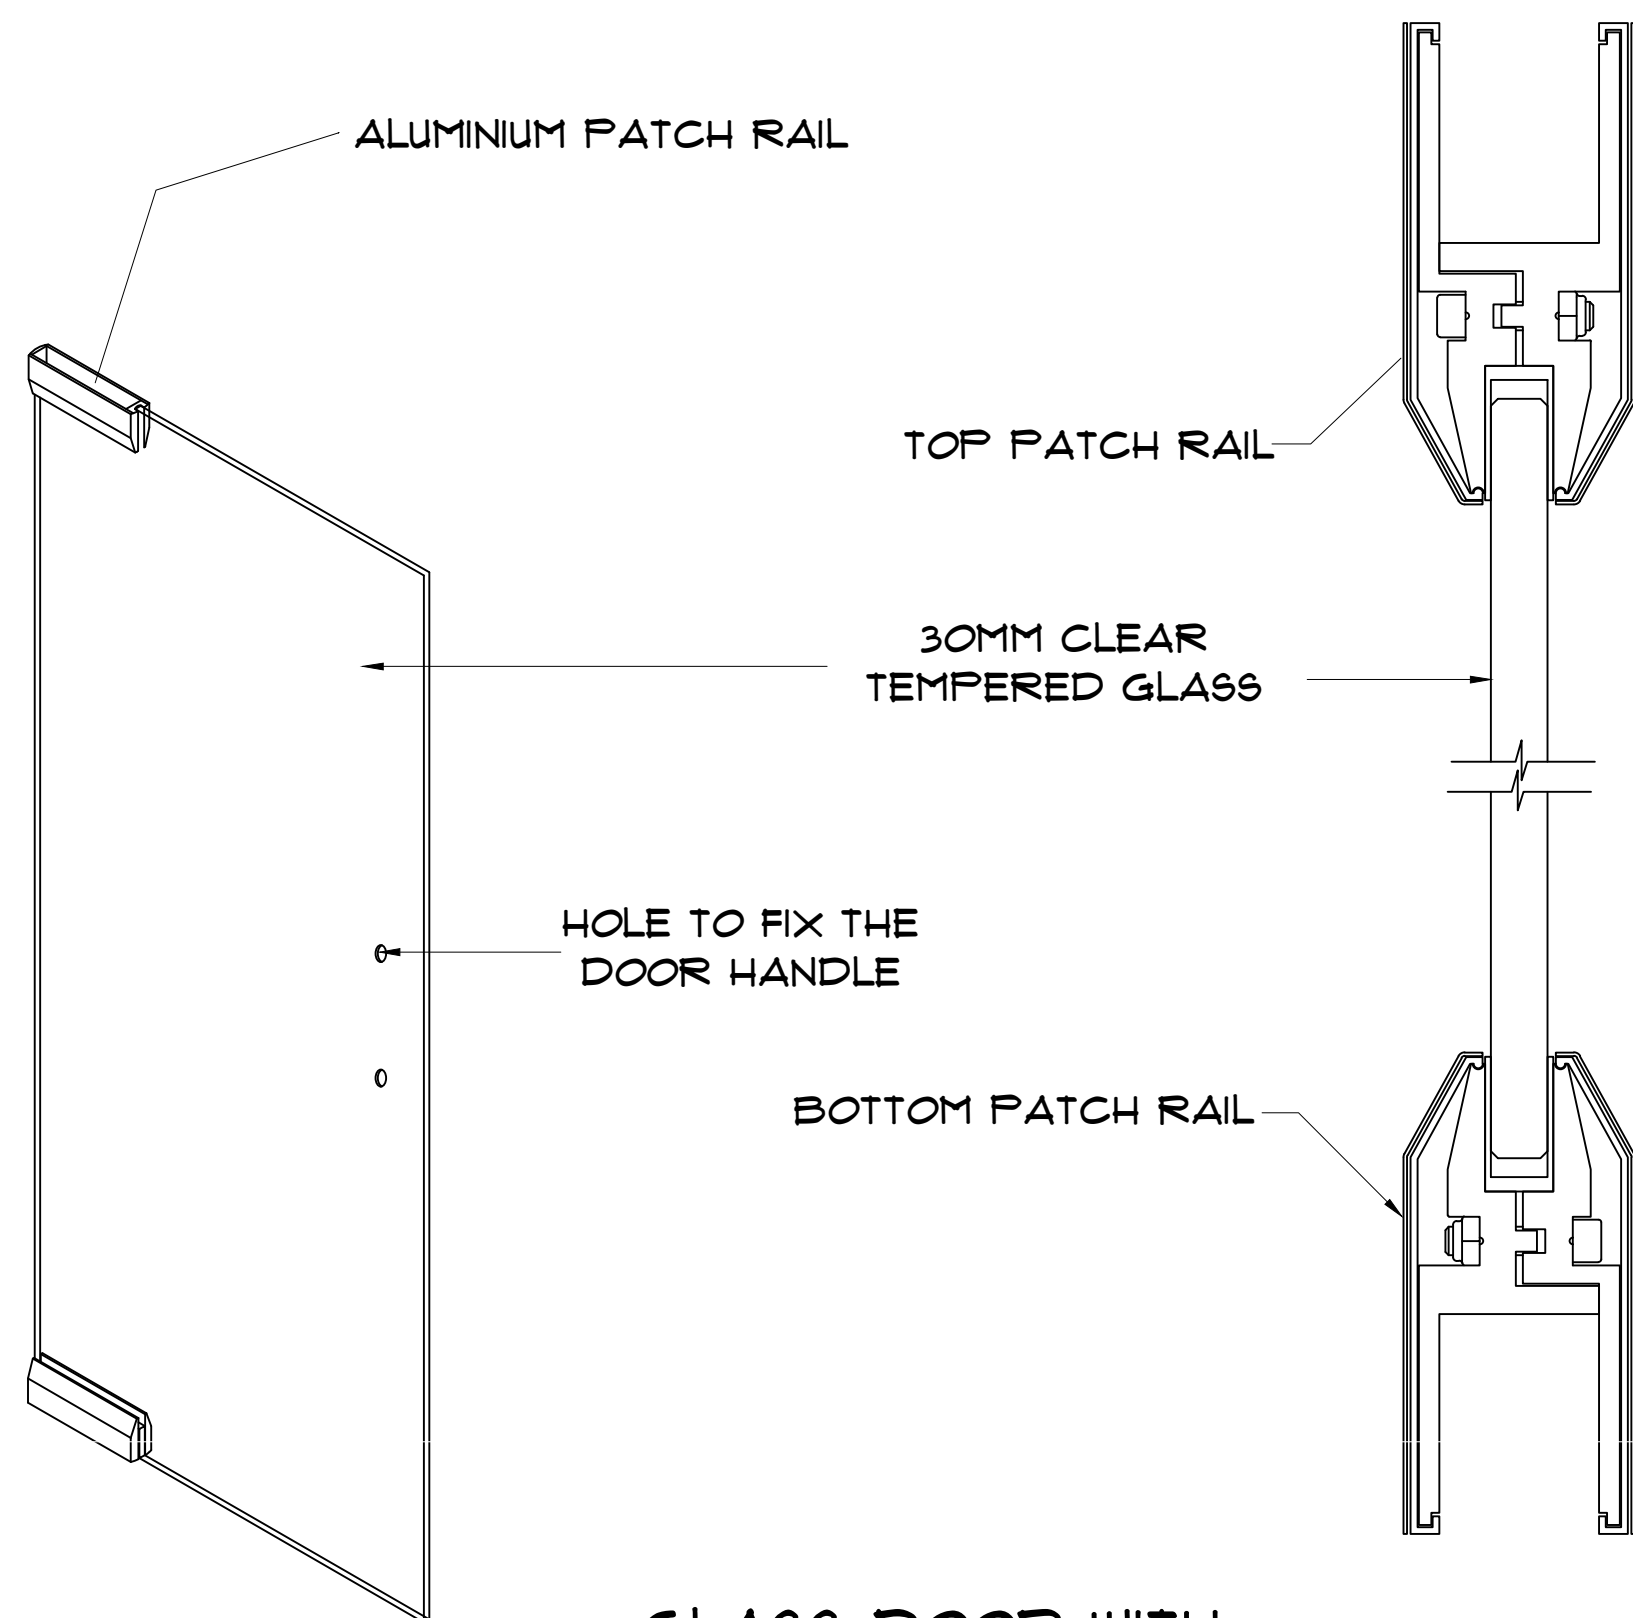


GLASS DOOR WITH
ALUMINIUM PATCH RAIL
SCALE - 1:4

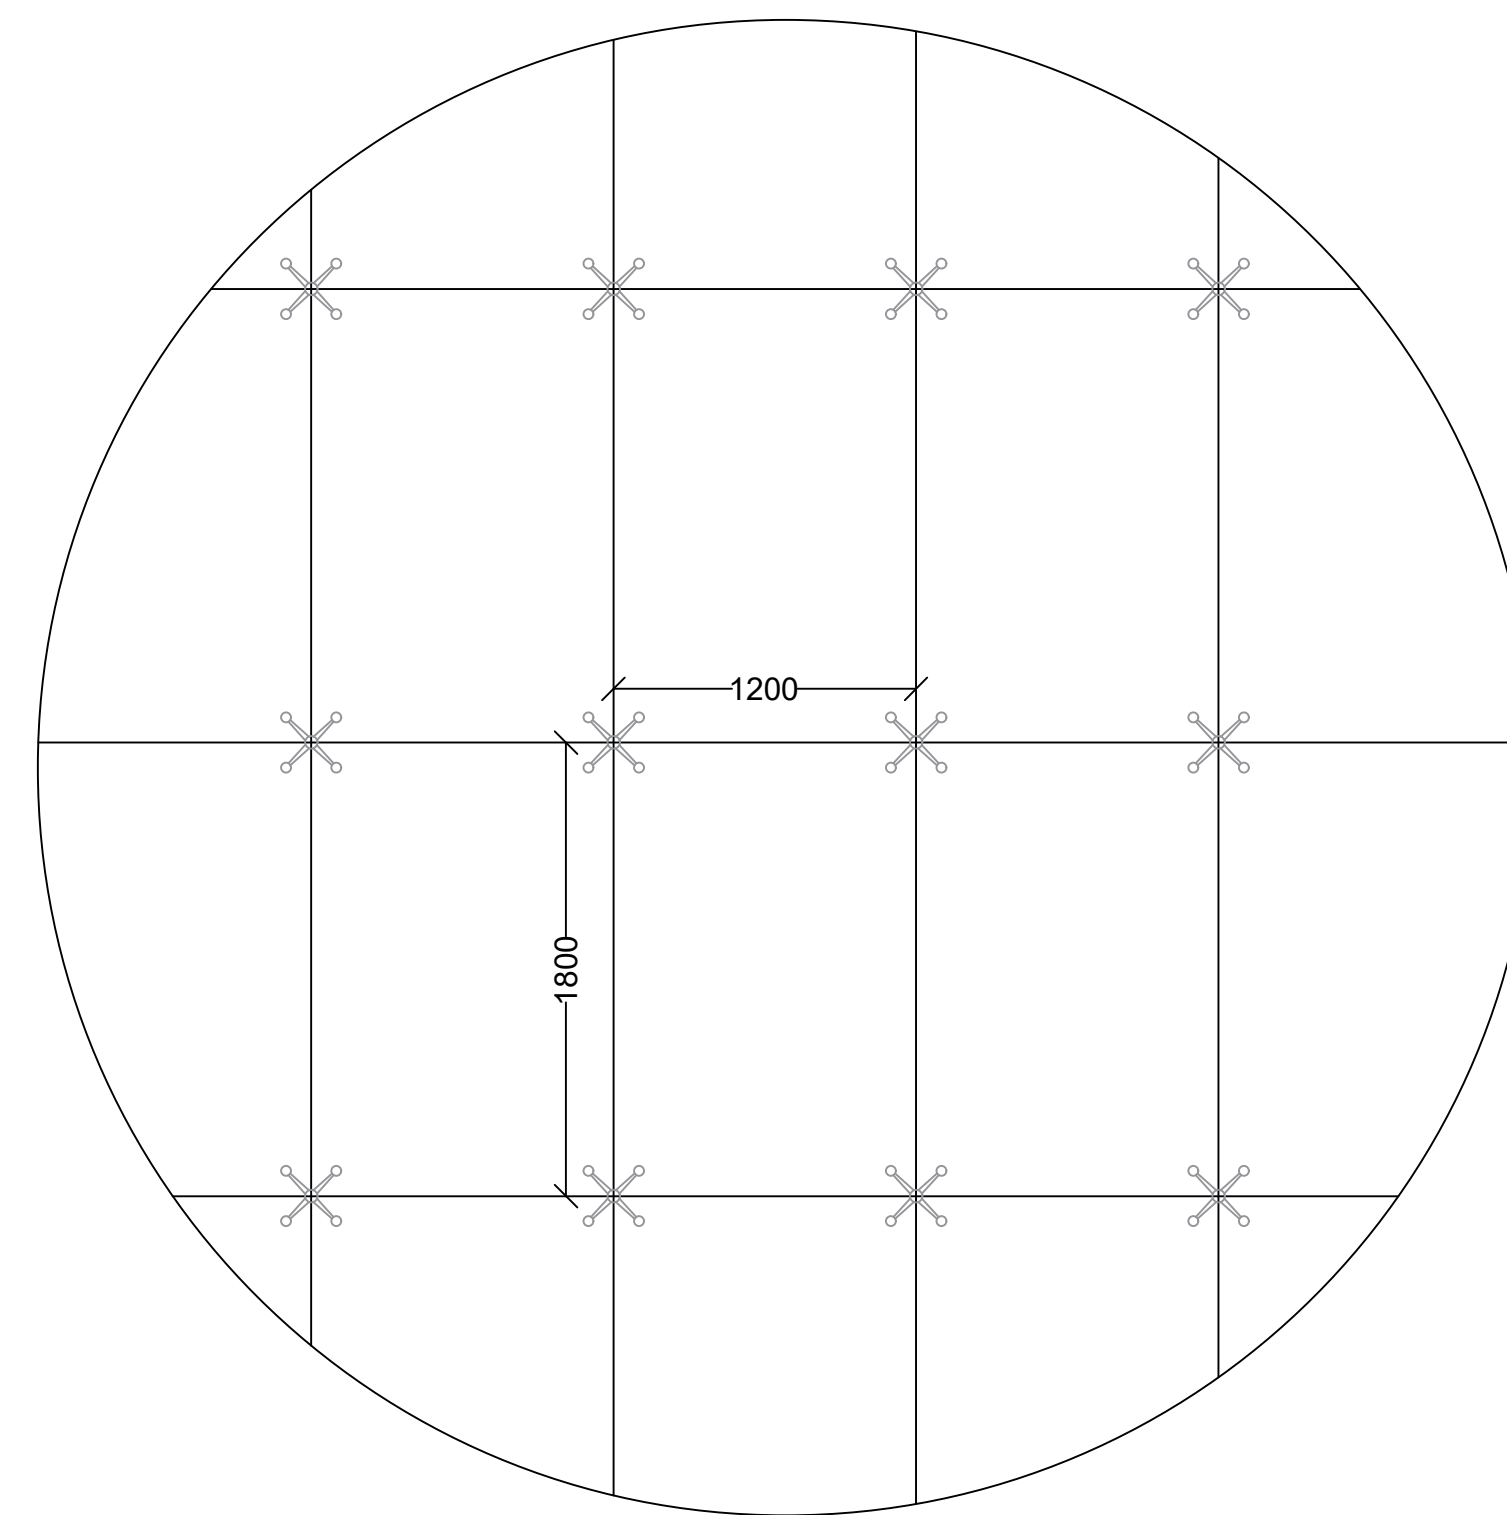


SPIDER FITTING
CURTAIN WALL
SCALE - 1:30

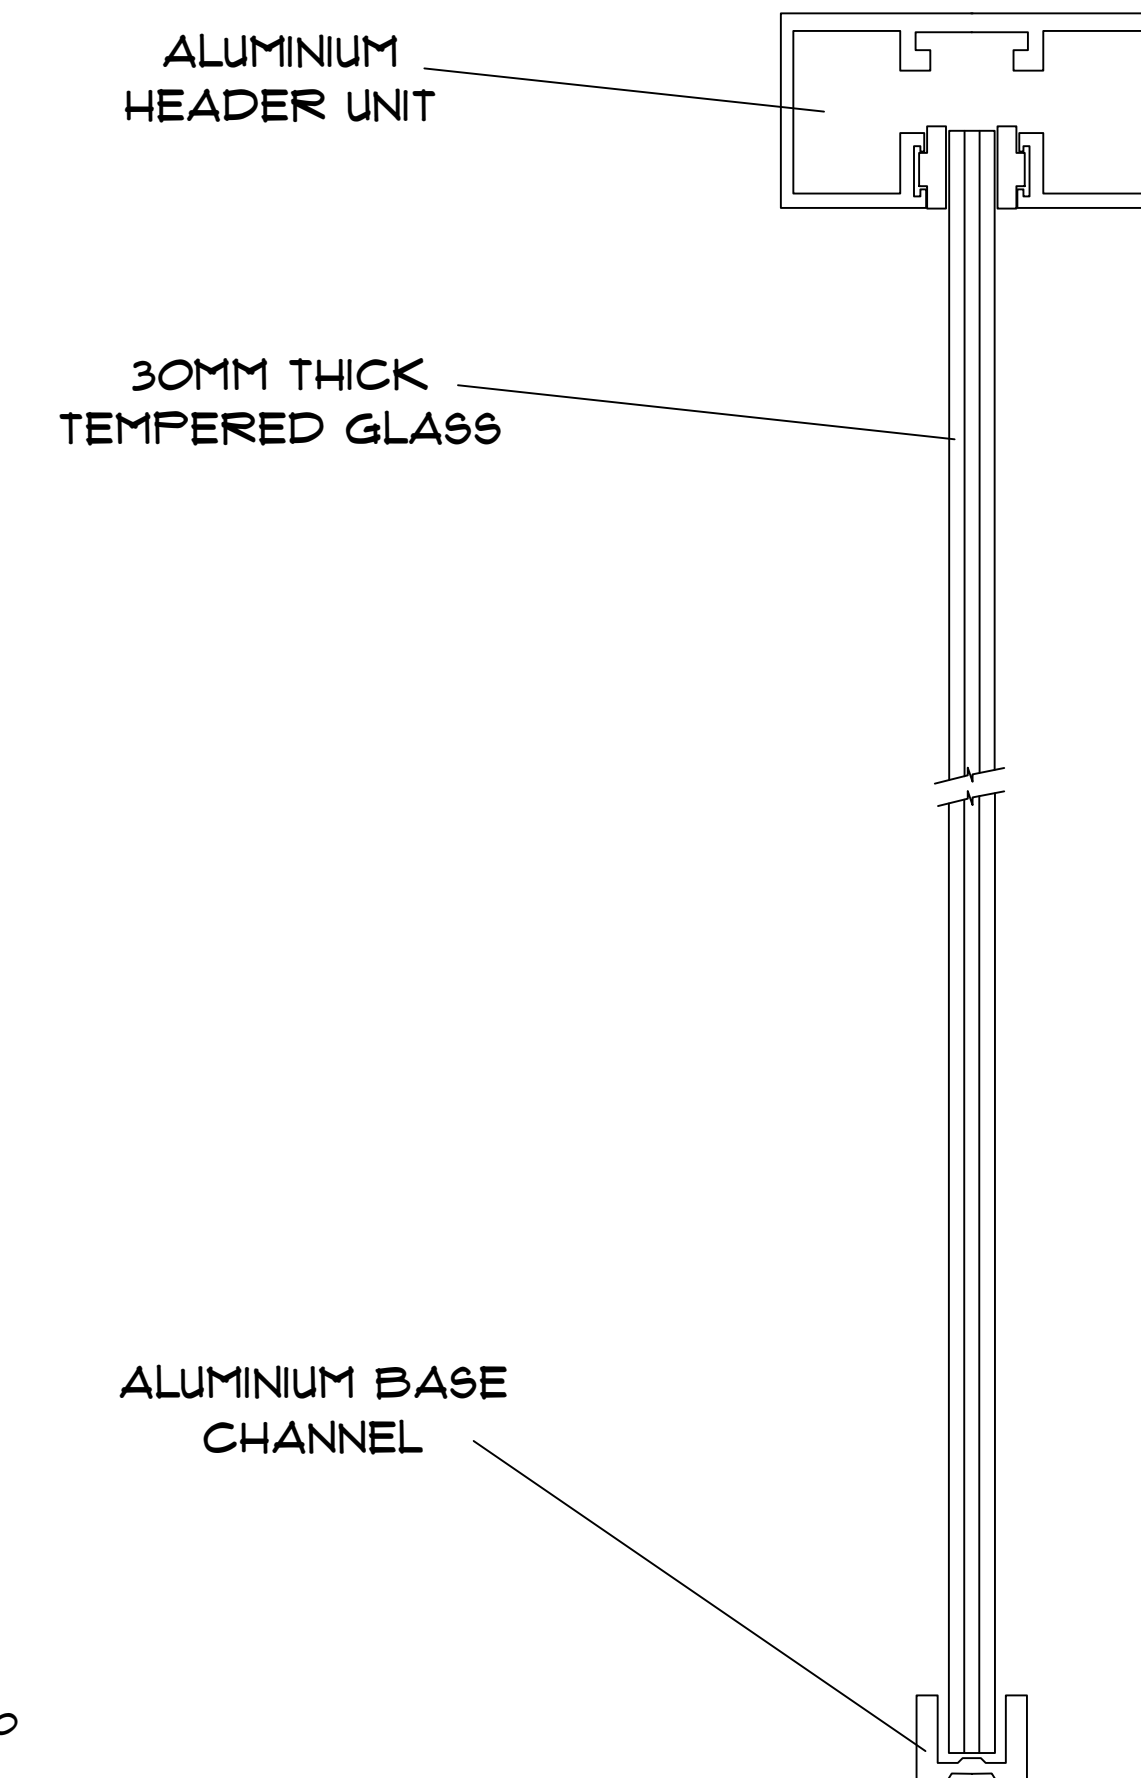


GLASS DOOR WITH
ALUMINIUM RAIL
SCALE - 1:5

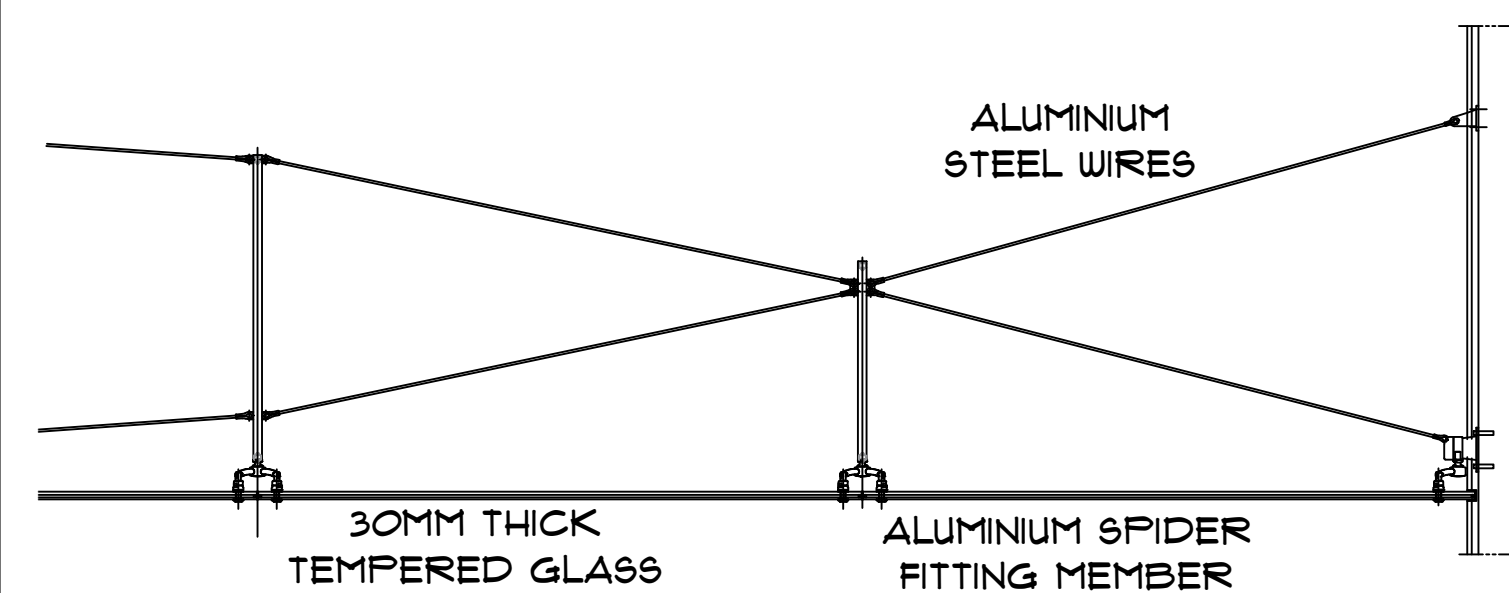

SPIDER FITTING DETAIL IN PLAN
SCALE - 1:15

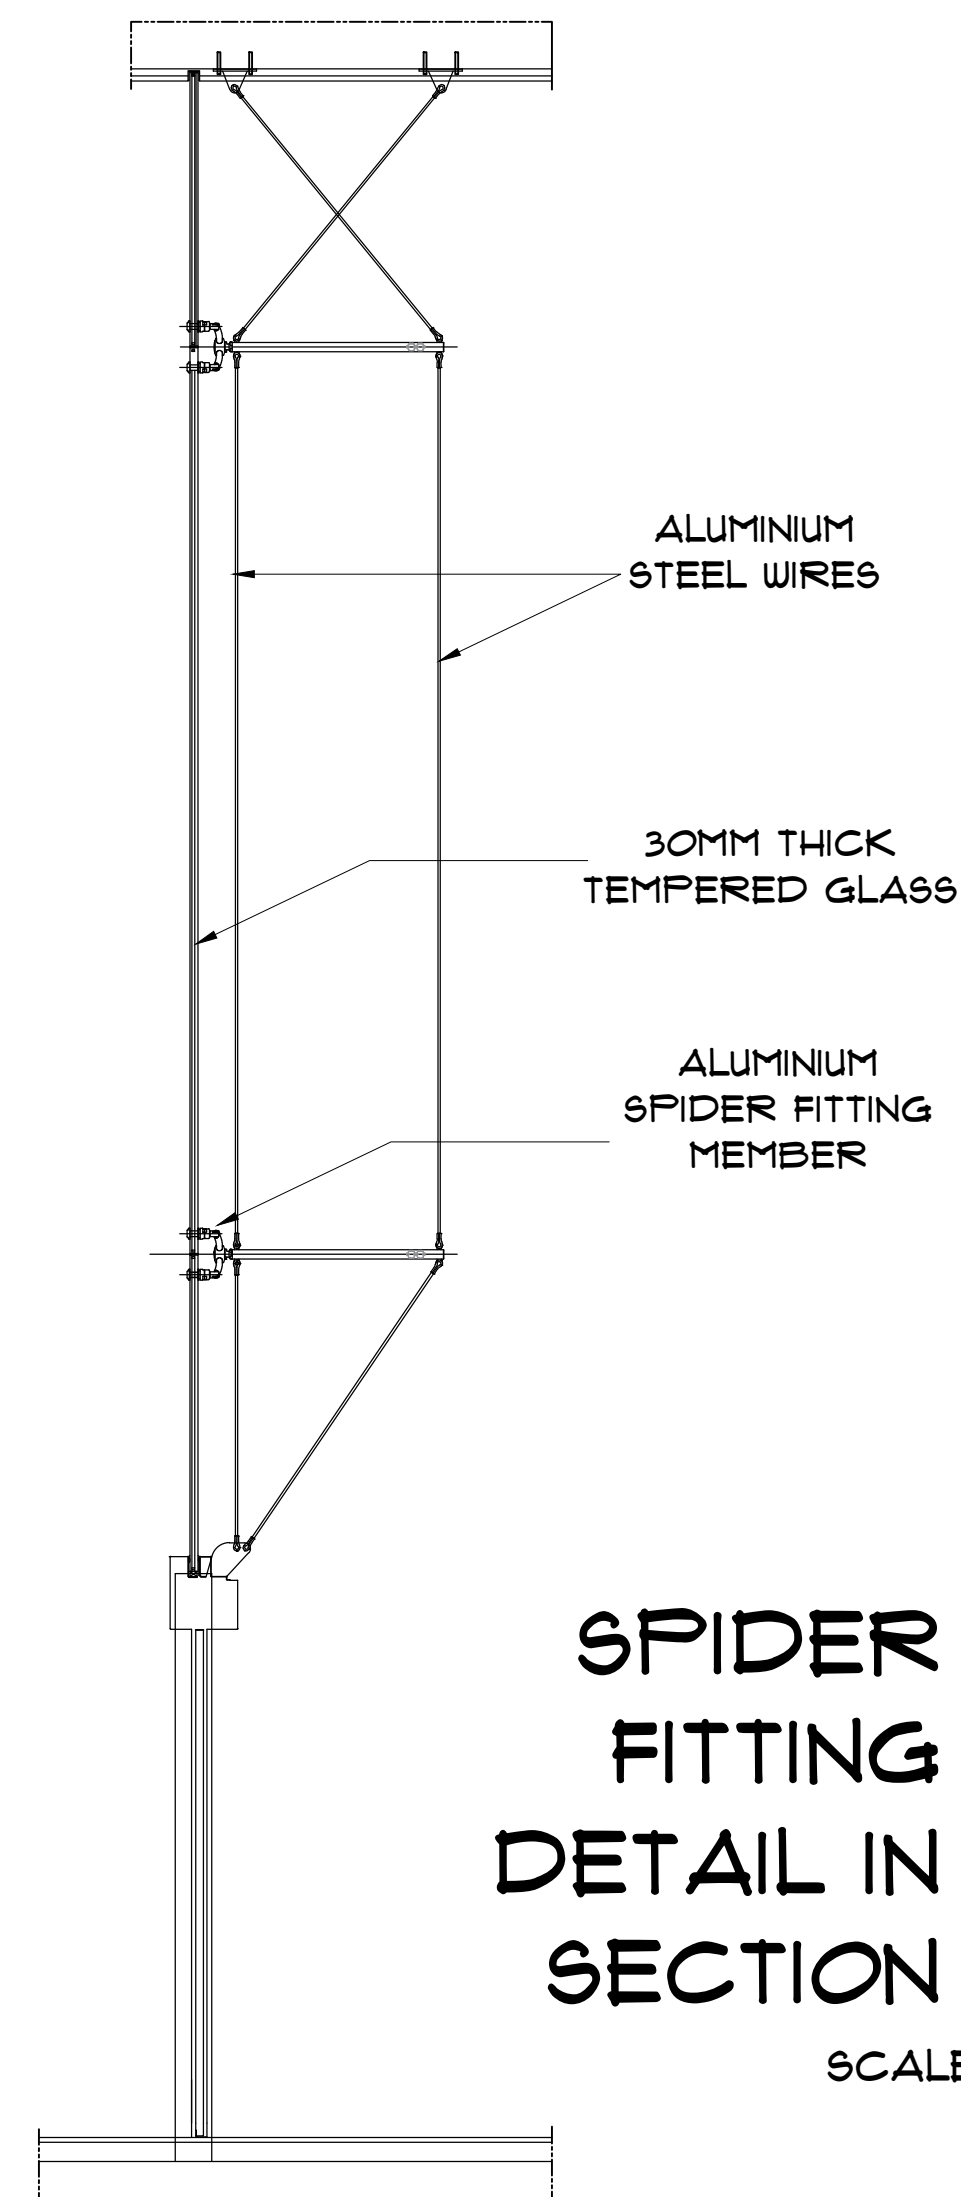

SPIDER
FITTING
DETAIL IN
SECTION
SCALE - 1:15

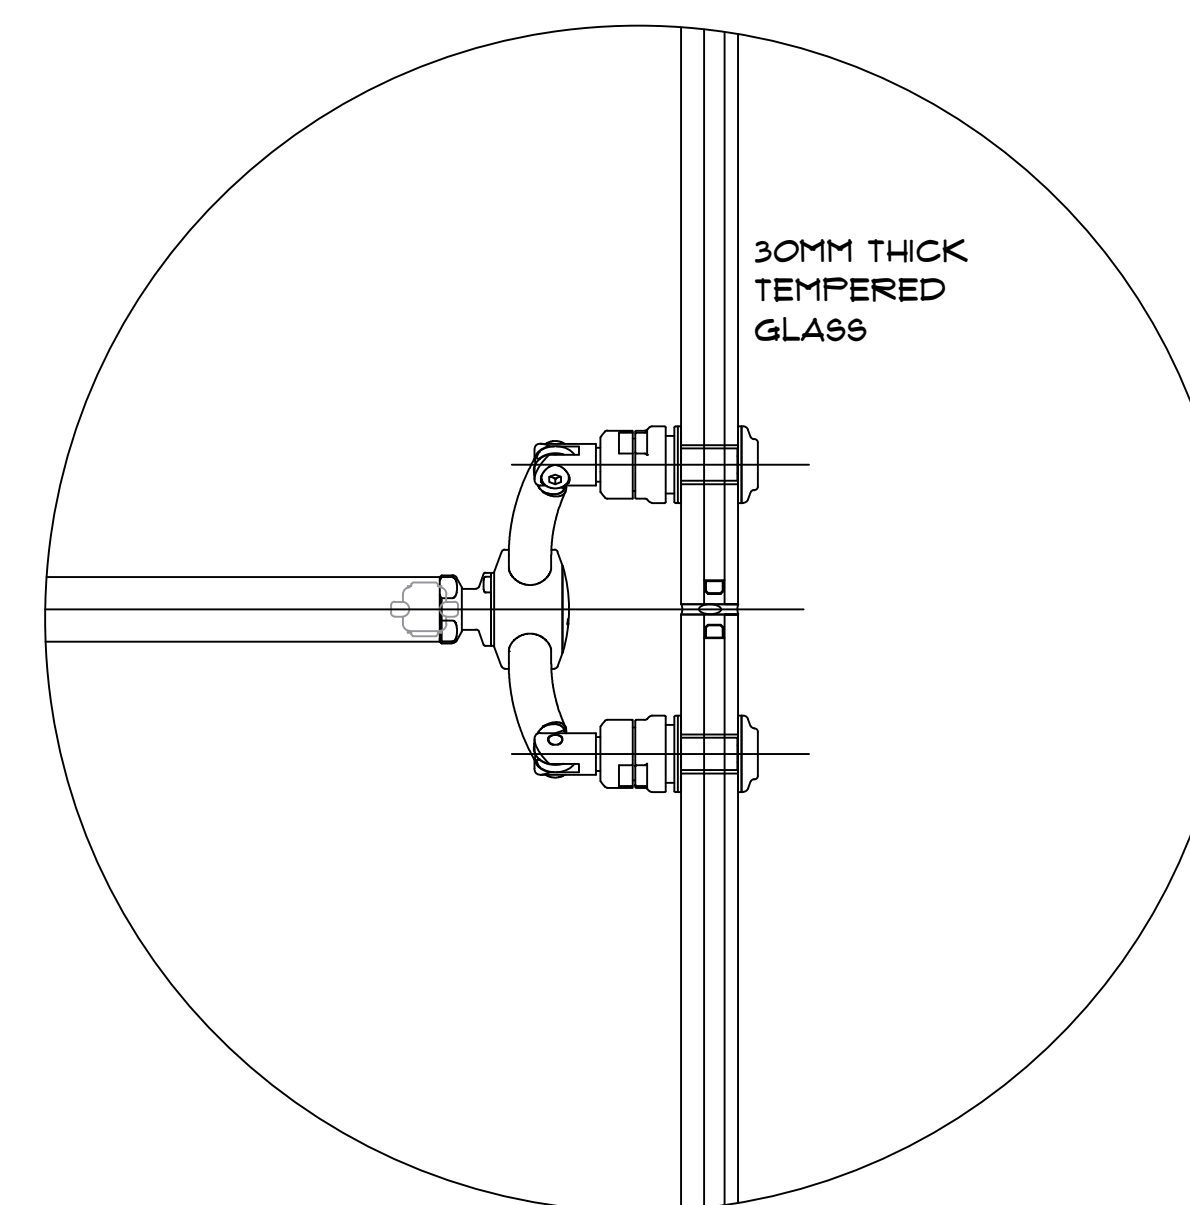

4-WAY FIXING SPIDER
FITTING DETAIL
SCALE - 1:2

PROFORMA -
WORKING DRAWING - II
SHEET TITLE -

CURTAIN WALL AND GLASS DOOR DETAIL

NOTES -

- 1) ALL DIMENSIONS ARE IN MM UNTIL SPECIFIED.
- 2) DO NOT MEASURE DRAWING, FOLLOW WRITTEN DIMENSIONS ONLY.
- 3) PLEASE REFER TO THE ARCHITECT IN CONCERN TO ANY QUERY OR DRAWING.
- 4) THIS DRAWING IS A PROPERTY OF THE ARCHITECT AND SHALL NOT BE REPRODUCED OR USED WITHOUT THEIR WRITTEN PERMISSION.

SCALE -	DATE -	REV NO. -
1:100	10/10/2024	
DRAWN BY - VK	CHECKED BY - AR NS	

PROJECT -

PROPOSED SHOPPING COMPLEX AT SOLAPUR

ARCHITECT -

VAISHNAVI G. KARBHARI.
ROLL NO. - 99M/21/08
4TH YR, SEM VII (B.ARCH)
99M'S COLLEGE OF
ARCHITECTURE, SOLAPUR.

SIGN AND STAMP -